


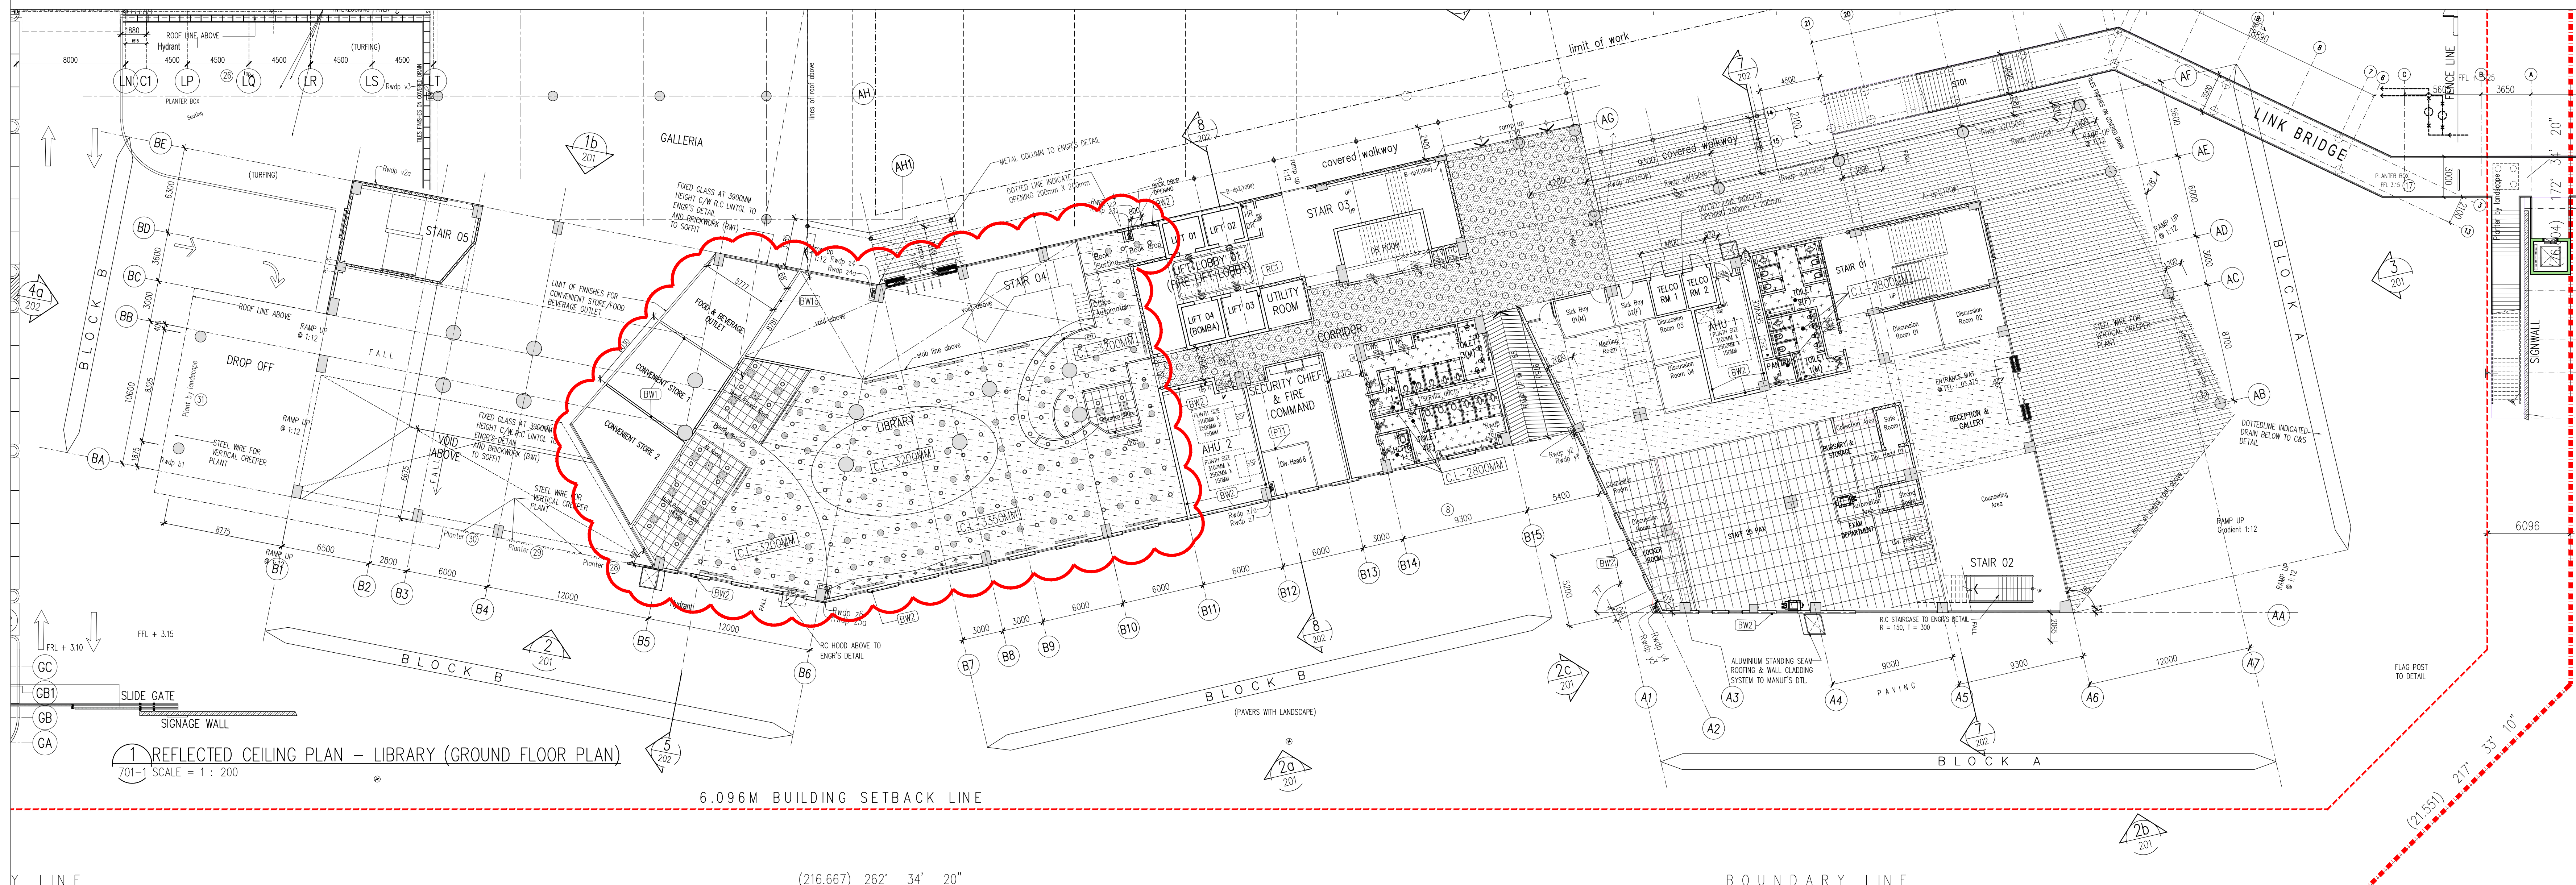

LEGEND

	DOWNLIGHT
	LIGHTING POINT FOR PENDANT LIGHT
	AC SUPPLY (CIRCULAR)
	AC SUPPLY (RECTANGULAR)
	AC RETURN (LINEAR)
	AC RETURN (RECTANGULAR)

NOTE:

M&E TO PROVIDE AND COORDINATE ALL THE SERVICES TO COMPLY WITH THE LIGHTING LUX LEVEL AND AIR CONDITION DISTRIBUTION REQUIREMENT.

REV.	DATE	DESCRIPTION	REMARK
A	23.11.2016	FIRST ISSUE FOR CONSTRUCTION DRAWING	FAH/ATAN
C	20.07.2017	REVISED CEILING LAYOUT FOR LIBRARY HALL AS PER REVISION CLOUD (JRD AND FIRST FLOOR LEVEL)	

LEGEND

RAILING TYPE

RL-1	INTERNAL RAILING OF STAIRCASE
RL-2	FLOOR MOUNTED RAILING ALONG CORRIDOR
RL-3	GLASS RAILING
RL-4	PARAPET WALL
RL-5	FLOOR MOUNTED GUARD RAIL

WALL TYPE


BW1	150MM THK. BROOKWALL WITH 20MM CENT. PLASTER ON BOTH SIDES
BW10	150MM THK. BROOKWALL WITH 300MM UPSTAND BEAM & 20MM THK. CENT. PLASTER ON BOTH SIDES
BW2	230MM THK. BROOKWALL WITH 20MM THK. CENT. PLASTER ON BOTH SIDES
BW20	230MM THK. BROOKWALL WITH 300MM UPSTAND BEAM & 20MM THK. CENT. PLASTER ON BOTH SIDES
PT	20MM THK. DRYWALL PARTITION WITH PAINTED ON BOTH SIDE TO MANUF'S SPECIFICATION
RC1	250mm RC WALL WITH 5mm THK. SKIM COAT

- 2 HOUR FIRE RATED BROOKWALL WITH 20MM CENT. PLASTER ON BOTH SIDES UP TO SOFFIT SLAB
- WALL TYPE ARE GENERALLY (BUT) EXCEPT OTHERWISE STATED.
- ALL ELECTRICAL ROOM TO BE 4 HOUR FIRE RATED BROOKWALL WITH 20MM CENT. PLASTER ON BOTH SIDES UP TO SOFFIT SLAB

GENERAL NOTE :

- ALL KITCHEN DETAIL TO REFER TO TSP SUBMISSION
- IN THE EVENT OF DISCREPANCY BETWEEN DRAWINGS, SCHEDULE OF FINISHES WILL TAKE A FINAL PRECEDENT
- TO PROVIDE NON SLIP TILES FOR ALL MET AREA I.E. TOILET, ABUITION, PANTRY, JANITOR, KITCHEN
- ALL INTERNAL WALLS OF TOILET, PANTRY, JANITOR, ABUITION TO BE FINISHED WITH GLAZED WALL TILES UP TO CEILING HEIGHT OR OTHERWISE STATED
- ALL WARE RISER TO BE BASED 100MM AND ALL WARE & C/W TO BE DROP 100MM FROM MAIN FLOOR OR CORRIDOR UNLESS OTHERWISE STATED
- ALL BUILDING PERIMETER DRAIN TO BE CONCEALED OR OTHERWISE STATED
- ALL LVPVC FLOOR TO BE 200MM & UNLESS OTHERWISE STATED
- ALL FINISHES REFER TO SCHEDULE OF FINISHES
- ALL WEE OPENING TO PROVIDE R.C. UNITS, REFER TO ENGR'S DRAWING

KEY PLAN

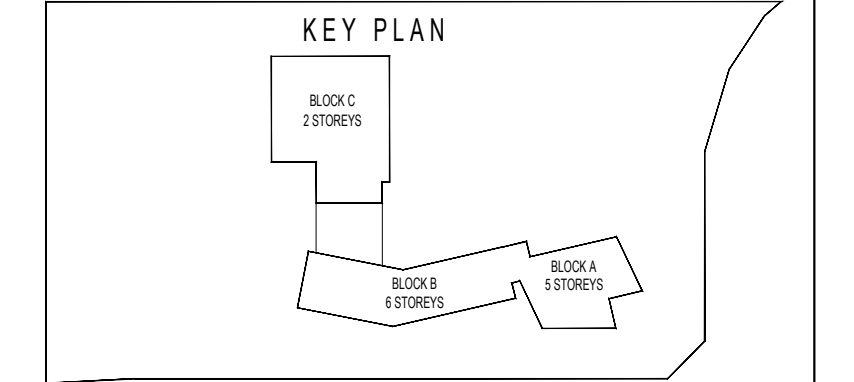

PROJECT TITLE

CADANGAN MEMBINA SEBUAH KOLEJ UNIVERSITI SWASTA DI ATAS PT 6828, PERSIARAN CASSIA BARAT 3, BATU KAWAN, MK. 13, SEBERANG PERAI SELATAN YANG MENGANDUNGI:
BLOK A - PUSAT PENTABIRAN 5 TINGKAT
BLOK B - PERPUSTAKAAN DAN BILIK KULIAH 6 TINGKAT
BLOK C - BANGUNAN PENYELENGAAN DAN KAFETERIA 1 TINGKAT
2 UNIT PONDOK PENGAWAL DAN
1 UNIT TBN 11 KV STESEN SUKSES UTAMA

UNTUK : TETUAN KDU COLLEGE (PG) SDN. BHD

LAND OWNER & BUILDING OWNER :

NAMA : DR. CHONG BENG KEOK
JAWATAN : KETUA PEJABAT EKSEKUTIF (CEO)
NO. IC : 810702-02-5046
ALAMAT : KDU COLLEGE (PG) SDN BHD
10400, GEORGE TOWN, PULAU PINANG
NO. TEL : 604-2380808
FAX : 604-2380808
E-MAIL : info@kdu.com.my
www.kdu.com.my

PITCHER SPECIALIST

DISHES SDN BHD
NO. 21-1, JALAN SEMENYIH SENTRAL 1,
SEMENYIH, 43500, SELANGOR
TEL : +603-8723-7020
E-MAIL : info@dishes.com.my
www.dishes.com.my

GE CONSULTANT

UNITECH QS CONSULTANCY SDN. BHD.
12A-A, MENARA NORTHEAST,
55, JALAN SULTAN AHMAD SHAH,
10050 PENANG
TEL : (604) 3337990
FAX : (604) 3317337
E-MAIL : info@unitech.com.my
www.unitech.com.my

M&E CONSULTANT

PERUNDING P.L.A.
Consulting Mechanical & Electrical Engineers
8-01, MISMA PANTAL,
JALAN WOMA PANTAL,
12200 BUTTERWORTH, PENANG.
TEL : (604) 3337990
FAX : (604) 3317337
E-MAIL : info@perunding.com.my
www.perunding.com.my

C&S CONSULTANT

PERUNDING KELANA
CIVIL & STRUCTURAL ENGINEERS
Level 12, Unit 1201, Wisma Boon Sen,
No.1, Persiaran Bukit, 10000 Penang
Tel: 2622928, Fax: 2641618
(Company No. 4332772-03)

DESIGN ARCHITECT

ARCHITECTURE GROUP - STUDIO A
CPG CONSULTANTS PTE LTD
238B, THOMSON ROAD, #12-00 TOWER B
NOVINA SQUARE, SINGAPORE 307995
TEL : +65 6307 4469 FAX : +65 6307 4469

ARCHITECT

BH YEW
ARCHITECT (SP/761)
15TH FLOOR, BANGUNAN ANNETTEPUE,
NO.1, JALAN LUMUT, 50400 KUALA LUMPUR
TEL: (03) 4043-1346 FAX: (03) 4043-1349
EMAIL: yehw@bhsb.com.my

CONSTRUCTION DRAWING

DRAWING TITLE :
REFLECTED CEILING PLAN -
FOR LIBRARY
GROUND FLOOR PLAN
FIRST FLOOR PLAN

DRAWING NO.

AS SHOWN
553_CA2-701-1-01-C.dwg
553-1
Mr. Farid/Mr. Affan
NOV 2016

PROJECT NO.

55314
CA
RCP
701-1
01
C