


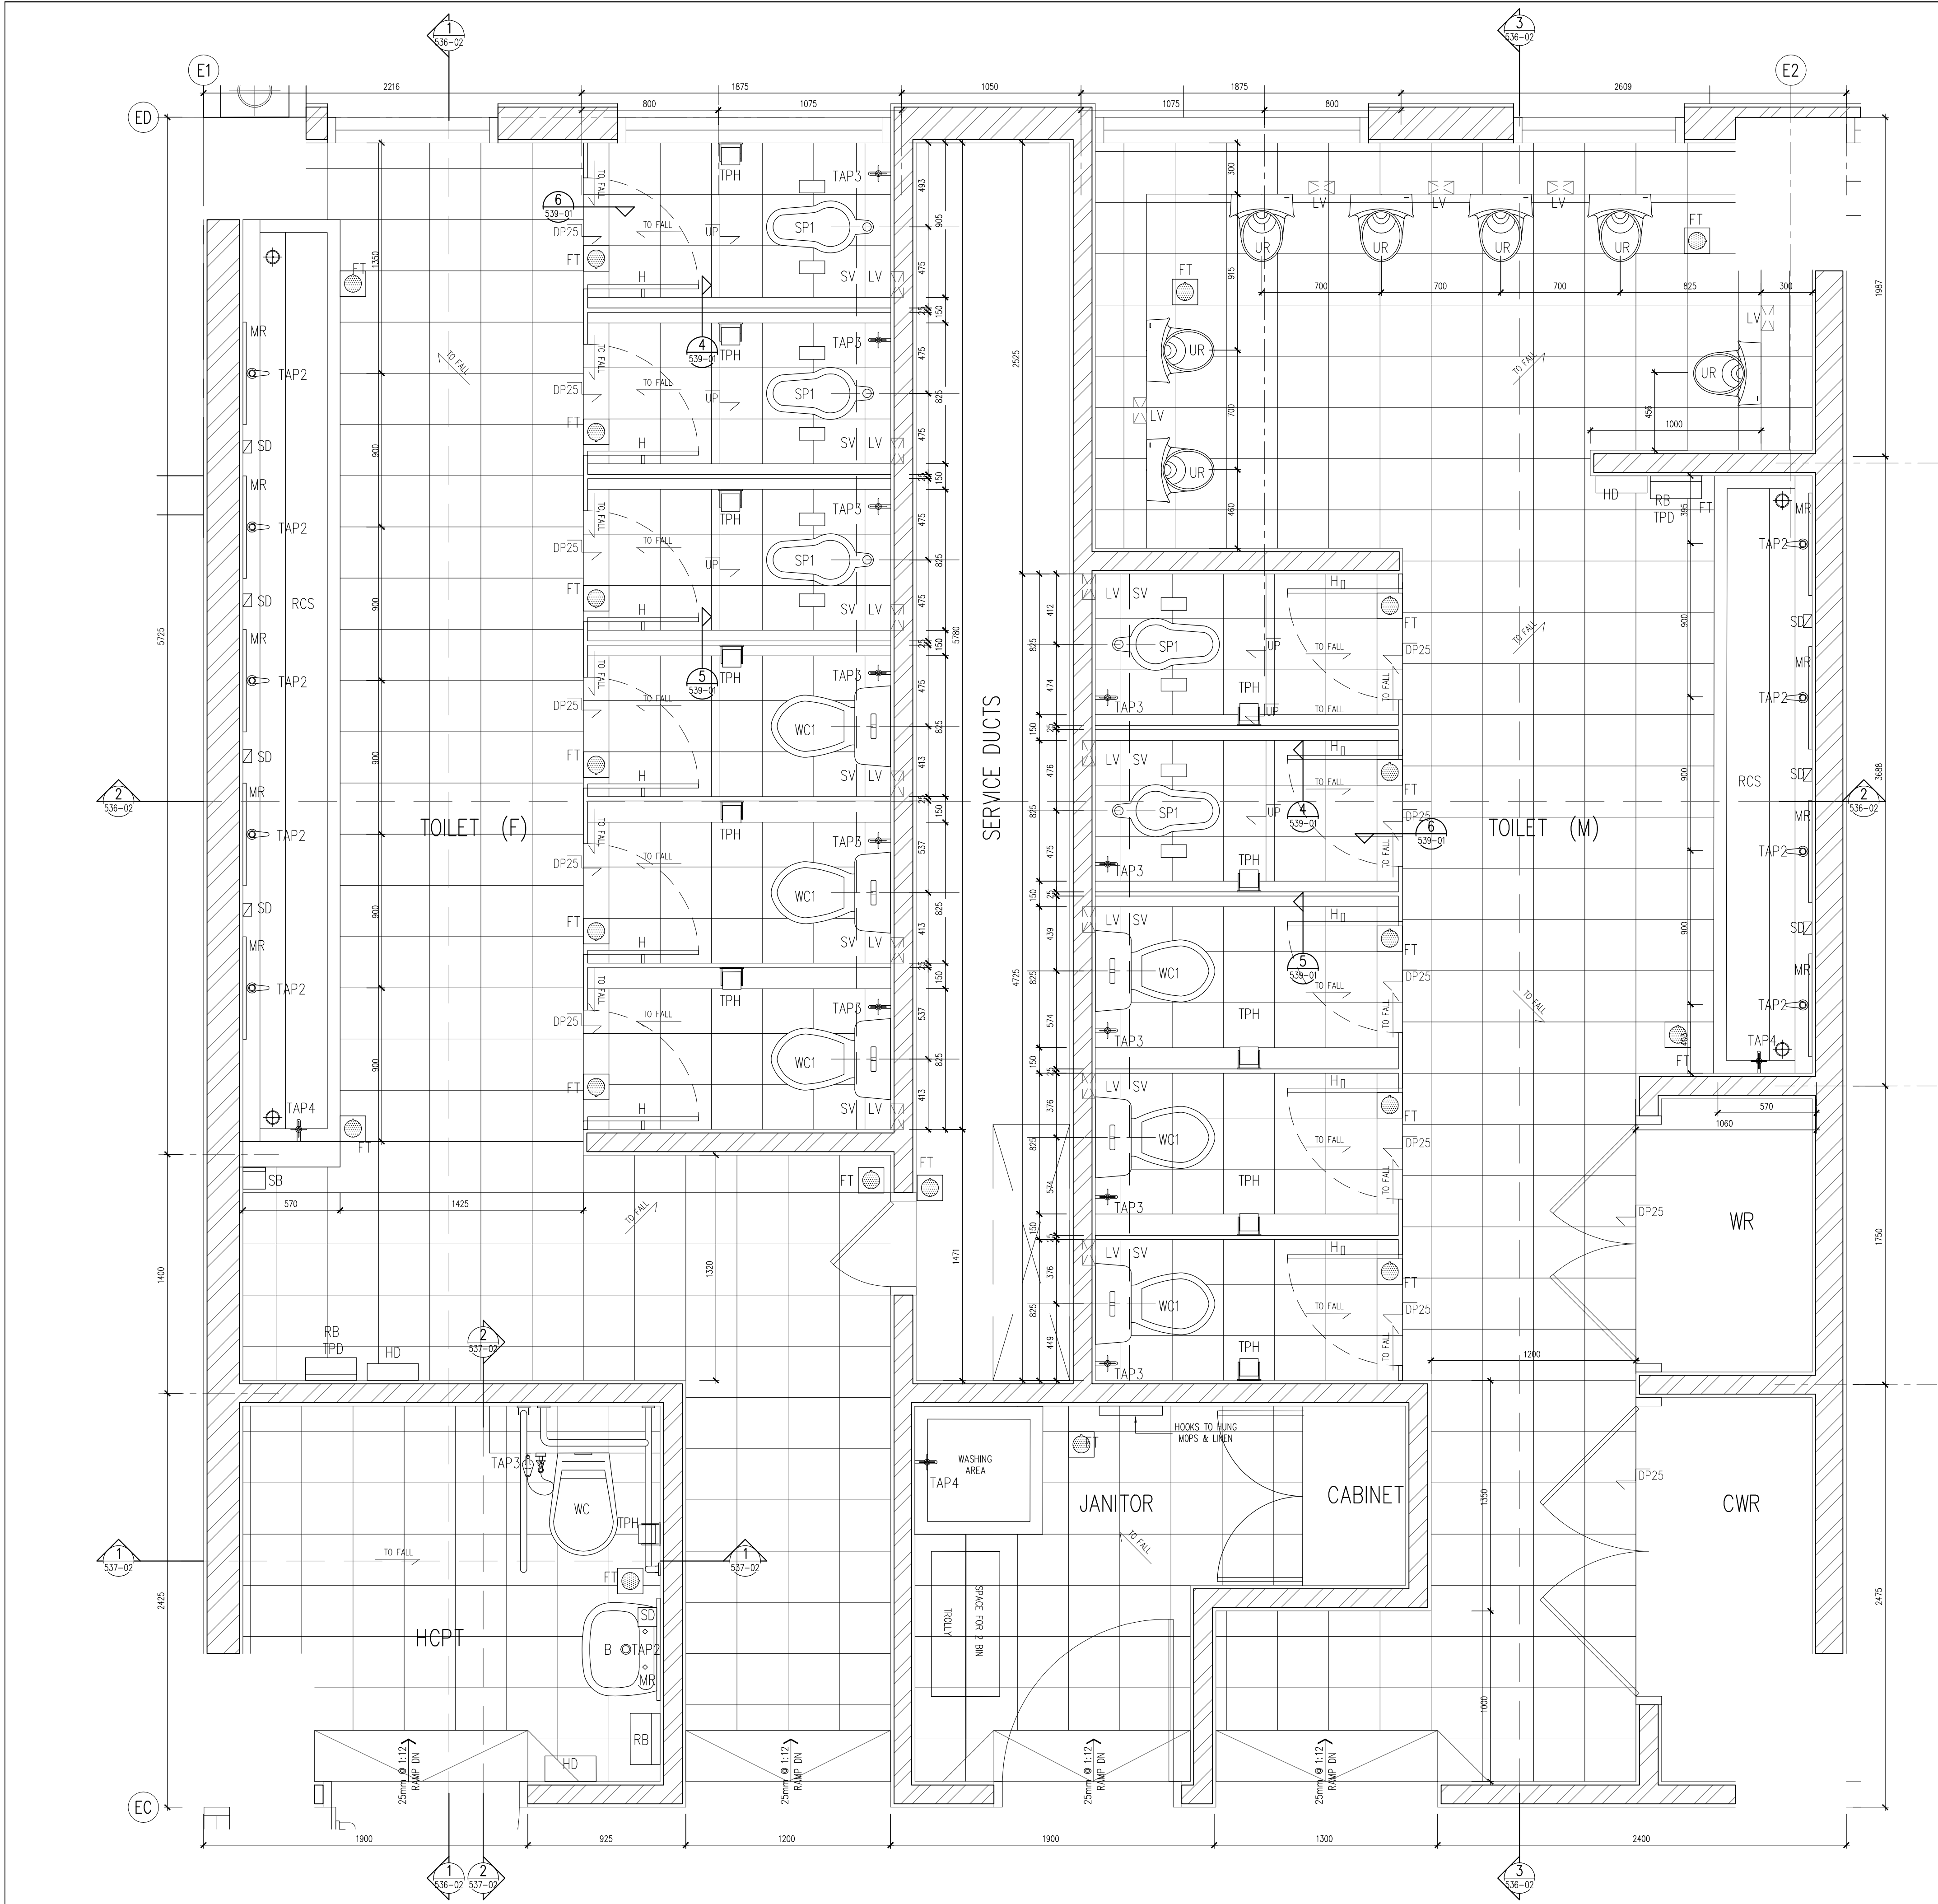

LEGEND :

FT	S.S. FLOOR TRAP
WB	WASH BASIN
MR	MIRROR
SD	SOAP DISPENSER
HD	HAND DRYER
RB	RECESS TRASH BIN
TPD	TOILET PAPER DISPENSER
WC	WATER CLOSET (FLUSH VALVE SYSTEM)
WC1	WATER CLOSET
SP	SQUATING WATER CLOSET (FLUSH VALVE SYSTEM)
SP1	SQUATING WATER CLOSET
TPH	TOILET PAPER HOLDER
UR	URINAL
AP	ACCESS PANEL
LV	LOUVRED VENTILATION
LK	LOCKER
BCH	BENCH WITH HOOKS
TAP1	NORMAL ON/OFF TAP
TAP2	PRESS DOWN BUTTON TAP
TAP3	WATER TAP WITH FLEXIBLE HOSE
TAP4	WATER TAP AT 450MM (H)
SS	SIDE CORNER SHELVE FOR SOAP
H	HOOK TO HAND CLOTHING
RCS	R.C COUNTER SINK
SB	SANITAC BIN
SH	SHOWER
HWP	HOT WATER POINT (FOR ALL SHOWER)
SV	SHELVE TO PUT BAG (FOR ALL TOILET CUBICLE)


NOTES:

- 1- ALL TOILET HAVE SHELVE INSIDE EACH TOILET CUBICAL TO PUT BAG
- 2- ALL FEMALE TOILET HAVE PLACE FOR SANITAC BIN
- 3- ALL WALL TILES UP TO CEILING HEIGHT

Hak Cipta Terpelihara. Tidak dibenarkan mencetak mana-mana bahagian ilustrasi dalam apa jua bentuk dan dengan apa cara pun samada secara elektronik, mencetak, mekanik, rakaman atau cara lain sebelum mendapat kebenaran bertulis dari NRY ARCHITECTS SDN. BHD.

REV.	DATE	DESCRIPTION	REMARK
A	23.06.2016	FIRST ISSUED FOR CONSTRUCTION DRAWING	FARID

KEY PLAN :

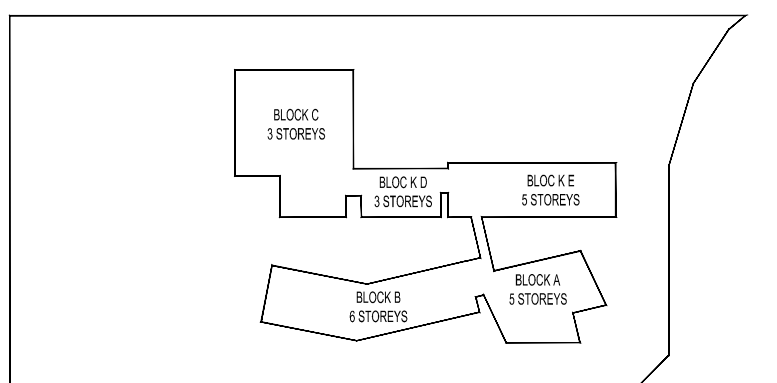

PROJECT TITLE :
CADANGAN MEMBINA SEBUAH KOLEJ UNIVERSITI SWASTA
DI ATAS PT 5828, PERSIARAN CASSIA BARAT 3, BATU KAWAN,
MK. 13, SEBERANG PERAI SELATAN YANG MENDANGUNI :

- BLOK A : - PUSAT PENTADBIRAN 5 TINGKAT
- BLOK B : - PERPUSTAKAAN DAN BLIK KULIAH 8 TINGKAT
- BLOK C : - BANGUNAN AKADEMIK DAN DEWAN SERBAGUNA 3 TINGKAT DENGAN PODIUM
- BLOK D : - DEWAN KULIAH DAN KAFETERIA 3 TINGKAT
- BLOK E : - BANGUNAN AKADEMIK 5 TINGKAT
- BLOK F : - 2 UNIT PONDOK PENGAWAL DAN 1 UNIT TNB 11 KV STESEN SUIS UTAMA

UNTUK : TETUAN KDU COLLEGE (PG) SDN. BHD

LAND OWNER & BUILDING OWNER :

NAMA : DR. CHONG BENG KEOK
JAWATAN : KETUA PEGAWAI EKSEKUTIF (CEO)
NO IC : 610612-02-5048
ALAMAT : KDU COLLEGE (PG) SDN BHD
32, JALAN ANSON,
10400, GEORGE TOWN, PULAU PINANG
NO. TEL : 604-2386368

KITCHEN SPECIALIST : DISHES SDN BHD
NO. 21-1, JALAN SEMENYIH SENTRAL 1,
SEMEYIN, 43500, SELANGOR
TEL : +603-872-71201
email : info@dishes.com.my
webmail : www.dishes.com.my

QS CONSULTANT :
UNITECH QS CONSULTANCY SDN. BHD.
12A-A, MENARA NORTHAM
55, JALAN SULTAN AHMAD SHAH,
10050 PENANG

M&E CONSULTANT :
PERUNDING P.L.A.
Consulting Mechanical & Electrical Engineers.
8-01, WISMA PANTAI, TEL NO. : (604) 3337990
JALAN WISMA PANTAI, FAX NO. : (604) 3317337
12200, BUTTERWORTH, PENANG. E-MAIL : project@pla-group.com

C&S CONSULTANT :
PERUNDING KELANA
CIVIL & STRUCTURAL ENGINEERS
Level 12, Unit 12(D), Wisma Boon Siew,
No.1, Penang Road, 10000 Penang.
Tel: 2622628, Fax: 2641618
(Company No. AS0232772-W)

DESIGN ARCHITECT :
ARCHITECTURE GROUP - STUDIO A
CPG CONSULTANTS PTE LTD
238B, THOMSON ROAD, #12-00 TOWER B
NOVENA SQUARE, SINGAPORE 307695
CONSULTANT'S TEL: +65 6357 4468 FAX: +65 6357 4469

ARCHITECT :
BH YEOW ARCHITECT (SP/Y61)
15TH FLOOR, BANGUNAN AMMETLIFE
NO.1, JALAN LUMUT, 50400 KUALA LUMPUR
TEL: (03) 4043-1346 FAX: (03) 4043-1349
EMAIL: ybhw@nrasb.com.my

Ar. YEW BU HWA
ARKITEK PROFESIONAL
No. Pendaftaran: LAM/A/Y61
Saya mengesahkan bahawa pelan-pelan yang dihantar adalah mengikut Undang-Undang Kaji Bangunan
Seragam 1986 dan Undang-Undang Kaji Bangunan Seragam (Revisi) 2007 (JUSK2007) dan
pindaan-pindaan serta garis-garis dan polisi-polisi Majlis Perbandaran Seberang Perai.
Saya mengesahkan bahawa kerja-kerja pembinaan akan dijalankan dengan sempurna.
Saya mengesahkan dan mengaku bahawa pelan-pelan bangunan adalah sebagai design pelan kebenaran
merancang yang dilakukan dan akan mematuhi undang-undang serta syarat-syarat jabatan Teknikal.

CONSTRUCTION DRAWING

DRAWING TITLE :

BLOCK E
MALE & FEMALE TOILET
1ST - 4TH FLOOR PLAN

SCALE :	CAD NO. :
AS SHOWN	553_CA-536-01_A.dwg
DRAWN BY :	CHECK BY :
IBRAHIM	Mr. Farid
DATE :	JUNE 2016
PROJECT NO. :	STATUS :
55314	CA
BLOCK :	DWG. NO. :
TD	536
DWG. NO. :	DWG. NO. :
01	01
REVISION :	REVISION :
A	A

1ST - 4TH FLOOR
SCALE = 1 : 20