


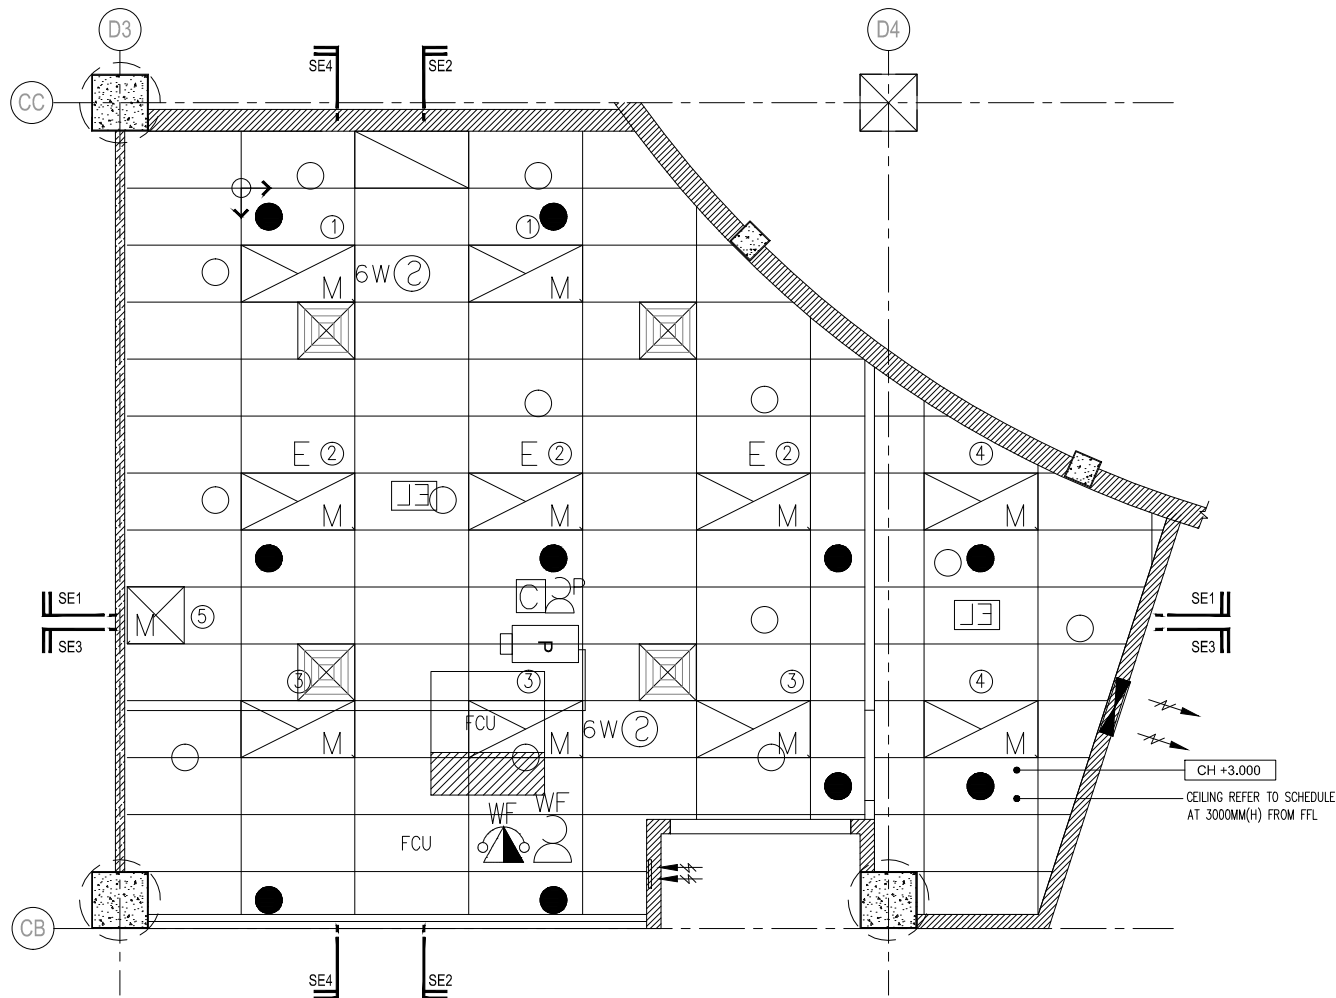

LEGEND: PUBLIC ADDRESS SYSTEM.

SYMBOL	DESCRIPTION(S)	QTY
	6W RECESSED CEILING MOUNTED SPEAKER C/W MATCHING TRANSFORMER (TAP AT 1.5W)	2

LEGEND : ACMV INSTALLATION

SYMBOL	DESCRIPTION(S)	QTY
	SUPPLY AIR GRILLE (600 x 600 UNLESS OTHERWISE STATED) 4 WAY TYPE C/W OPPOSED BLADE VOLUME CONTROL DAMPER (UNLESS OTHERWISE STATED)	4
	1200mm X 600mm RETURN AIR GRILLE	1
	FAN COIL UNIT (FCU)	1
	PLENUM BOX	1
	A/C CONTROL MODULE	1
	600MM X 600MM FRESH AIR GRILLE C/W VOLUME CONTROL DAMPER	1
	WALL MOUNTED EXHAUST FAN C/W FIXED LOUVER & INSERT SCREEN	1

CONSTRUCTION DRAWING

PROJECT TITLE :
CADANGAN MEMBINA SEBUAH KOLEJ UNIVERSITI SWASTA
DI ATAS PT 5828, PERSIARAN CASSIA BARAT 3, BATU KAWAN,
MK. 13, SEBERANG PERAI SELATAN YANG MENGANDUNGI :
BLOK A – PUSAT PENTADBIRAN 5 TINGKAT
BLOK B – PERPUSTAKAAN DAN BILIK KULIAH 6 TINGKAT
BLOK C – BANGUNAN AKADEMIK DAN DEWAN SERBAGUNA
B3 TINGKAT DENGAN PODIUM
BLOK D – DEWAN KULIAH DAN KAFETERIA 3 TINGKAT
BLOK E – BANGUNAN AKADEMIK 5 TINGKAT
2 UNIT PONDOK PENGAWAL DAN
1 UNIT TNB 11 KV STESEN SUIS UTAMA
UNTUK: TETUAN KDU COLLEGE (PG) SDN. BHD

LAND OWNER & BUILDING OWNER SIGNATURE :
.....
NAME : DR.CHONG BENG KEOK
CHIEF EXECUTIVE OFFICER (CEO)
IC. NO : 610612-02-5048
ALAMAT :KDU COLLEGE (PG) SDN.BHD.
32, JALAN ANSON, 10400 GEORGE TOWN,
PULAU PINANG.
TEL. NO : 604-2386368

DESIGN ARCHITECT :
CPG ARCHITECTURE GROUP - STUDIO A
CPG CONSULTANTS PTE LTD
1 Gateway Drive #23-01
Westgate Tower, Singapore 608531
Tel : +63574888 ; fax: +63574188
BH YEOW ARCHITECT
15TH FLOOR, BANGUNAN AMMETLIFE,
NO.1, JLN. LUMUT, 50400 KUALA LUMPUR.
TEL: (30)-4046-1346
FAX: (03) 4043-1349
EMAIL: ybhwa@nrasb.com.my
ARCHITECT SIGNATURE :
.....

C&S CONSULTANT :
PK PERUNDING KELANA
CIVIL & STRUCTURAL ENGINEERS
Level 12, Unit 12(D), Wisma Boon Siew,
No.1, Penang Road, 10000 Penang.
Tel: 2622628, Fax: 2641618
(Company No. A50232772-W)
M&E CONSULTANT :
PERUNDING P.L.A.
Consulting Mechanical & Electrical Engineers.
8-01, WISMA PANTAI,
JALAN WISMA PANTAI,
12200 BUTTERWORTH, PENANG.
TEL. NO. : (604) 3337990
FAX NO. : (604) 3317337
E-MAIL : project@pla-group.com

QS CONSULTANT :
UNI UNITECH QS CONSULTANCY SDN. BHD.
NO. 21-1, JALAN SEMENYIH SENTRAL 1,
12A-A, MENARA NORTHAM,
55, JALAN SULTAN AHMAD SHAH,
10050 PENANG
KITCHEN SPECIALIST :
DISHES DISHES SDN BHD
NO. 21-1, JALAN SEMENYIH SENTRAL 1,
SEMENYIH SENTRAL,
SEMENYIH, 43500 SELANGOR
TEL : +603-872-71201
email : info@dishes.com.my
webmail : www.dishes.com.my

DRAWING TITLE :				
BLOCK D_1ST FLOOR INTERNATIONAL STUDENT CENTRE REFLECTED CEILING PLAN				
DATE : 18.03.16	SCALE : 1:75	CHECK BY : EJ/EDM		
PROJECT NO. : 55314		STATUS : CA	BLOCK : D	DWG. NO : N002
			REVISION : A	