


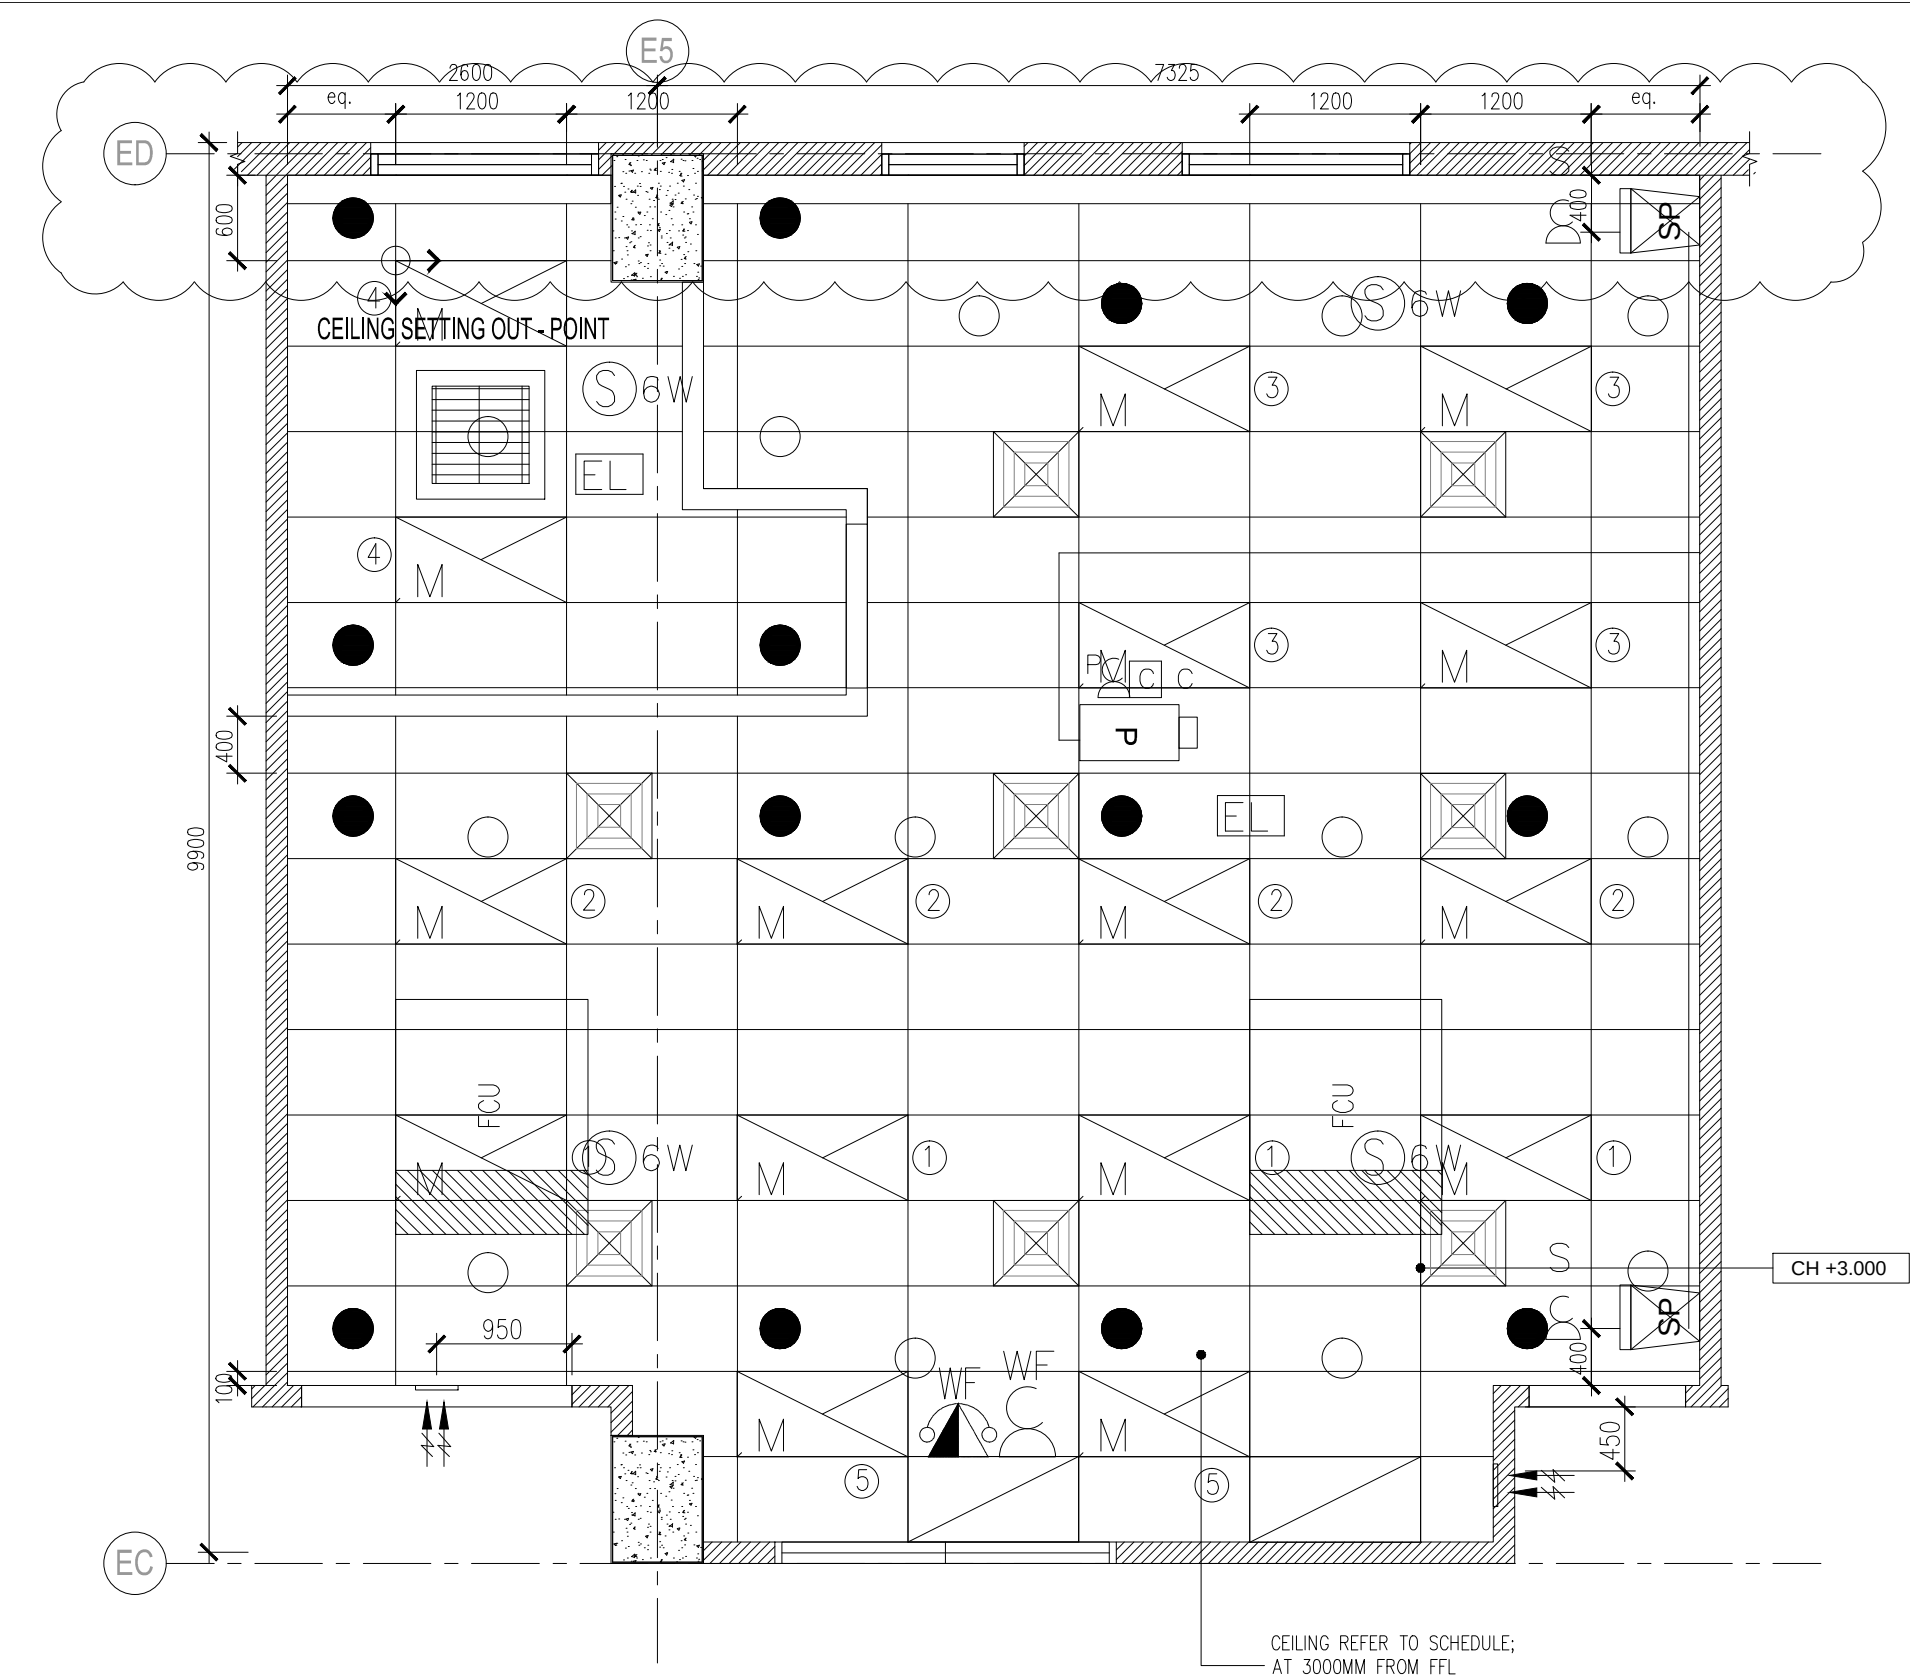

LEGEND : ELECTRICAL INSTALLATION

SYMBOL	DESCRIPTION(S)	QTY
	2 X 28W RECESSED TYPE T5 FLUO. FTG. C/W MI OR REFLECTOR & ALUMINIUM CROSS BLADE. (ELECTRONIC BALLAST)	16
	10A 1/2/3 GANG TWO WAY LIGHTING SWITCH AT 1450mm AFFL.	2
	10A 1/2/3 GANG ONE WAY LIGHTING SWITCH AT 1450mm AFFL.	1
	13A TWIN SWITCH SOCKET OUTLET AT 300mm AFFL. (UNLESS OTHERWISE STATED).	2
	13A TWIN SWITCH SOCKET OUTLET (RUN IN FLOOR TRUNKING) MOUNTED AT TABLE / LOW HEIGHT PARTITION. (ACTUAL POSITION TO BE DETERMINE ON SITE).	16
	13A SWITCH SOCKET OUTLET AT 900mm AFFL. (UNLESS OTHERWISE STATED).	4
	32A TPN ISOLATOR PT. AT 900mm AFFL. (UNLESS OTHERWISE STATED).	2
	13A SWITCH SOCKET OUTLET AT ABOVE CEILING LEVEL FOR WIFI SYSTEM	1
	13A SWITCH SOCKET OUTLET AT BELOW CEILING LEVEL FOR SPEAKER	2
	13A SWITCH SOCKET OUTLET AT ABOVE CEILING LEVEL FOR PROJECTOR	1
	20A 1 GANG ONE WAY DOUBLE POLE SWITCH (FOR PROJECTOR & SPEAKER AND A/C)	2
	UNDER FLOOR JUNCTION BOX (250mm X 250mm X 56mm) FOR POWER, TELEPHONE & DATA CAST IN FLOOR SLAB. - DATA - 150mm X 25mm X 3.2mm UNDERFLOOR UPVC TRUNKING/CONDUIT. (CAST IN FLOOR SLAB) - POWER - 150mm X 25mm X 3.2 mm UNDERFLOOR UPVC TRUNKING/CONDUIT. (CAST IN FLOOR SLAB)	AS SHOWN
	150mm X 25mm METAL TRUNKING DROPPER	AS SHOWN
	25MM PVC CONDUIT FOR AUDIO AND VISUAL C/W INSPECTION BOX (BY ELECTRICAL CONTRACTOR)	AS SHOWN

LEGEND : FIRE INSTALLATION

SYMBOL	DESCRIPTION(S)	QTY
	PENDENT SPRINKLER (155°F/68°C TEMPERATURE RATING).	14
	UPRIGHT SPRINKLER (155°F/68°C TEMPERATURE RATING).	13
	EMERGENCY LIGHT. (SUPPLY & INSTALL BY ELECTRICAL CONTRACTOR)	2
	8W KELUAR SIGN C/W SELF CONTAINED BACK UP BATTERY (3 HR.) & CHARGER.	2
	9 KGS ABC DRY POWDER PORTABLE FIRE EXTINGUISHER.	1

LEGEND : TELEPHONE INSTALLATION

SYMBOL	DESCRIPTION(S)	QTY
	COMPUTER/DATA (1G) UTP PT. C/W SOCKET OUTLET USING CAT. 6 CABLE IN UPVC CONDUIT/CONCEALED	3
	WIFI POINT C/W SOCKET OUTLET AT CEILING LEVEL USING CAT 6 CABLE IN UPVC CONDUIT/CONCEALED.	1

LEGEND : PUBLIC ADDRESS SYSTEM.

SYMBOL	DESCRIPTION(S)	QTY
	6W RECESSED CEILING MOUNTED SPEAKER C/W MATCHING TRANSFORMER (TAP AT 1.5W)	4

LEGEND : ACMV INSTALLATION

SYMBOL	DESCRIPTION(S)	QTY
	SUPPLY AIR GRILLE (600 x 600 UNLESS OTHERWISE STATED).	8
	4 WAY TYPE C/W OPPOSED BLADE VOLUME CONTROL DAMPER (UNLESS OTHERWISE STATED)	2
	1200mm X 600mm RETURN AIR GRILLE	2
	FAN COIL UNIT (FCU)	2
	PLENUM BOX	2
	300MM X 300MM FRESH AIR GRILLE C/W VOLUME CONTROL DAMPER	2
	CHILLED WATER CEILING CASSETTE	1
	A/C CONTROL MODULE	3

LEGEND : AUDIO/VISUAL SYSTEM

SYMBOL	DESCRIPTION(S)	QTY
	HDMI & AUDIO INPUT PANEL	1
	REMOTE MIXER (MIC INPUT & VOLUME CONTROL)	1
	3 WAYS ACTIVE SPEAKER (TO AUDIO & VISUAL DETAILS)	2
	3000 ANSI LUMENS WXGA 3L PROJECTOR (TO AUDIO & VISUAL DETAILS) -PROJECTOR SUPPORT SUPPLIED BY MAIN CONTRACTOR.	1

CONSTRUCTION DRAWING

PROJECT TITLE :
CADANGAN MEMBINA SEBUAH KOLEJ UNIVERSITI SWASTA
DI ATAS PT 5828, PERSIARAN CASSIA BARAT 3, BATU KAWAN,
MK. 13, SEBERANG PERAI SELATAN YANG MENGANDUNGI :
BLOK A – PUSAT PENTADBIRAN 5 TINGKAT
BLOK B – PERPUSTAKAAN DAN BILIK KULIAH 6 TINGKAT
BLOK C – BANGUNAN AKADEMIK DAN DEWAN SERBAGUNA
B3 TINGKAT DENGAN PODIUM
BLOK D – DEWAN KULIAH DAN KAFETERIA 3 TINGKAT
BLOK E – BANGUNAN AKADEMIK 5 TINGKAT
2 UNIT PONDOK PENGAWAL DAN
1 UNIT TNB 11 KV STESEN SUIS UTAMA
UNTUK: TETUAN KDU COLLEGE (PG) SDN. BHD

LAND OWNER & BUILDING OWNER SIGNATURE :

NAME : DR.CHONG BENG KEOK
CHIEF EXECUTIVE OFFICER (CEO)
IC. NO : 610612-02-5048
ALAMAT :KDU COLLEGE (PG) SDN.BHD.
32, JALAN ANSON, 10400 GEORGE TOWN,
PULAU PINANG.
TEL. NO : 604-2386368

DESIGN ARCHITECT :
ARCHITECTURE GROUP - STUDIO A
CPG CONSULTANTS PTE LTD
1 Gateway Drive #23-01
Westgate Tower, Singapore 608531
Tel : +63574888 ; fax: +63574188
ARCHITECT SIGNATURE :
BH YEW ARCHITECT
15TH FLOOR, BANGUNAN AMMETLIFE,
NO.1, JLN. LUMUT, 50400 KUALA LUMPUR.
TEL: (30)-4046-1346
FAX: (03) 4043-1349
EMAIL: ybhwa@nrasb.com.my

C&S CONSULTANT :
PERUNDING KELANA
CIVIL & STRUCTURAL ENGINEERS
Level 12, Unit 12(D), Wisma Boon Siew,
No.1, Penang Road, 10000 Penang.
Tel: 2622628, Fax: 2641618
(Company No. A50232772-W)
M&E CONSULTANT :
PERUNDING P.L.A.
Consulting Mechanical & Electrical Engineers.
8-01, WISMA PANTAI,
JALAN WISMA PANTAI,
12200 BUTTERWORTH, PENANG.
TEL. NO. : (604) 3337990
FAX NO. : (604) 3317337
E-MAIL : project@pla-group.com

QS CONSULTANT :
UNITECH QS CONSULTANCY SDN. BHD.
12A-A, MENARA NORTHAM,
55, JALAN SULTAN AHMAD SHAH,
10050 PENANG
KITCHEN SPECIALIST :
DISHES SDN BHD
NO. 21-1, JALAN SEMENYIH SENTRAL 1,
SEMENYIH SENTRAL,
SEMENYIH, 43500 SELANGOR
TEL. : +603-872-71201
email : info@dishes.com.my
webmail : www.dishes.com.my

DRAWING TITLE :
BLOCK E_GROUND FLOOR
PROJECT LAB_MECHANICAL
REFLECTED CEILING PLAN
DATE : 11.03.16
SCALE : 1:50
CHECK BY : EJ/EDM
PROJECT NO. : 55314
STATUS : CA
BLOCK : E
DWG. NO : 0102
REVISION : A