


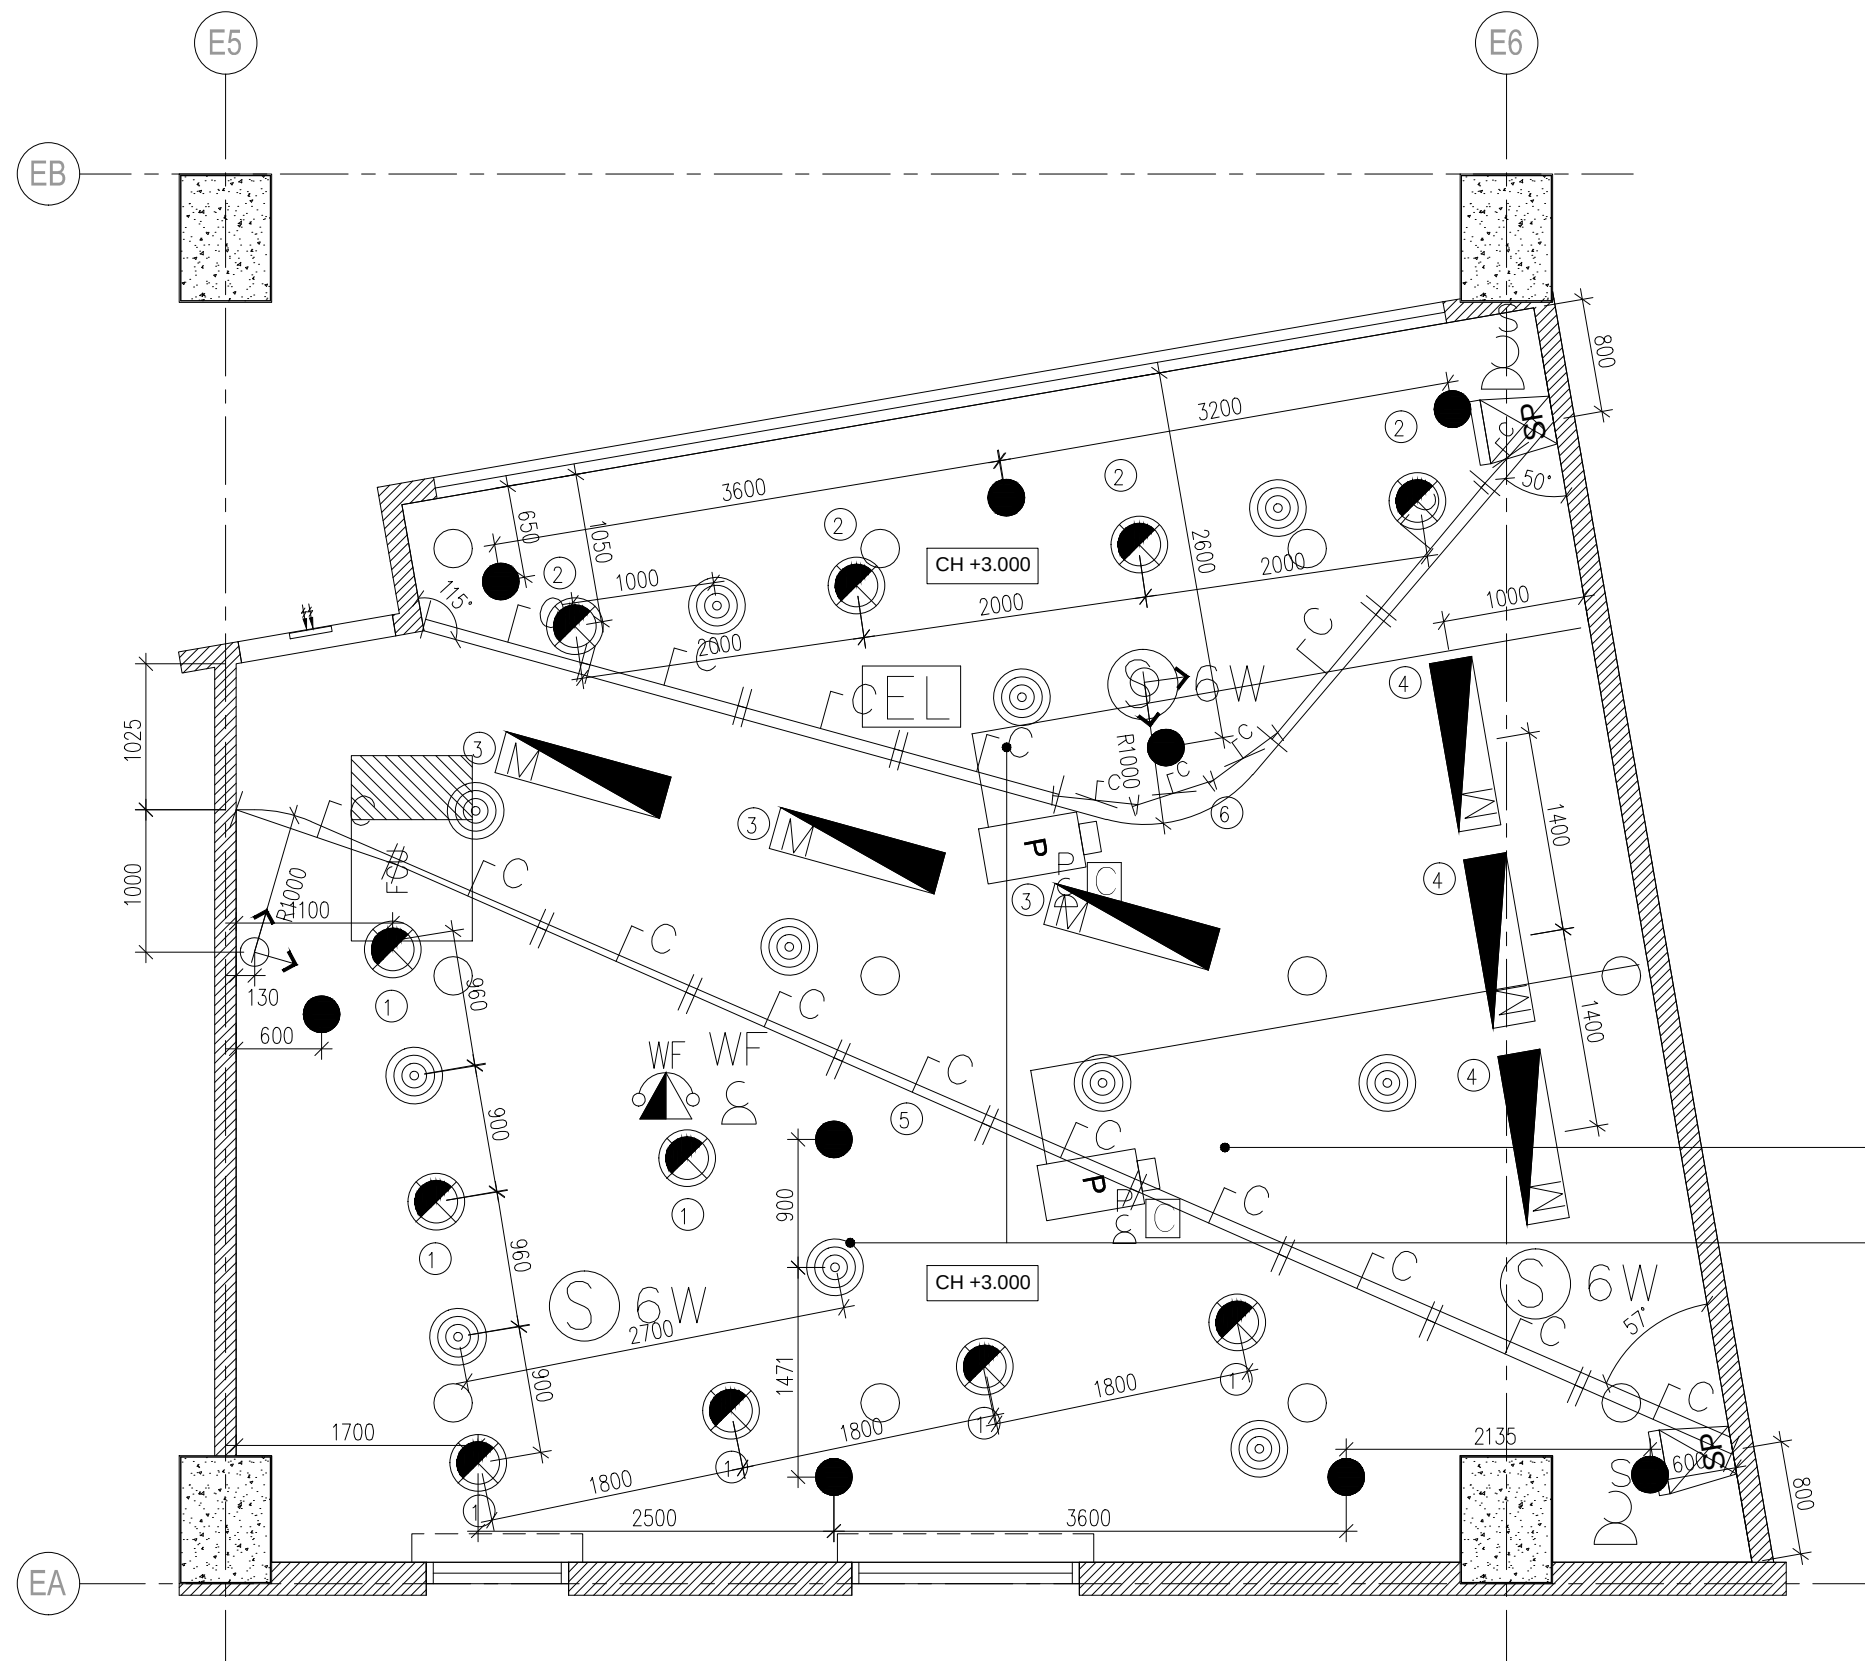

LEGEND : ACMV INSTALLATION		
SYMBOL	DESCRIPTION(S)	QTY
FCU	FAN COIL UNIT (FCU)	1
●	SUPPLY AIR GRILLE (450MMØ UNLESS OTHERWISE STATED) ROUND TYPE C/W OPPOSED BLADE VOLUME CONTROL DAMPER (UNLESS OTHERWISE STATED)	11
AC	A/C CONTROL MODULE	1
⌞	300MM X 300MM FRESH AIR GRILLE C/W VOLUME CONTROL DAMPER	1

LEGEND : FIRE INSTALLATION		
SYMBOL	DESCRIPTION(S)	QTY
●	PENDENT SPRINKLER (155°F/68°C TEMPERATURE RATING).	9
○	UPRIGHT SPRINKLER (155°F/68°C TEMPERATURE RATING).	11
□	EMERGENCY LIGHT. (SUPPLY & INSTALL BY ELECTRICAL CONTRACTOR)	1

LEGEND : PUBLIC ADDRESS SYSTEM.		
SYMBOL	DESCRIPTION(S)	QTY
⊙GW	6W RECESSED CEILING MOUNTED SPEAKER C/W MATCHING TRANSFORMER (TAP AT 1.5W)	3

LEGEND : TELEPHONE INSTALLATION		
SYMBOL	DESCRIPTION(S)	QTY
□	COMPUTER/DATA (1G) UTILITY POINT (C/W SOCKET OUTLET USING CAT. 6 CABLE IN UPVC CONDUIT/CONCEALED	26
⌞	WIFI POINT C/W SOCKET OUTLET AT CEILING LEVEL USING CAT 6 CABLE IN UPVC CONDUIT/CONCEALED.	1

EXPOSED SLAB WITH SKIMCOAT AND PAINT FINISH;
SERVICES ABOVE CEILING LEVEL PAINTED BLACK

CEILING REFER TO SCHEDULE;
AT 3000MM(H) FROM FFL;

CONSTRUCTION DRAWING

PROJECT TITLE :
CADANGAN MEMBINA SEBUAH KOLEJ UNIVERSITI SWASTA
DI ATAS PT 5828, PERSIARAN CASSIA BARAT 3, BATU KAWAN,
MK. 13, SEBERANG PERAI SELATAN YANG MENDUNGKI :
BLOK A – PUSAT PENTADBIRAN 5 TINGKAT
BLOK B – PERPUSTAKAAN DAN BILIK KULIAH 6 TINGKAT
BLOK C – BANGUNAN AKADEMIK DAN DEWAN SERBAGUNA
B3 TINGKAT DENGAN PODIUM
BLOK D – DEWAN KULIAH DAN KAFETERIA 3 TINGKAT
BLOK E – BANGUNAN AKADEMIK 5 TINGKAT
2 UNIT PONDOK PENGAWAL DAN
1 UNIT TNB 11 KV STESEN SUIS UTAMA
UNTUK: TETUAN KDU COLLEGE (PG) SDN. BHD

LAND OWNER & BUILDING OWNER SIGNATURE :
.....
NAME : DR.CHONG BENG KEOK
CHIEF EXECUTIVE OFFICER (CEO)
IC. NO : 610612-02-5048
ALAMAT :KDU COLLEGE (PG) SDN.BHD.
32, JALAN ANSON, 10400 GEORGE TOWN,
PULAU PINANG.
TEL. NO : 604-2386368

DESIGN ARCHITECT :
ARCHITECTURE GROUP - STUDIO A
CPG CONSULTANTS PTE LTD
1 Gateway Drive #23-01
Westgate Tower, Singapore 608531
Tel : +63574888 ; fax: +63574188
BH YEW ARCHITECT
15TH FLOOR, BANGUNAN AMMELIFE,
NO.1, JLN. LUMUT, 50400 KUALA LUMPUR.
TEL: (30)-4046-1346
FAX: (03) 4043-1349
EMAIL: ybhwa@nrasb.com.my

ARCHITECT SIGNATURE :
.....

C&S CONSULTANT :
PERUNDING KELANA
CIVIL & STRUCTURAL ENGINEERS
Level 12, Unit 12(D), Wisma Boon Siew,
No.1, Penang Road, 10000 Penang.
Tel: 2622628, Fax: 2641618
(Company No. A50232772-W)
M&E CONSULTANT :
PERUNDING P.L.A.
Consulting Mechanical & Electrical Engineers.
8-01, WISMA PANTAI,
JALAN WISMA PANTAI,
12200 BUTTERWORTH, PENANG.
TEL. NO. : (604) 3337990
FAX NO. : (604) 3317337
E-MAIL : project@pla-group.com

QS CONSULTANT :
UNITECH QS CONSULTANCY SDN. BHD.
12A-A, MENARA NORTHAM,
55, JALAN SULTAN AHMAD SHAH,
10050 PENANG
KITCHEN SPECIALIST :
DISHES SDN BHD
NO. 21-1, JALAN SEMENYIH SENTRAL 1,
SEMENYIH SENTRAL,
SEMENYIH, 43500 SELANGOR
TEL. : +603-872-71201
email : info@dishes.com.my
webmail : www.dishes.com.my

DRAWING TITLE :
BLOCK E_1ST FLOOR
GAMES LAB
REFLECTED CEILING PLAN
DATE : 22.03.16
SCALE : 1:50
CHECK BY : EJ/EDM
PROJECT NO. : 55314
STATUS : CA
BLOCK : E
DWG. NO : Q002
REVISION : A