


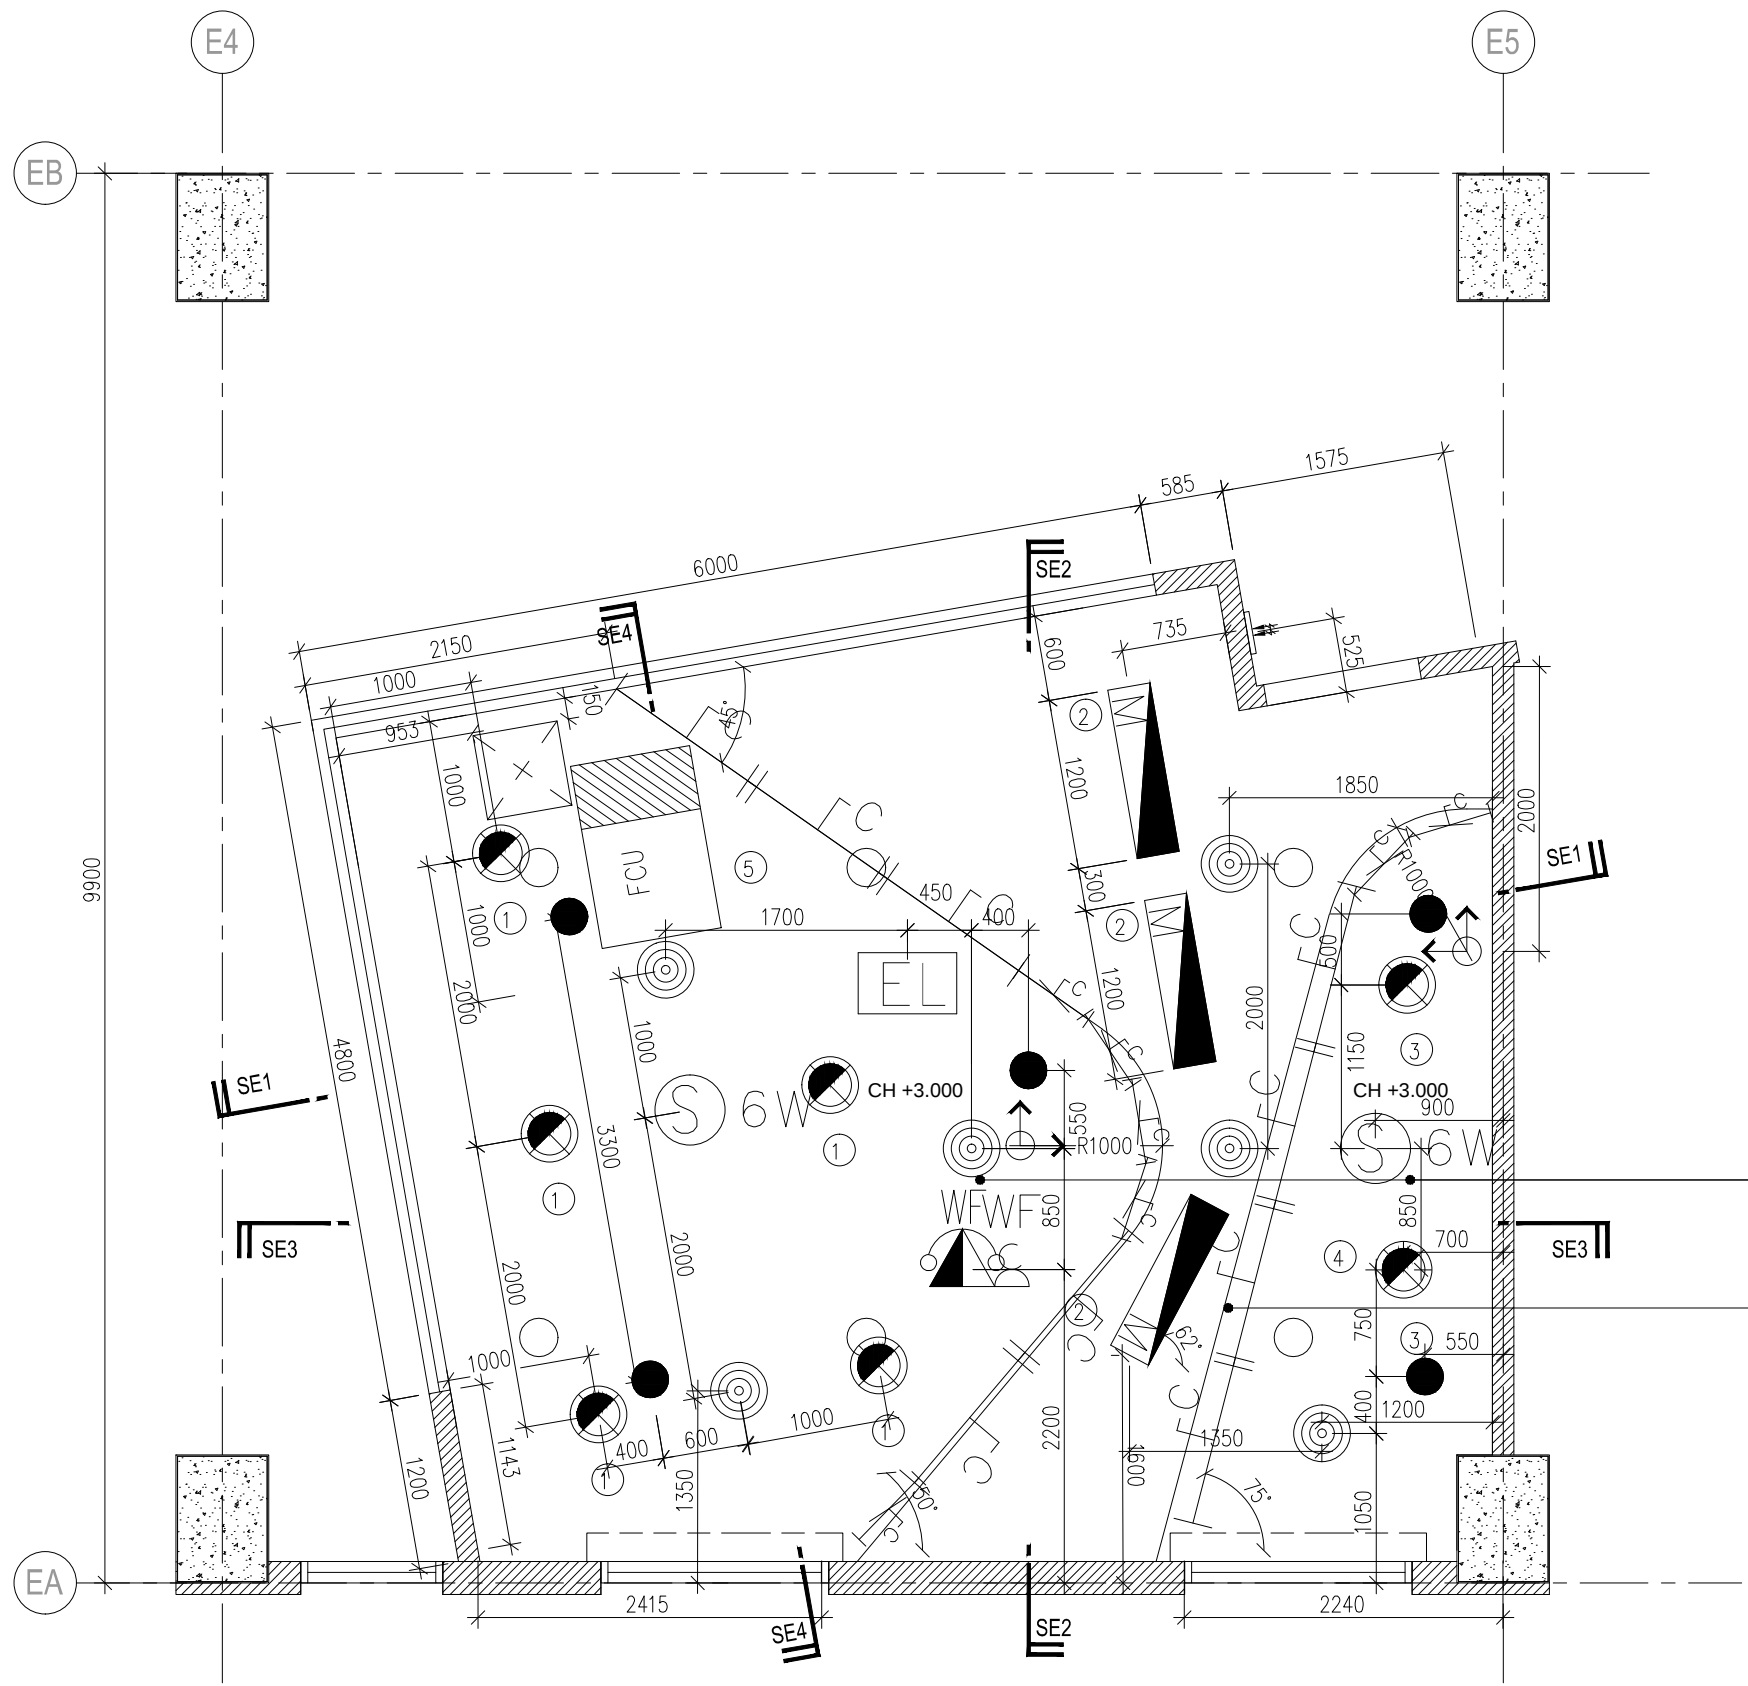

LEGEND : ACMV INSTALLATION		
SYMBOL	DESCRIPTION(S)	QTY
[FCU]	FAN COIL UNIT (FCU)	1
[RSD]	ROUND TYPE SUPPLY AIR DIFFUSER (600MM# UNLESS OTHERWISE STATED)	6
[AC]	A/C CONTROL MODULE	1
[X]	600MM x 600MM CEILING OPENING	1
[FAG]	300MM X 300MM FRESH AIR GRILLE C/W VOLUME CONTROL DAMPER	1

LEGEND : FIRE INSTALLATION		
SYMBOL	DESCRIPTION(S)	QTY
[PSP]	PENDENT SPRINKLER (155T/68°C TEMPERATURE RATING).	5
[USP]	UPRIGHT SPRINKLER (155T/68°C TEMPERATURE RATING).	6
[EL]	EMERGENCY LIGHT. (SUPPLY & INSTALL BY ELECTRICAL CONTRACTOR)	1

LEGEND: PUBLIC ADDRESS SYSTEM.		
SYMBOL	DESCRIPTION(S)	QTY
[6W]	6W RECESSED CEILING MOUNTED SPEAKER C/W MATCHING TRANSFORMER (TAP AT 1.5W)	2

LEGEND : TELEPHONE INSTALLATION		
SYMBOL	DESCRIPTION(S)	QTY
[C/D]	COMPUTER/DATA (16) UTP PT. C/W SOCKET OUTLET USING CAT. 6 CABLE IN UPVC CONDUIT/CONCEALED.	6
[WFI]	WFI POINT C/W SOCKET OUTLET AT CEILING LEVEL USING CAT 6 CABLE IN UPVC CONDUIT/CONCEALED.	1

CEILING REFER TO SCHEDULE;
AT 3000MM(H) FROM FFL

EXPOSED SLAB WITH SKIM COAT AND PAINT FINISH;
SERVICES ABOVE CEILING LEVEL PAINTED BLACK

CONSTRUCTION DRAWING

PROJECT TITLE :
CADANGAN MEMBINA SEBUAH KOLEJ UNIVERSITI SWASTA
DI ATAS PT 5828, PERSIARAN CASSIA BARAT 3, BATU KAWAN,
MK. 13, SEBERANG PERAI SELATAN YANG MENGANDUNGI :
BLOK A – PUSAT PENTADBIRAN 5 TINGKAT
BLOK B – PERPUSTAKAAN DAN BILIK KULIAH 6 TINGKAT
BLOK C – BANGUNAN AKADEMIK DAN DEWAN SERBAGUNA
B3 TINGKAT DENGAN PODIUM
BLOK D – DEWAN KULIAH DAN KAFETERIA 3 TINGKAT
BLOK E – BANGUNAN AKADEMIK 5 TINGKAT
2 UNIT PONDOK PENGAWAL DAN
1 UNIT TNB 11 KV STESEN SUIS UTAMA
UNTUK: TETUAN KDU COLLEGE (PG) SDN. BHD

LAND OWNER & BUILDING OWNER SIGNATURE :

NAME : DR.CHONG BENG KEOK
CHIEF EXECUTIVE OFFICER (CEO)
IC. NO : 610612-02-5048
ALAMAT :KDU COLLEGE (PG) SDN.BHD.
32, JALAN ANSON, 10400 GEORGE TOWN,
PULAU PINANG.
TEL. NO : 604-2386368

DESIGN ARCHITECT :
ARCHITECTURE GROUP - STUDIO A
CPG CONSULTANTS PTE LTD
1 Gateway Drive #23-01
Westgate Tower, Singapore 608531
Tel : +63574888 ; fax: +63574188
ARCHITECT SIGNATURE :
BH YEW ARCHITECT
15TH FLOOR, BANGUNAN AMMELIFE,
NO.1, JLN. LUMUT, 50400 KUALA LUMPUR.
TEL: (30)-4046-1346
FAX: (03) 4043-1349
EMAIL: ybhwa@nrasb.com.my

C&S CONSULTANT :
PERUNDING KELANA
CIVIL & STRUCTURAL ENGINEERS
Level 12, Unit 12(D), Wisma Boon Siew,
No.1, Penang Road, 10000 Penang.
Tel: 2622628, Fax: 2641618
(Company No. A50232772-W)
M&E CONSULTANT :
PERUNDING P.L.A.
Consulting Mechanical & Electrical Engineers.
8-01, WISMA PANTAI,
JALAN WISMA PANTAI,
12200 BUTTERWORTH, PENANG.
TEL. NO. : (604) 3337990
FAX NO. : (604) 3317337
E-MAIL : project@pla-group.com

QS CONSULTANT :
UNITECH QS CONSULTANCY SDN. BHD.
12A-A, MENARA NORTHAM,
55, JALAN SULTAN AHMAD SHAH,
10050 PENANG
KITCHEN SPECIALIST :
DISHES SDN BHD
NO. 21-1, JALAN SEMENYIH SENTRAL 1,
SEMENYIH SENTRAL,
SEMENYIH, 43500 SELANGOR
TEL. : +603-872-71201
email : info@dishes.com.my
webmail : www.dishes.com.my

DRAWING TITLE :
BLOCK E_1ST FLOOR
GAMES LOUNGE
REFLECTED CEILING PLAN

DATE :	SCALE :	CHECK BY :			
22.03.16	1:50	EJ/EDM			
PROJECT NO. :		STATUS	BLOCK	DWG. NO	REVISION
55314		CA	E	Q102	A