


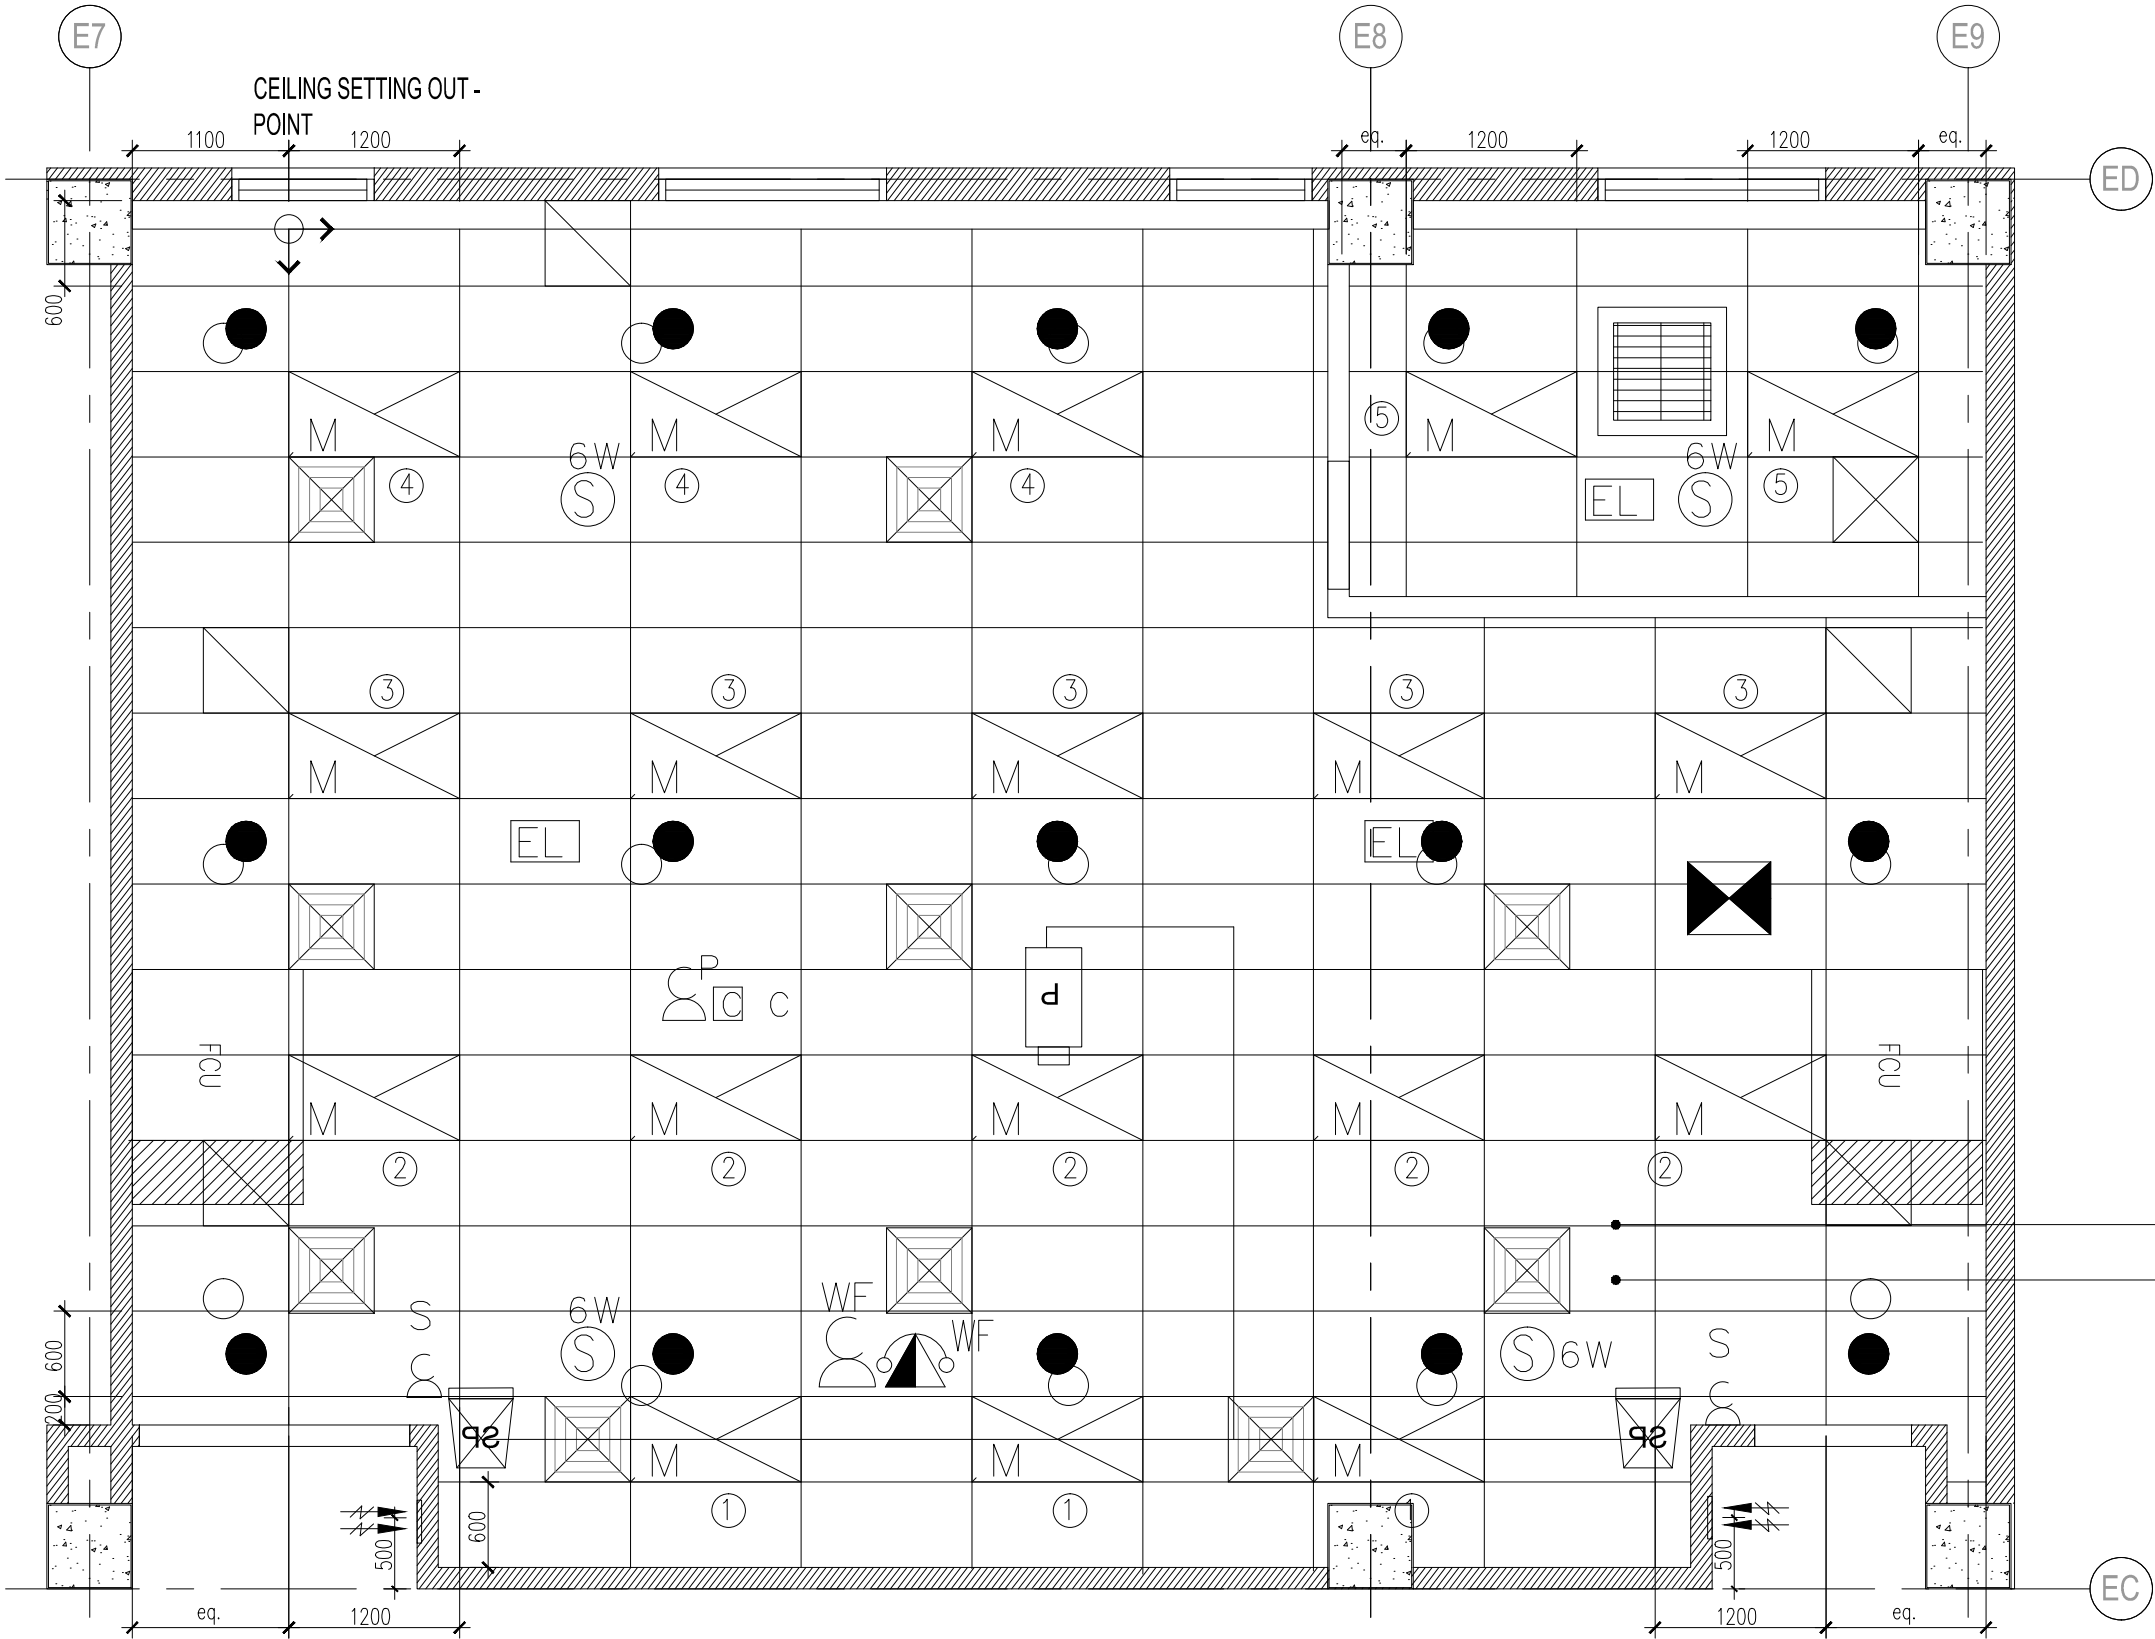

LEGEND : TELEPHONE INSTALLATION		
SYMBOL	DESCRIPTION(S)	QTY
	COMPUTER/DATA (C) UTP PT. C/W SOCKET OUTLET USING CAT. 6 CABLE IN UPVC CONDUIT/CONCEALED	3
	WFI POINT C/W SOCKET OUTLET AT CEILING LEVEL USING CAT. 6 CABLE IN UPVC CONDUIT/CONCEALED	1

LEGEND : FIRE INSTALLATION		
SYMBOL	DESCRIPTION(S)	QTY
	PENDENT SPRINKLER (155T/68C TEMPERATURE RATING)	15
	UPRIGHT SPRINKLER (155T/68C TEMPERATURE RATING)	15
	EMERGENCY LIGHT. (SUPPLY & INSTALL BY ELECTRICAL CONTRACTOR)	3
	'KELUAR' SIGN	2
	9 KGS ABC DRY POWDER PORTABLE FIRE EXTINGUISHER	2

LEGEND : PUBLIC ADDRESS SYSTEM		
SYMBOL	DESCRIPTION(S)	QTY
	6W RECESSED CEILING MOUNTED SPEAKER C/W MATCHING TRANSFORMER (TAP AT 1.5W)	4

CONSTRUCTION DRAWING

DRAWING TITLE :
BLOCK E_3RD FLOOR
SCULPTURING/WOODWORK/
STEELWORK WORKSHOP
REFLECTED CEILING PLAN

DATE : 09.05.16	SCALE : 1:50	CHECK BY : EJ/EDM			
PROJECT NO. : 55314		STATUS : CA	BLOCK : E	DWG. NO : T402	REVISION : A

PROJECT TITLE :
CADANGAN MEMBINA SEBUAH KOLEJ UNIVERSITI SWASTA
DI ATAS PT 5828, PERSIARAN CASSIA BARAT 3, BATU KAWAN,
MK. 13, SEBERANG PERAI SELATAN YANG MENDUNGUNI :
BLOK A - PUSAT PENTADBIRAN 5 TINGKAT
BLOK B - PERPUSTAKAAN DAN BILIK KULIAH 6 TINGKAT
BLOK C - BANGUNAN AKADEMIK DAN DEWAN SERBAGUNA
B3 TINGKAT DENGAN PODIUM
BLOK D - DEWAN KULIAH DAN KAFETERIA 3 TINGKAT
BLOK E - BANGUNAN AKADEMIK 5 TINGKAT
2 UNIT PONDOK PENGAWAL DAN
1 UNIT TNB 11 KV STESEN SUIS UTAMA
UNTUK: TETUAN KDU COLLEGE (PG) SDN. BHD

LAND OWNER & BUILDING OWNER SIGNATURE :
.....
NAME : DR.CHONG BENG KEOK
CHIEF EXECUTIVE OFFICER (CEO)
IC. NO : 610612-02-5048
ALAMAT :KDU COLLEGE (PG) SDN.BHD.
32, JALAN ANSON, 10400 GEORGE TOWN,
PULAU PINANG.
TEL. NO : 604-2386368

DESIGN ARCHITECT :
ARCHITECTURE GROUP - STUDIO A
CPG CONSULTANTS PTE LTD
1 Gateway Drive #23-01
Westgate Tower, Singapore 608531
Tel : +63574888 ; fax: +63574188
BH YEW ARCHITECT
15TH FLOOR, BANGUNAN AMMELIFE,
NO.1, JLN. LUMUT, 50400 KUALA LUMPUR.
TEL: (30)-4046-1346
FAX: (03) 4043-1349
EMAIL: ybhwa@nrasb.com.my
ARCHITECT SIGNATURE :
.....

C&S CONSULTANT :
PERUNDING KELANA
CIVIL & STRUCTURAL ENGINEERS
Level 12, Unit 12(D), Wisma Boon Siew,
No.1, Penang Road, 10000 Penang.
Tel: 2622628, Fax: 2641618
(Company No. A50232772-W)
M&E CONSULTANT :
PERUNDING P.L.A.
Consulting Mechanical & Electrical Engineers.
8-01, WISMA PANTAI,
JALAN WISMA PANTAI,
12200 BUTTERWORTH, PENANG.
TEL. NO. : (604) 3337990
FAX NO. : (604) 3317337
E-MAIL : project@pla-group.com

QS CONSULTANT :
UNITECH
UNITECH QS CONSULTANCY SDN. BHD.
NO. 21-1, JALAN SEMENYIH SENTRAL 1,
SEMENYIH, 43500 SELANGOR
TEL. : +603-872-71201
email : info@dishes.com.my
webmail : www.dishes.com.my
KITCHEN SPECIALIST :
DISHES
DISHES SDN BHD
NO. 21-1, JALAN SEMENYIH SENTRAL 1,
SEMENYIH SENTRAL,
SEMENYIH, 43500 SELANGOR
TEL. : +603-872-71201
email : info@dishes.com.my
webmail : www.dishes.com.my