


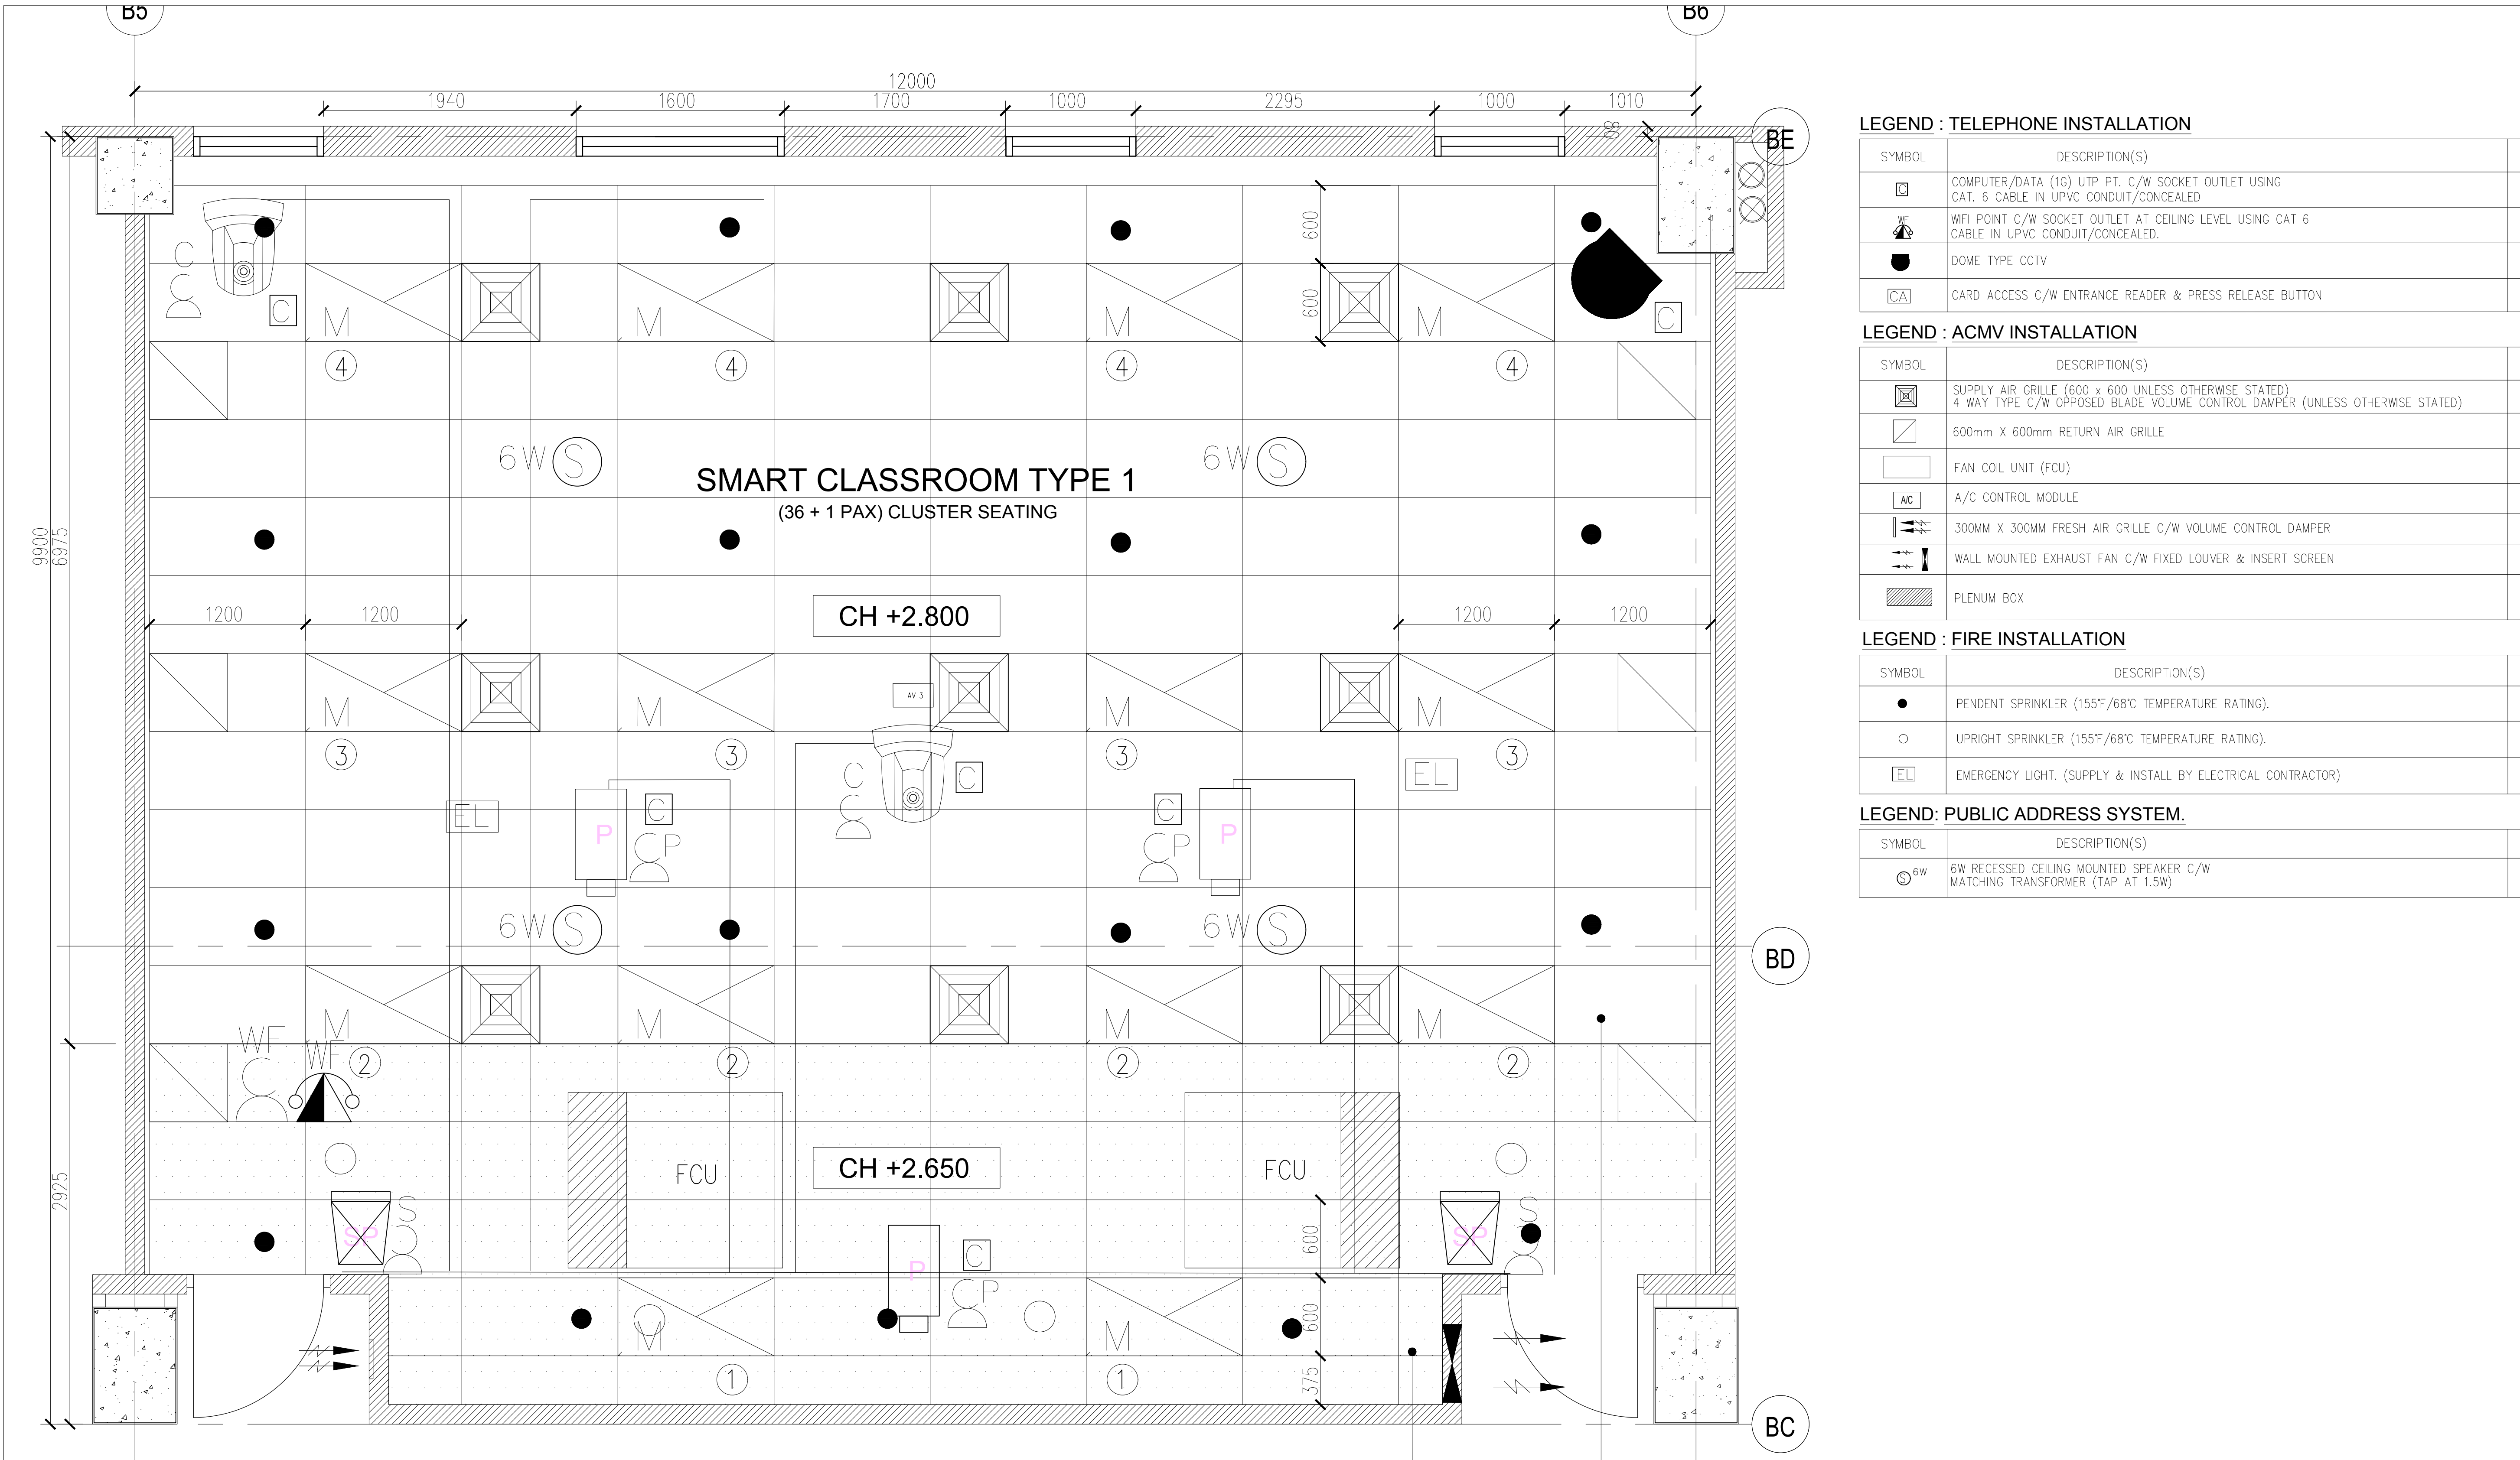

LEGEND : TELEPHONE INSTALLATION

SYMBOL	DESCRIPTION(S)
	COMPUTER/DATA (1G) UTP PT. C/W SOCKET OUTLET USING CAT. 6 CABLE IN UPVC CONDUIT/CONCEALED
	WIFI POINT C/W SOCKET OUTLET AT CEILING LEVEL USING CAT 6 CABLE IN UPVC CONDUIT/CONCEALED.
	DOME TYPE CCTV
	CARD ACCESS C/W ENTRANCE READER & PRESS RELEASE BUTTON

LEGEND : ACMV INSTALLATION

SYMBOL	DESCRIPTION(S)
	SUPPLY AIR GRILLE (600 x 600 UNLESS OTHERWISE STATED) 4 WAY TYPE C/W OPPOSED BLADE VOLUME CONTROL DAMPER (UNLESS OTHERWISE STATED)
	600mm X 600mm RETURN AIR GRILLE
	FAN COIL UNIT (FCU)
	A/C CONTROL MODULE
	300MM X 300MM FRESH AIR GRILLE C/W VOLUME CONTROL DAMPER
	WALL MOUNTED EXHAUST FAN C/W FIXED LOUVER & INSERT SCREEN
	PLENUM BOX

LEGEND : FIRE INSTALLATION

 
SYMBOL	DESCRIPTION(S)
	PENDENT SPRINKLER (155°F/68°C TEMPERATURE RATING).
	UPRIGHT SPRINKLER (155°F/68°C TEMPERATURE RATING).
	EMERGENCY LIGHT. (SUPPLY & INSTALL BY ELECTRICAL CONTRACTOR)

LEGEND: PUBLIC ADDRESS SYSTEM.

SYMBOL	DESCRIPTION(S)
	6W RECESSED CEILING MOUNTED SPEAKER C/W MATCHING TRANSFORMER (TAP AT 1.5W)

TENDER DRAWING

DRAWING TITLE :					
BLOCK B_3RD FLOOR SMART CLASSROOM TYPE 1 REFLECTED CEILING PLAN					
DATE :	SCALE :	CHECK BY :			
07.04.17	1:50	EJ/EDM			
PROJECT NO. :		STATUS	BLOCK	DWG. NO	REVISION
55314		CA	B	E202	—

PROJECT TITLE : CADANGAN MEMBINA SEBUAH KOLEJ UNIVERSITI SWASTA DI ATAS PT 5828, PERSIARAN CASSIA BARAT 3, BATU KAWAN, MK. 13, SEBERANG PERAI SELATAN YANG MENGANDUNG : BLOK A – PUSAT PENTADBIRAN 5 TINGKAT BLOK B – PERPUSTAKAAN DAN BILIK KULIAH 6 TINGKAT BLOK C – BANGUNAN AKADEMIK DAN DEWAN SERBAGUNA B3 TINGKAT DENGAN PODIUM BLOK D – DEWAN KULIAH DAN KAFETERIA 3 TINGKAT BLOK E – BANGUNAN AKADEMIK 5 TINGKAT 2 UNIT PONDOK PENGAWAL DAN 1 UNIT TNB 11 KV STESEN SUIS UTAMA UNTUK: TETUAN KDU COLLEGE (PG) SDN. BHD		LAND OWNER & BUILDING OWNER SIGNATURE : NAME : DR.CHONG BENG KEOK CHIEF EXECUTIVE OFFICER (CEO) IC. NO : 610612-02-5048 ALAMAT :KDU COLLEGE (PG) SDN.BHD. 32, JALAN ANSON, 10400 GEORGE TOWN, PULAU PINANG. TEL. NO : 604-2386368		DESIGN ARCHITECT :  ARCHITECTURE GROUP - STUDIO A CPG CONSULTANTS PTE LTD 1 Gateway Drive #23-01 Westgate Tower, Singapore 608531 Tel : +63574888 ; fax: +63574188		C&S CONSULTANT :  PERUNDING KELANA CIVIL & STRUCTURAL ENGINEERS Level 12, Unit 12(D), Wisma Boon Siew, No.1, Penang Road, 10000 Penang. Tel: 2622628, Fax: 2641618 (Company No. AS0232772-W)		QS CONSULTANT :  UNITECH QS CONSULTANCY SDN. BHD. 12A-A, MENARA NORTHAM, 55, JALAN SULTAN AHMAD SHAH, 10050 PENANG			
				 15TH FLOOR, BANGUNAN AMMETIPE, NO.1, JLN. LUMUT, 50400 KUALA LUMPUR. TEL: (30)-4046-1346 FAX: (03) 4043-1349 EMAIL: ybhwa@nrasb.com.my		ARCHITECT SIGNATURE :		M&E CONSULTANT :  Consulting Mechanical & Electrical Engineers. 8-01, WISMA PANTAI, JALAN WISMA PANTAI, 12200 BUTTERWORTH, PENANG. TEL. NO. : (604) 3337990 FAX NO. : (604) 3317337 E-MAIL : project@pla-group.com		KITCHEN SPECIALIST :  DISHES SDN BHD NO. 21-1, JALAN SEMENYIH SENTRAL 1, SEMENYIH SENTRAL, SEMENYIH, 43500 SELANGOR TEL : +603-872-71201 email : info@dishes.com.my webmail : www.dishes.com.my	