


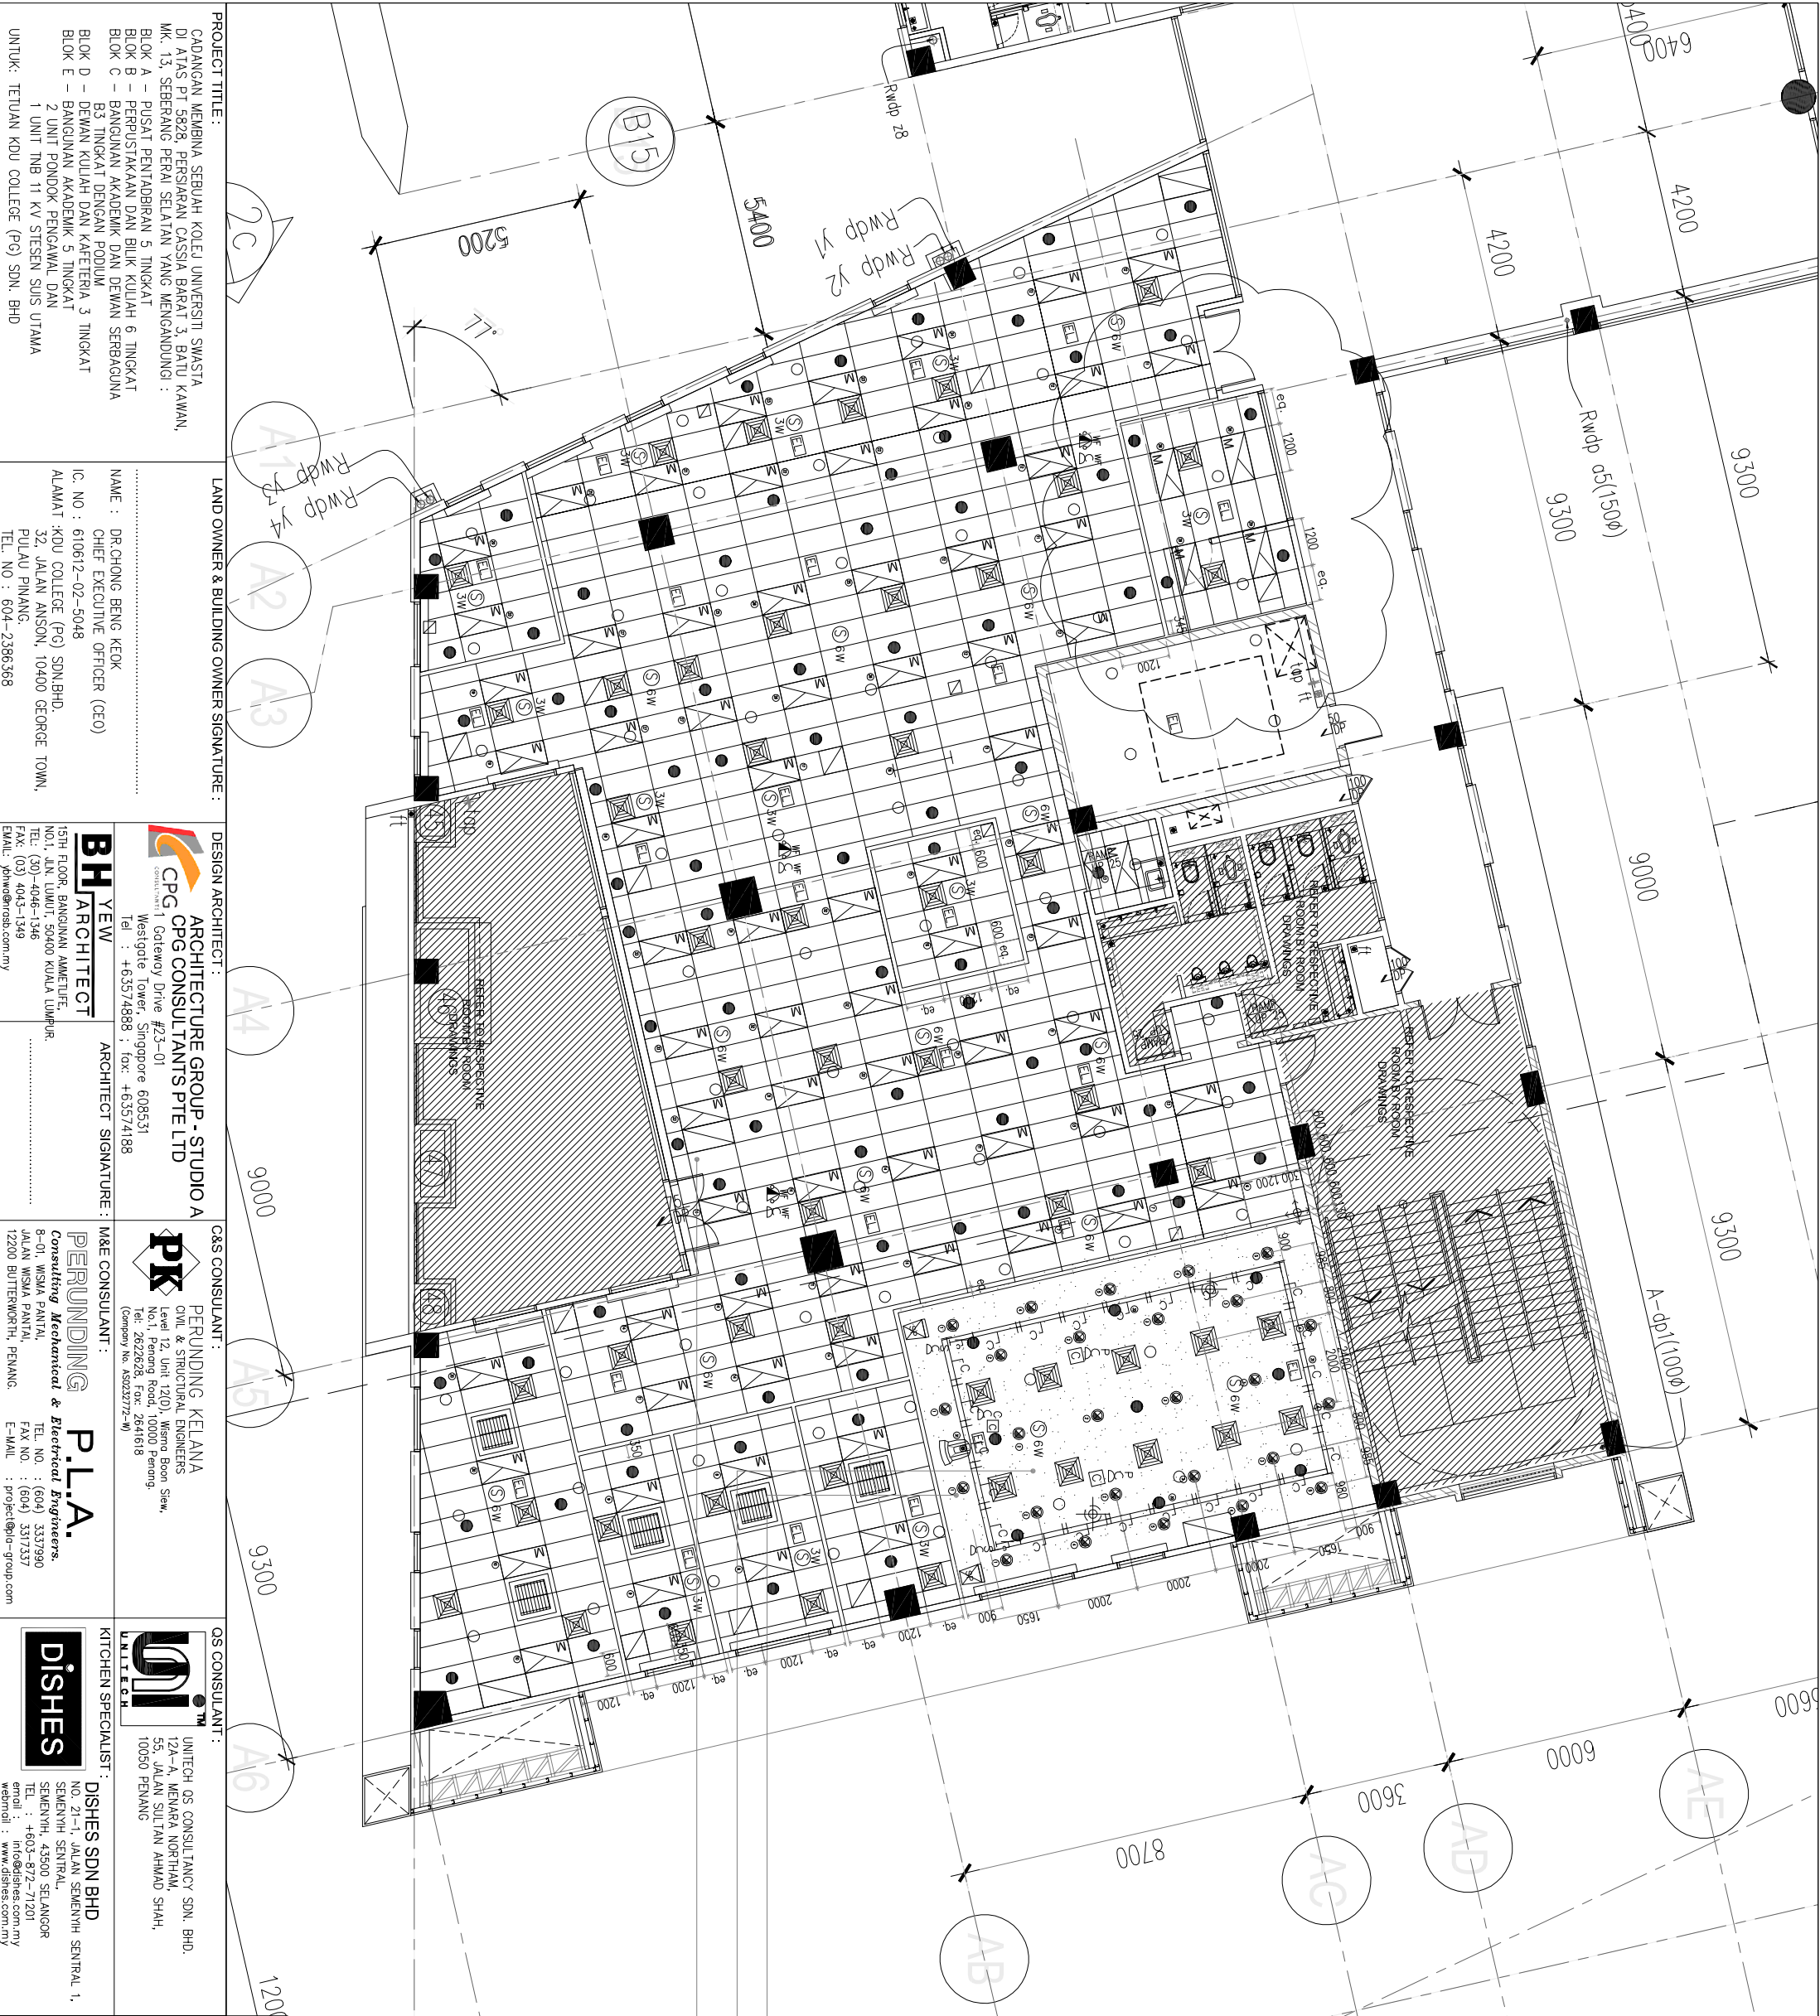

PROJECT TITLE :
CADANGAN MEMBINA SEBUAH KOLEJ UNIVERSITI SWASTA
DI ATAS PT 5828, PERSIARAN CASSIA, BARAT 3, BATU KAWAN,
MK. 13, SEBERANG PERAI SELATAN YANG MENGANDUNGI :
BLOK A – PUSAT PENYADIBAN 5 TINGKAT
BLOK B – PERUSTAKAAN DAN BILIK KULIAH 6 TINGKAT
BLOK C – BANGUNAN AKADEMIK DAN DEWAN SERBAGUNA
B3 TINGKAT DENGAN PODIUM
BLOK D – DEWAN KULIAH DAN KAFETERIA 3 TINGKAT
BLOK E – BANGUNAN AKADEMIK 5 TINGKAT
1 UNIT TNB 11 KV STESEN SUIS UTAMA
UNTUK: TETUAN KDU COLLEGE (PG) SDN. BHD

LAND OWNER & BUILDING OWNER SIGNATURE :

NAME : DR.CHONG BENG KEOK
CHIEF EXECUTIVE OFFICER (CEO)
IC NO : 610612-02-5048
ALAMAT :KDU COLLEGE (PG) SDN.BHD.
32, JALAN ANSON, 10400 GEORGE TOWN,
PULAU PINANG.
TEL NO : 604-2386368

DESIGN ARCHITECT :
**CPG**
ARCHITECTURE GROUP - STUDIO A
CPG CONSULTANTS PTE LTD
Westgate Tower, Singapore 608531
Tel : +65374888 ; fax: +63574188

C&S CONSULTANT :
**PERUNDING KELANA**
CIVIL & STRUCTURAL ENGINEERS
Level 12, Unit 1201, Wisma Boon Siew,
No.1, Penang Road, 10000 Penang.
Tel: 2622628, Fax: 2641618
(Company No. 85023772-M)

OS CONSULTANT :
**UNITECH**
UNITECH OS CONSULTANCY SDN. BHD.
12A-1A, MENARA MORTIM,
55, JALAN SULTAN AHMAD SHAH,
10050 PENANG

**BH YEW**
ARCHITECT
15TH FLOOR, BANGSIAN AMARTUTE,
NO.1, JLN LUMUT, 50400 KUALA LUMPUR.
TEL: (03)-4046-1346
FAX: (03) 4043-1349
EMAIL: jphw@bwh.com.my

ARCHITECT SIGNATURE :

NAME : DR.CHONG BENG KEOK
CHIEF EXECUTIVE OFFICER (CEO)
IC NO : 610612-02-5048
ALAMAT :KDU COLLEGE (PG) SDN.BHD.
32, JALAN ANSON, 10400 GEORGE TOWN,
PULAU PINANG.
TEL NO : 604-2386368

**DISHES**
KITCHEN SPECIALIST :
DISHES SDN BHD
NO 21-1, JALAN SEMENYIH SENTRAL 1,
SEMENYIH SENTRAL,
SEMENYIH, 43500 SELANGOR
TEL : +603-872-71201
email : info@dishes.com.my
websites : www.dishes.com.my

DATE : 23.03.17
SCALE : 1:100
PROJECT NO :
55314

STATUS :
CD

BLOCK :
A

DWG. NO :
A106

REVISION :
B

DRAWING TITLE :
BLOCK A-2ND FLOOR
ADMIN OFFICES
REFLECTED CEILING PLAN

CONSTRUCTION DRAWING

LEGEND : ACMV INSTALLATION	
SYMBOL	DESCRIPTION(S)
	AR HANDLING UNIT (AHU)
	SUPPLY AIR GRILLE
	RETURN AIR GRILLE
	DIFFUSER
	1200mm X 600mm RETURN AIR GRILLE
	600mm X 600mm RETURN AIR GRILLE
	300mm X 300mm RETURN AIR GRILLE
	CHILLED WATER CEILING CASSETTE
	150mm X 150mm EXHAUST AIR GRILLE
	FRESH AIR GRILLE
	EXHAUST AIR GRILLE
	DOOR ACTUATOR FOR SMOKE SPILL SYSTEM (SLIDING DOOR)
	SMOKE SPILL FAN

LEGEND: PUBLIC ADDRESS SYSTEM.	
SYMBOL	DESCRIPTION(S)
	RAI RECESSED CEILING MOUNTED SPEAKER C/W WATERSHIELD TRANSFORMER (1W AT 15W)
	RECESSED CEILING SPEAKER (2W)

LEGEND : TELEPHONE INSTALLATION	
SYMBOL	DESCRIPTION(S)
	COMPUTER/DATA (RJ) UTP RJ45 SOCKET OUTLET USING CAT. 6 CABLE IN UPVC CONDUIT/CONCEALED
	WIRED POINT C/W SOCKET OUTLET AT CEILING LEVEL USING CAT 6 CABLE IN UPVC CONDUIT/CONCEALED
	IP DOME CAMERA
	STANDALONE CCTV
	CARD ACCESS C/W ENTRANCE READER & PRESS RELEASE BUTTON
	ELECTRONIC LOCK C/W BREAKGLASS

LEGEND: AUDIO/VISUAL SYSTEM.	
SYMBOL	DESCRIPTION(S)
	HOME & AUDIO INPUT PANEL (RECESS INTO WALL)
	REMOTE WATER (MC) INPUT & VOLUME CONTROL – RECESS INTO WALL
	3 WMS ACTIVE SPEAKER (TO AUDIO & VISUAL DETAILS)
	3000 WMS ACTIVE SPEAKER (TO AUDIO & VISUAL DETAILS)
	PROJECTOR SUPPORT SUPPLIED BY MAIN CONTRACTOR
	FIXED CAMERA TYPE

CEILING REFER TO SCHEDULE AT 2800MM(H) FROM FTL
CEILING REFER TO SCHEDULE AT 3000MM(H) FROM FTL
CEILING REFER TO SCHEDULE AT 3000MM(H) FROM FTL
CEILING REFER TO SCHEDULE AT 3000MM(H) FROM FTL