


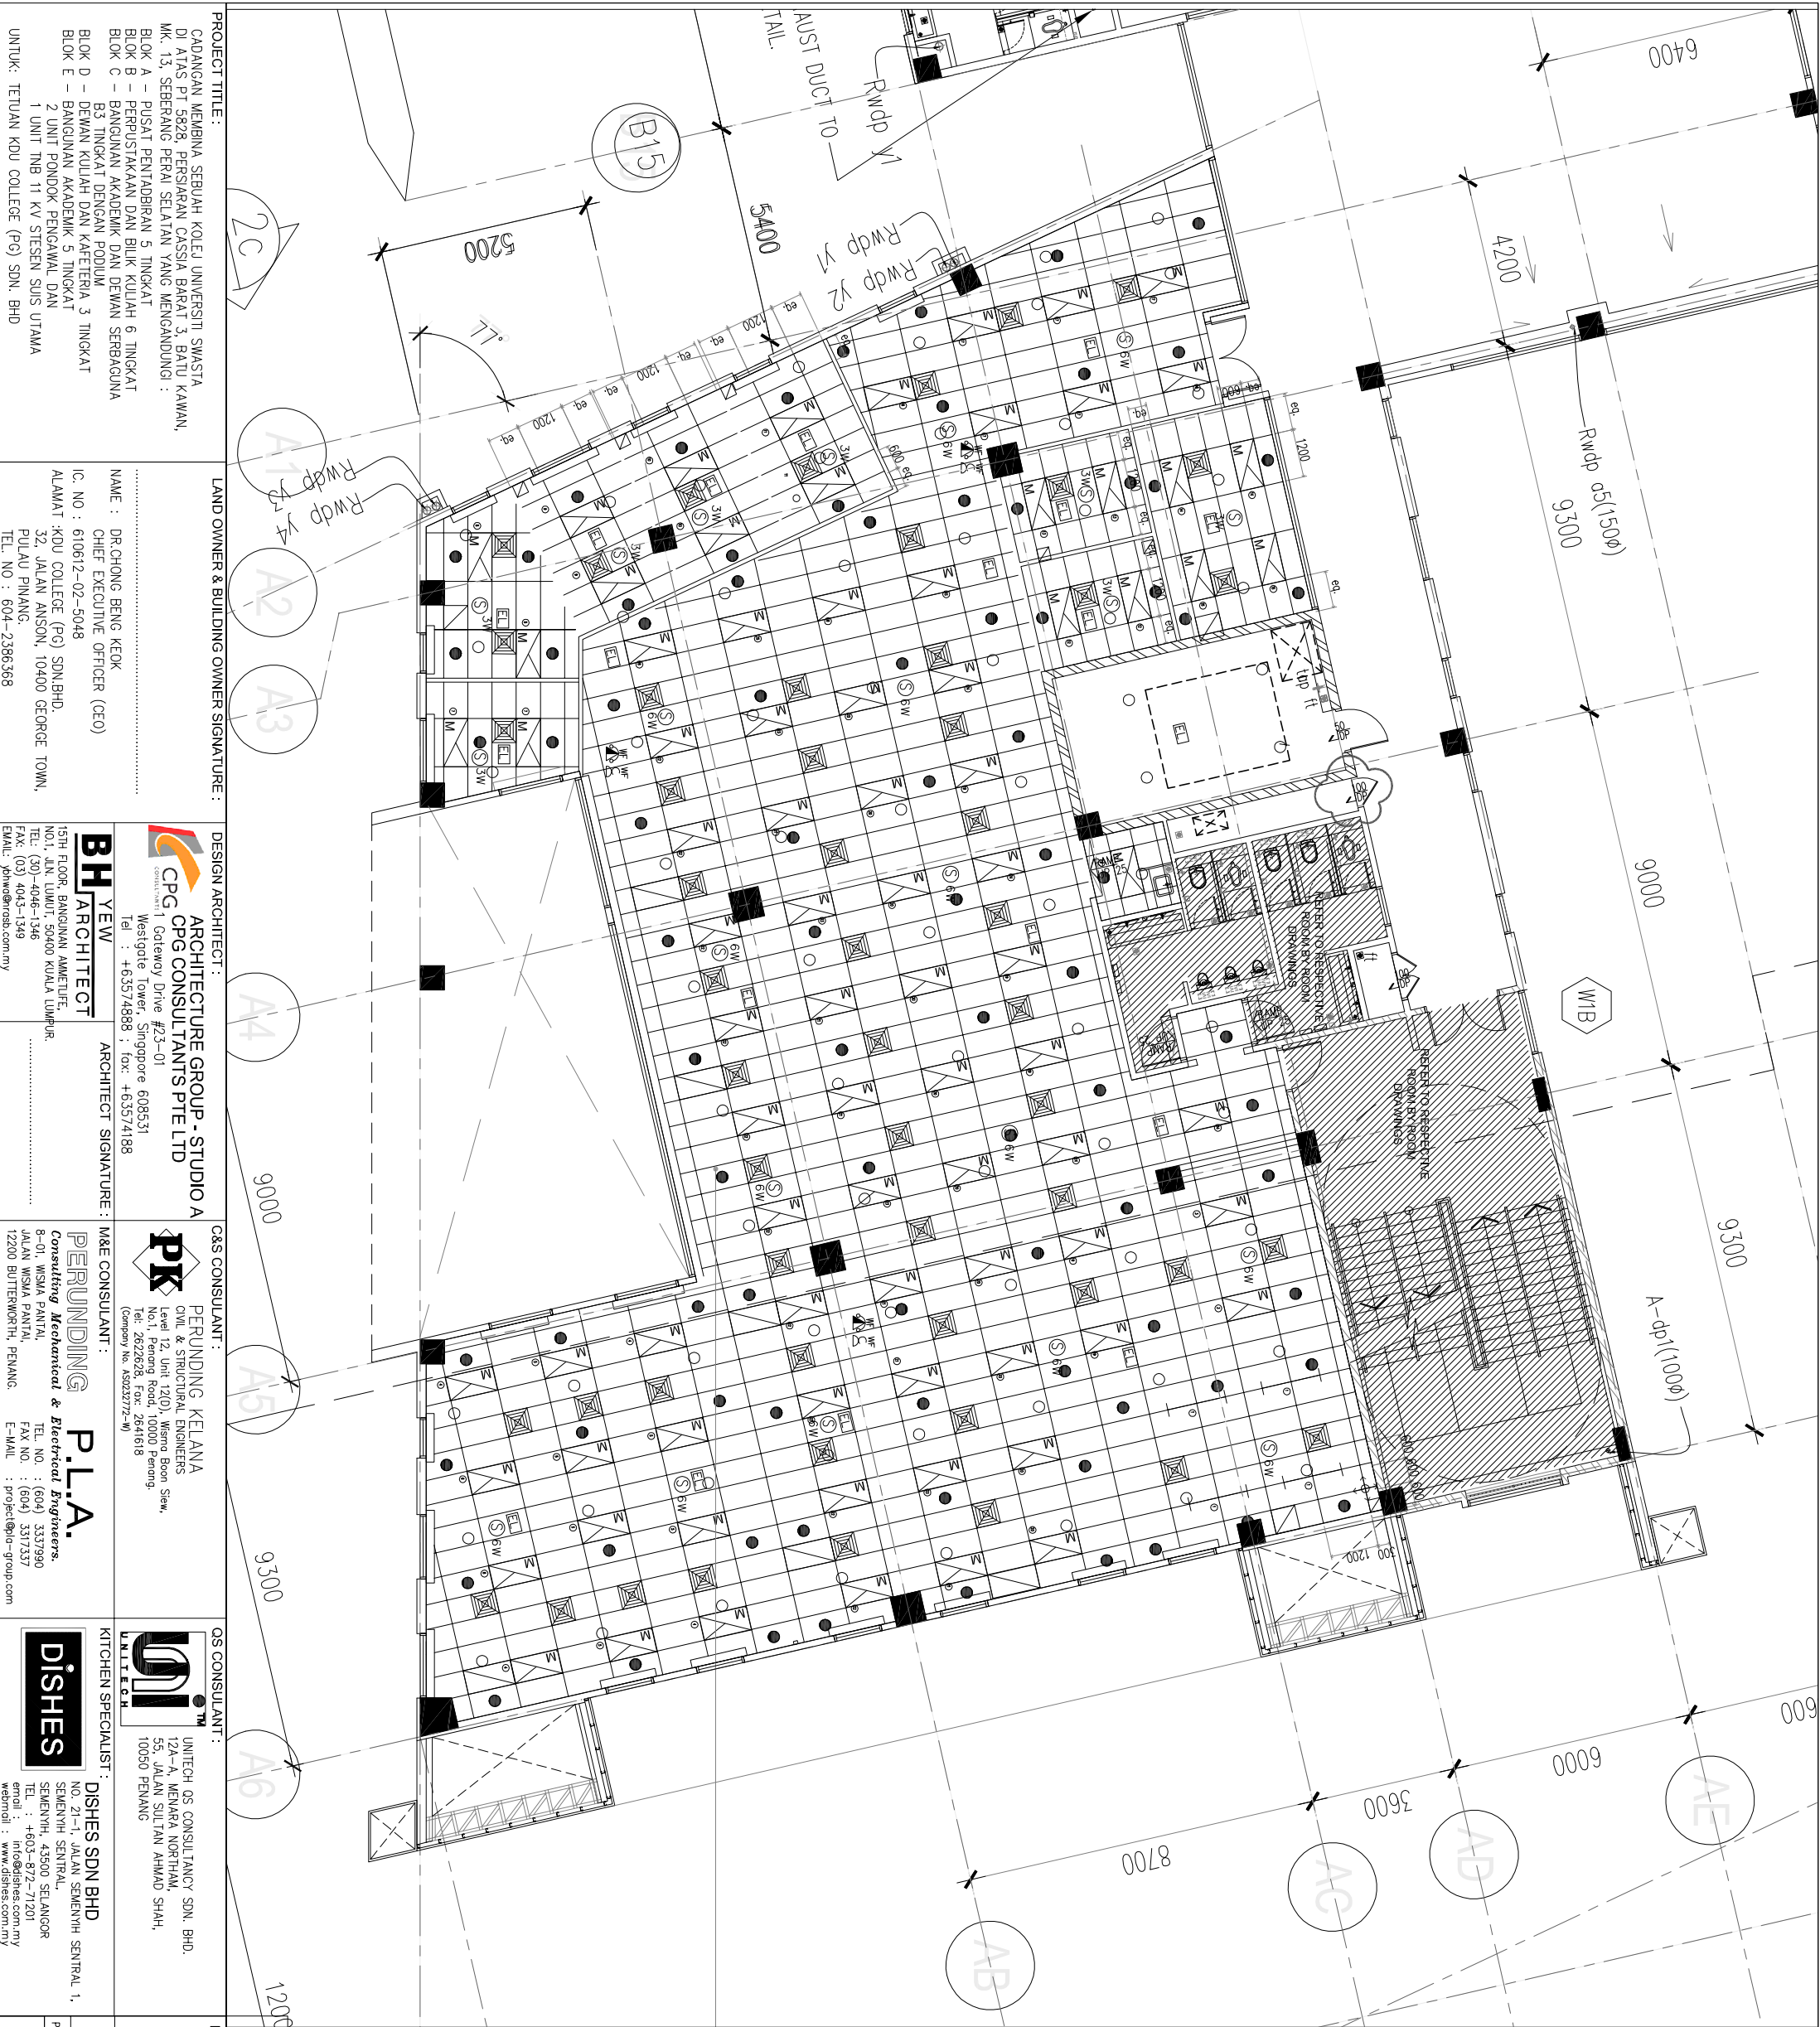

PROJECT TITLE : CADANGAN MEMBINA SEBUAH KOLEJ UNIVERSITI SWASTA DI ATAS PT 5828 PERJARAN CASSIA BARAT 3, BATU KAWAN, MK. 13, SEBERANG PERAI SELATAN YANG MENGAUNDUNG : BLOK A – PUSAT PENYADIRAN 5 TINGKAT BLOK B – PERUSTAKAAN DAN BILIK KULIAH 6 TINGKAT BLOK C – BANGUNAN AKADEMIK DAN DEWAN SERBAGUNA B3 TINGKAT DENGAN PODIUM BLOK D – DEWAN KULIAH DAN KAFETERIA 3 TINGKAT BLOK E – BANGUNAN AKADEMIK 5 TINGKAT 2 UNIT TMB 11 KV STEEN SINS UTAMA UNTUK: TETUAN KDU COLLEGE (PG) SDN. BHD		LAND OWNER & BUILDING OWNER SIGNATURE : NAME : DR.CHONG BENG KEOK CHIEF EXECUTIVE OFFICER (CEO) IC NO : 610612-02-5048 ALAMAT :KDU COLLEGE (PG) SDN.BHD. 32, JALAN ANSON, 10400 GEORGE TOWN, PULAU PINANG. TEL NO : 604-2386368	
DESIGN ARCHITECT :  ARCHITECTURE GROUP - STUDIO A CPG CONSULTANTS PTE LTD Westgate Tower, Singapore 608531 Tel : +65374888 ; fax: +65374188		C&S CONSULTANT :  PERUNDING KELANA CIVIL & STRUCTURAL ENGINEERS Level 12, Unit 12(0), Wisma Boon Siew, No.1, Penang Road, 10000 Penang. Tel: 2622628, Fax: 2641618 (Company No. 85023772-M)	
BH YEOW  ARCHITECT 15TH FLOOR, BANGSIAN AMARTUTE, NO.1, JLN LUMUT, 50400 KUALA LUMPUR. TEL: (60) 4046-1346 FAX: (60) 4043-1349 EMAIL: jphw@bh.com.my		OS CONSULTANT :  UNITECH OS CONSULTANCY SDN. BHD. 12A-A, MENARA MORTIMAN, 55, JALAN SULTAN AHMAD SHAH, 10050 PENANG	
PERUNDING P.L.A.  Consulting Mechanical & Electrical Engineers. 8-01, WISMA PANTAI, JALAN WISMA PANTAI, 12200 BUTTERWORTH, PENANG. TEL NO. : (604) 3337990 FAX NO. : (604) 3317337 E-MAIL : project@plc-group.com		KITCHEN SPECIALIST : DISHES SDN BHD  DISHES NO.21-1, JALAN SEMENYIH SENTRAL 1, SEMENYIH SENTRAL, SEMENYIH, 43500 SELANGOR TEL : +603-872-71201 email : info@dishes.com.my website : www.dishes.com.my	
DRAWING TITLE : BLOCK A-3RD FLOOR ADMIN OFFICES REFLECTED CEILING PLAN		DATE : 23.03.17 SCALE : CHECK BY : PROJECT NO. : STATUS : BLOCK : DWG. NO : REVISION : CD A A108 B	

CONSTRUCTION DRAWING

CEILING REFER TO SCHEDULE
AT 3000MM(H) FROM FFL

LEGEND : ACMV INSTALLATION	
SYMBOL	DESCRIPTION(S)
	AIR HANDLING UNIT (AHU)
	SUPPLY AIR GRILLE
	FT DIFFUSER
	1200mm X 600mm RETURN AIR GRILLE
	600mm X 600mm RETURN AIR GRILLE
	300mm X 300mm RETURN AIR GRILLE
	150mm X 150mm EXHAUST AIR GRILLE
	FRESH AIR GRILLE
	EXHAUST AIR GRILLE
	DOOR ACTUATOR FOR SMOKE SPILL SYSTEM (SLIDING DOOR)
	SMOKE SPILL FAN
LEGEND: PUBLIC ADDRESS SYSTEM.	
SYMBOL	DESCRIPTION(S)
	6W RECESSED CEILING MOUNTED SPEAKER C/W MATCHING THUNDER ORNER (100" AT 15W)
	3W RECESSED CEILING SPEAKER (3W)
	COMPUTER/DATA (I/O) I/O PT. C/W SOCKET OUTLET USING CAT. 6 CABLE IN UPVC CONDUIT/CONCEALED
	WIFI POINT C/W SOCKET OUTLET AT CEILING LEVEL USING CAT 6 CABLE IN UPVC CONDUIT/CONCEALED.
	P DOME CAMERA
	STANDALONE CCTV
	CARD ACCESS C/W ENTRANCE READER & PRESS RELEASE BUTTON
	ELECTROMAGNETIC LOCK C/W BREAKGLASS