


BRICKWALL WITH PLASTER AND PAINT FINISH
(GRAPHIC BY ID CONTRACTOR)

CONCRETE STAIRCASE WITH 300MM(H)
TIMBER SKIRTING BAND – FRAMELESS
GLASS RAILING & ROUND TIMBER
HANDRAIL

TO DOOR SCHEDULE

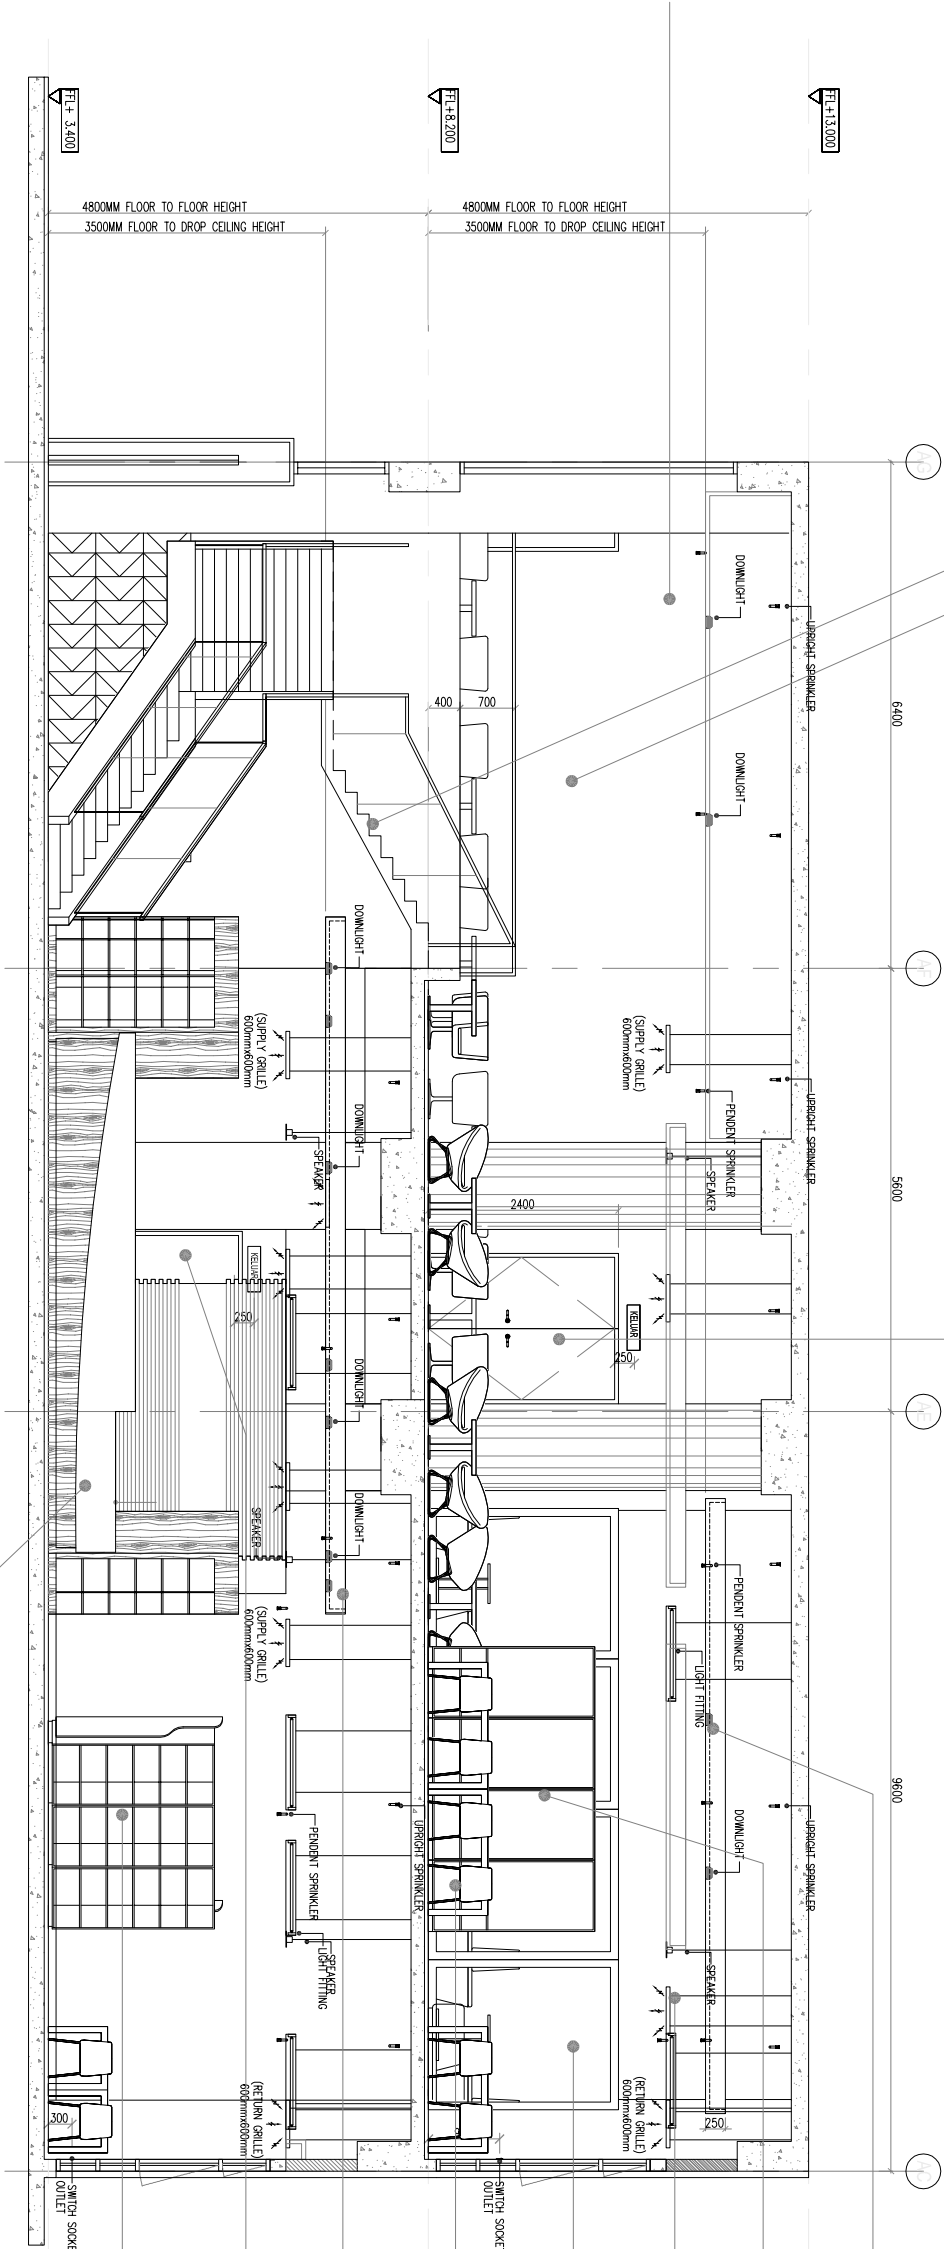

CEILING REFER TO SCHEDULE
AT 3500MM(H) FROM FFL

BOOK SHELL TO LOOSE
FURNITURE SCHEDULE
& DETAIL

BRICKWALL WITH PLASTER
AND PAINT

BUILT-IN CUBE SEATING
IN FABRIC AND CUSHION
WITH LAMINATE FINISH FRAMING
AND TABLE (BY ID CONTRACTOR)

LOOSE FURNITURE TO SCHEDULE
(ID)

CEILING REFER TO SCHEDULE
AT 3500MM(H) FROM FFL

TO DOOR SCHEDULE

BOOK SHELL TO LOOSE
FURNITURE SCHEDULE
& DETAIL

BUILT-IN COUNTER IN
LAMINATE FINISH AND SOLID
SURFACE COUNTER TOP
(BY ID CONTRACTOR)

SECTIONAL ELEVATION 1 - LIBRARY

CONSTRUCTION DRAWING

PROJECT TITLE :

LAND OWNER & BUILDING OWNER SIGNATURE :

DESIGN ARCHITECT :

C&S CONSULTANT :

QS CONSULTANT :

DRAWING TITLE :

CADANGAN MEMBINA SEBUAH KOLEJ UNIVERSITI SWASTA
DI ATAS PT 5828, PERSAJARAN CASSA, BARAT 3, BATU KAWAN,
MK. 13, SEBERANG PERAI SELATAN YANG MENGANDUNGI :

ARCHITECTURE GROUP - STUDIO A
CPG ARCHITECTS PTE LTD
Westgate Tower, Singapore 608531
Tel : +65374888 ; fax: +65374188

PERUNDING KELANA
CIVIL & STRUCTURAL ENGINEERS
Level 12, Unit 12(0), Wisma Boon Siew,
No.1, Penang Road, 10000 Penang.
Tel: 2622628, Fax: 2641618
(Company No. AS023772-W)

UNITECH QS CONSULTANCY SDN. BHD.
12A-A, MENARA MORTIM,
55, JALAN SULTAN AHMAD SHAH,
10050 PENANG

BLOCK B - GROUND & 1ST FLOOR
LIBRARY
SE 1

BLOK A – PUSAT PENYADIBRAN 5 TINGKAT
BLOK B – PERPUSTAKAAN DAN BILIK KULIAH 6 TINGKAT
BLOK C – BANGUNAN AKADEMIK DAN DEWAN SERBAGUNA
B3 TINGKAT DENGAN PODIUM
BLOK D – DEWAN KULIAH DAN KAFETERIA 3 TINGKAT
BLOK E – BANGUNAN AKADEMIK 5 TINGKAT
1 UNIT TMB 11 KV STESEN SUIS UTAMA
UNTUK: TETUAN KDU COLLEGE (PG) SDN. BHD

NAME : DR.CHONG BENG KEOK
CHIEF EXECUTIVE OFFICER (CEO)
IC. NO : 610612-02-5048
ALAMAT :KDU COLLEGE (PG) SDN.BHD.
32, JALAN ANSON, 10400 GEORGE TOWN,
PULAU PINANG.
TEL. NO : 604-2386368

ARCHITECT SIGNATURE :
BH YEWE
ARCHITECT
15TH FLOOR, BANGUNAN AMETURE,
NO.1, JLN. LUMUT, 50000 KUALA LUMPUR.
TEL. (30) -4046-1346
FAX. (30) 4043-1349
EMAIL. jphw@arob.com.my

PERUNDING P.L.A.
Consulting Mechanical & Electrical Engineers.
8-01, WISMA PANTAI,
JALAN WISMA PANTAI,
12200 BUTTERWORTH, PENANG.
TEL. NO. : (604) 3337990
FAX NO. : (604) 3317337
E-MAIL : project@p-l-a-group.com

KITCHEN SPECIALIST :
DISHES SDN BHD
NO. 21-1, JALAN SEMENYIH SENTRAL 1,
SEMENYIH SENTRAL,
SEMENYIH, 43500 SELANGOR
TEL : +603-872-71201
email : info@dishes.com.my
websites : www.dishes.com.my

DATE :	SCALE :	CHECK BY :	PROJECT NO. :	STATUS	BLOCK	DWG. NO	REVISION
24.03.17	1:100	EU/EDM	55314	CA	B	B005	B