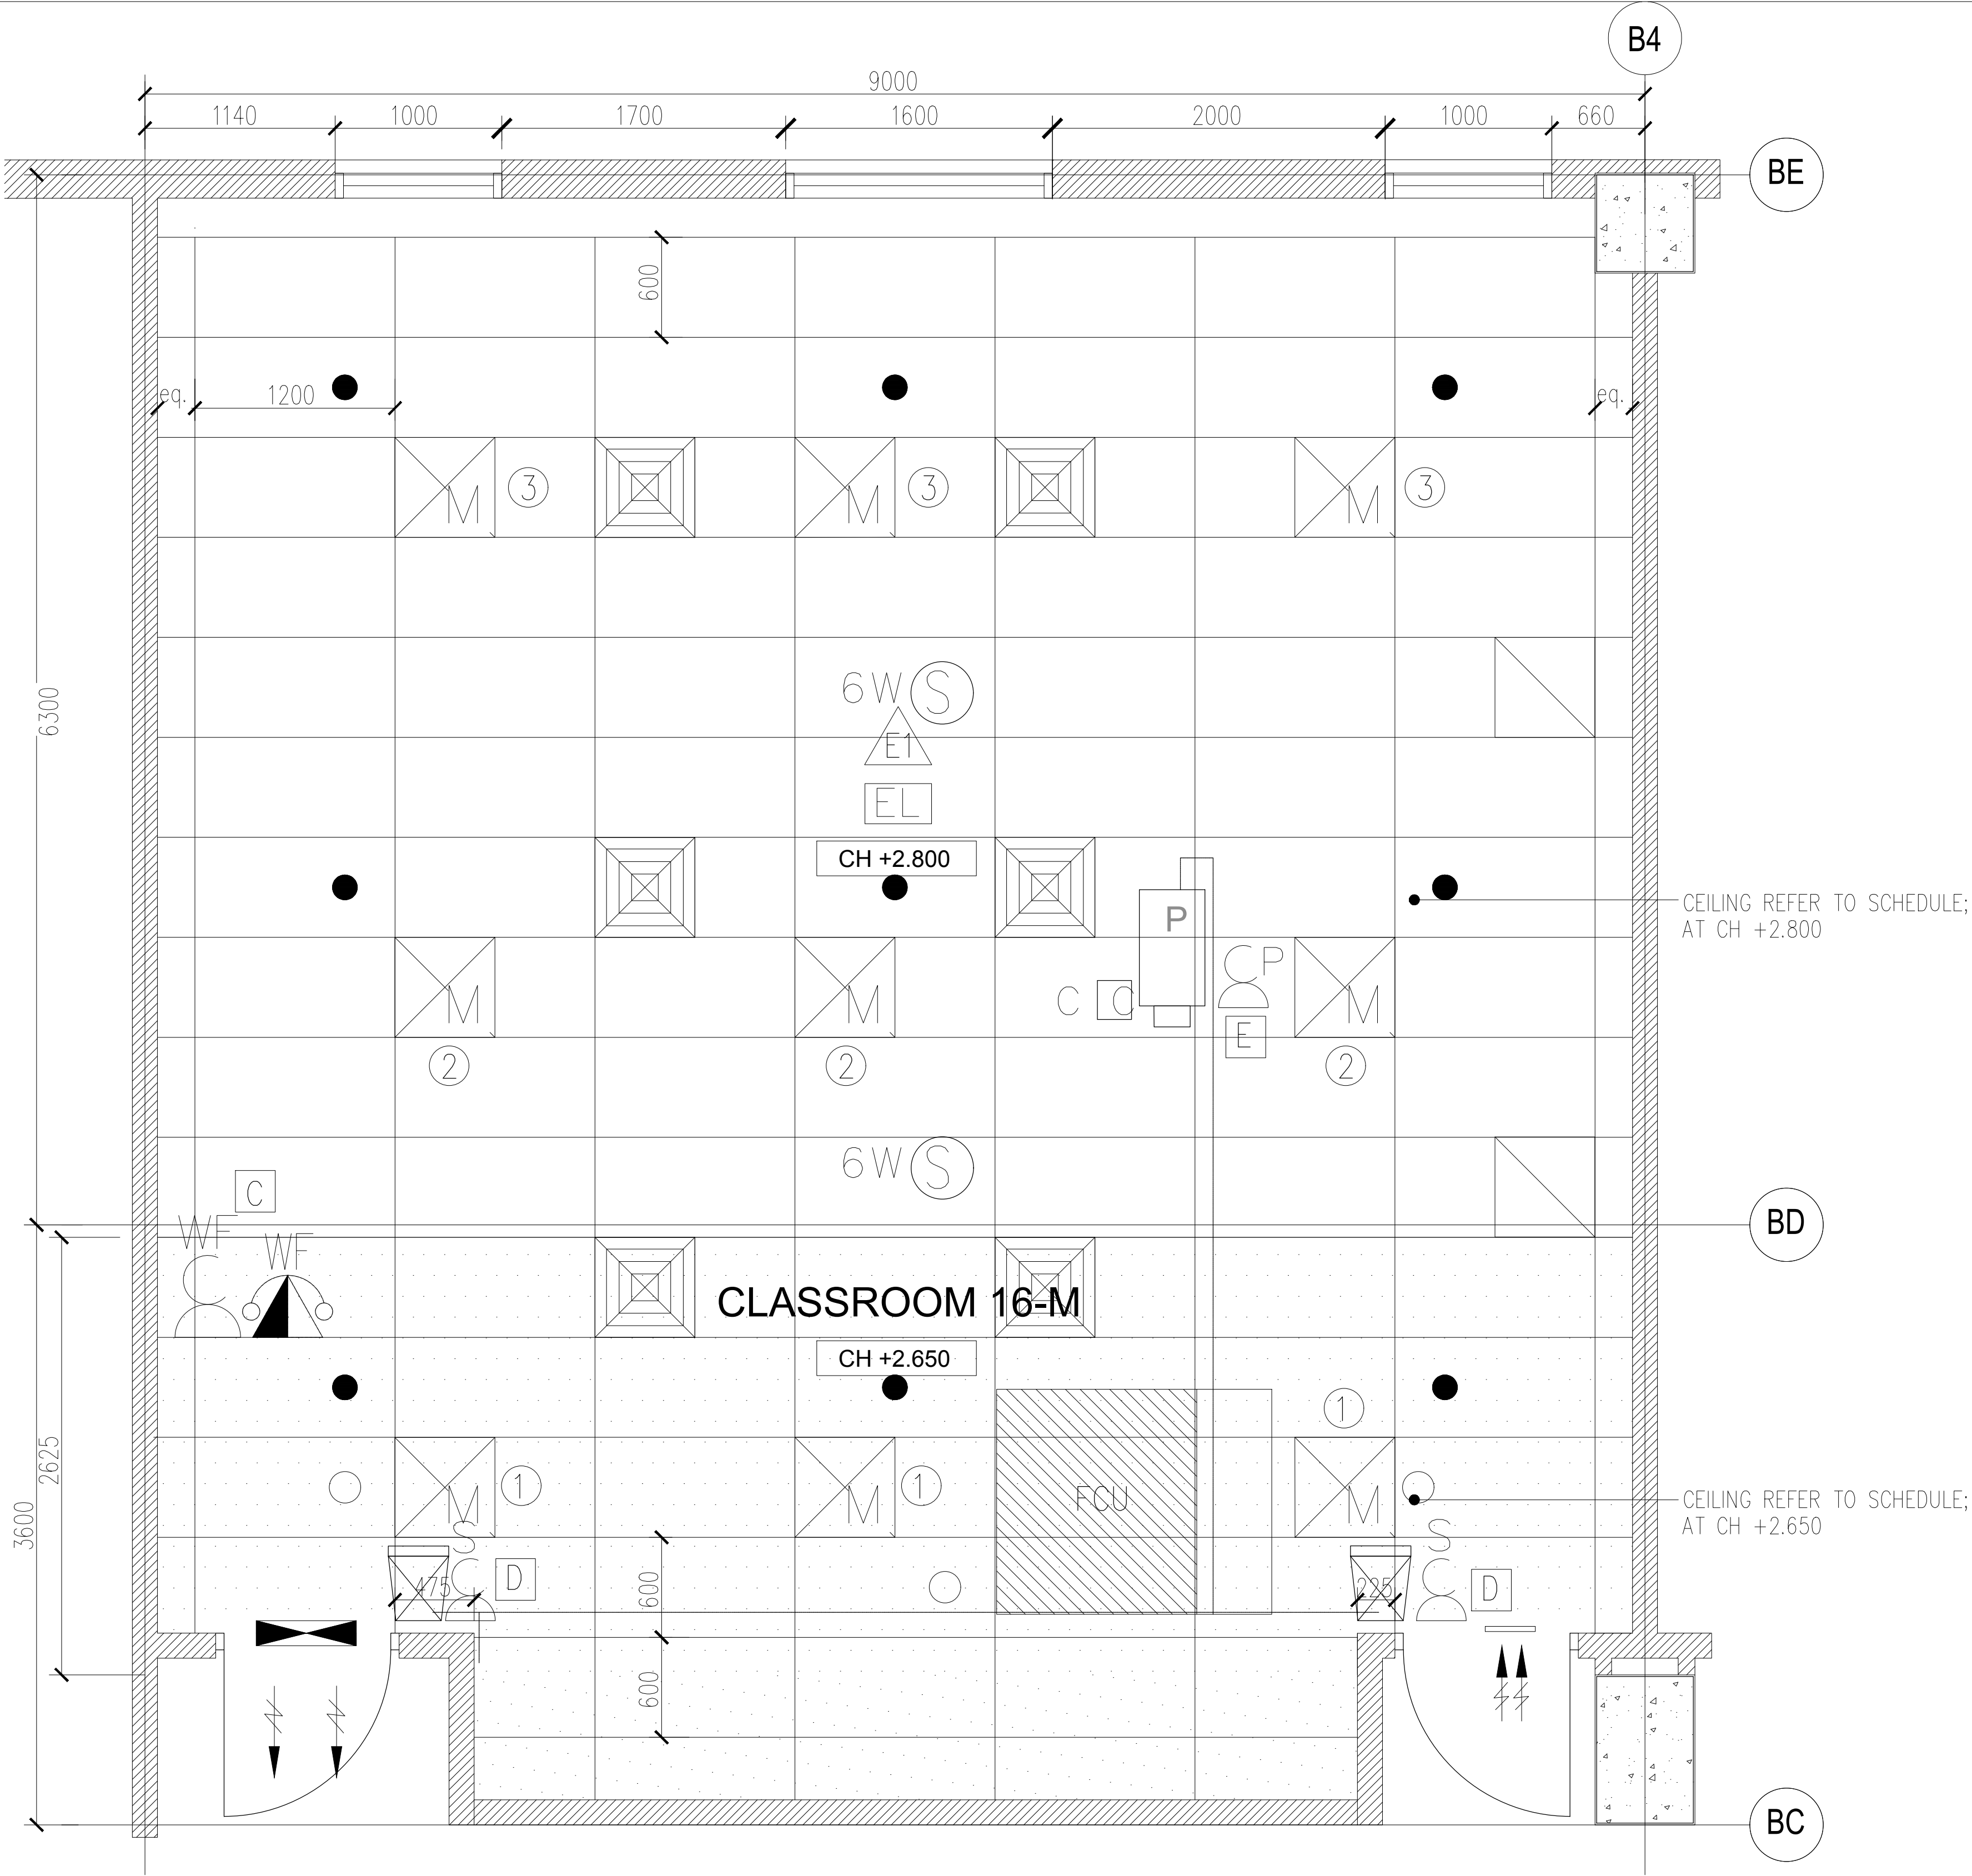




LEGEND : ELECTRICAL INSTALLATION		
SYMBOL	DESCRIPTION(S)	QTY
	2 X 28W RECESSED TYPE T5 FLUO. FTG. C/W MIRROR REFLECTOR & ALUMINIUM CROSS BLADE. (ELECTRONIC BALLAST)	9
	10A 1/2/3/ GANG ONE WAY LIGHTING SWITCH AT 1450mm AFFL.	1
	13A TWIN SWITCH SOCKET OUTLET AT 300mm AFFL.	4
	13A SWITCH SOCKET OUTLET AT ABOVE CEILING LEVEL FOR PROJECTOR	1
	13A SWITCH SOCKET OUTLET AT ABOVE CEILING LEVEL FOR WIFI SYSTEM	1
	13A SWITCH SOCKET OUTLET AT BELOW CEILING LEVEL FOR SPEAKER	2
	20A 1 GANG ONE WAY DOUBLE POLE SWITCH (FOR PROJECTOR & SPEAKER)	2
	~25MM PVC CONDUIT FOR AUDIO AND VISUAL C/W INSPECTION BOX (BY ELECTRICAL CONTRACTOR)	AS SHOWN

LEGEND : TELEPHONE INSTALLATION		
SYMBOL	DESCRIPTION(S)	
	COMPUTER/DATA (1G) UTP PT. C/W SOCKET OUTLET USING CAT. 6 CABLE IN UPVC CONDUIT/CONCEALED	2
	WIFI POINT C/W SOCKET OUTLET AT CEILING LEVEL USING CAT 6 CABLE IN UPVC CONDUIT/CONCEALED.	1

LEGEND : ACMV INSTALLATION		
SYMBOL	DESCRIPTION(S)	
	SUPPLY AIR GRILLE (600 x 600 UNLESS OTHERWISE STATED) 4 WAY TYPE C/W OPPOSED BLADE VOLUME CONTROL DAMPER (UNLESS OTHERWISE STATED)	6
	600mm X 600mm RETURN AIR GRILLE	2
	FAN COIL UNIT (FCU)	1
	A/C CONTROL MODULE	1
	300MM X 300MM FRESH AIR GRILLE C/W VOLUME CONTROL DAMPER	1
	WALL MOUNTED EXHAUST FAN C/W FIXED LOUVER & INSERT SCREEN	1
	PLENUM BOX	1

 
 
 
LEGEND : FIRE INSTALLATION		
SYMBOL	DESCRIPTION(S)	
	PENDENT SPRINKLER (155°F/68°C TEMPERATURE RATING).	9
	UPRIGHT SPRINKLER (155°F/68°C TEMPERATURE RATING).	3
	EMERGENCY LIGHT. (SUPPLY & INSTALL BY ELECTRICAL CONTRACTOR)	1

LEGEND: PUBLIC ADDRESS SYSTEM.		
SYMBOL	DESCRIPTION(S)	
	6W RECESSED CEILING MOUNTED SPEAKER C/W MATCHING TRANSFORMER (TAP AT 1.5W)	2

LEGEND: AUDIO/VISUAL SYSTEM. (SUPPLY & INSTALL BY AUDIO & VISUAL CONTRACTOR)		
SYMBOL	DESCRIPTION(S)	
	HDMI & AUDIO INPUT PANEL (RECESS INTO WALL)	1
	3 WAYS ACTIVE SPEAKER (TO AUDIO & VISUAL DETAILS)	2
	3000 ANSI LUMENS WXGA 3LCD PROJECTOR (TO AUDIO & VISUAL DETAILS) ~PROJECTOR SUPPORT SUPPLIED BY MAIN CONTRACTOR	1

LEGEND : FURNITURE SCHEDULE					
CODE	DESCRIPTION(S)	NOS	CODE	DESCRIPTION(S)	NOS
T01-CR	TEACHER'S DESK	1	C01-CR	TEACHER'S CHAIR	1
T02-CR	STUDENT DESK	45	C02-CR	STUDENT CHAIR TYPE 1	45
T03-CR	STUDENT TABLE (FOR SMART CLASSROOM)	-	C03-CR	STUDENT CHAIR TYPE 2	-
			C04-CR	STUDENT CHAIR WITH TABLET	-

TENDER DRAWING

PROJECT TITLE : CADANGAN MEMBINA SEBUAH KOLEJ UNIVERSITI SWASTA DI ATAS PT 5828, PERSIARAN CASSIA BARAT 3, BATU KAWAN, MK. 13, SEBERANG PERAI SELATAN YANG MENGANDUNGI : BLOK A – PUSAT PENTADBIRAN 5 TINGKAT BLOK B – PERPUSTAKAAN DAN BILIK KULIAH 6 TINGKAT BLOK C – BANGUNAN AKADEMIK DAN DEWAN SERBAGUNA B3 TINGKAT DENGAN PODIUM BLOK D – DEWAN KULIAH DAN KAFETERIA 3 TINGKAT BLOK E – BANGUNAN AKADEMIK 5 TINGKAT 2 UNIT PONDOK PENGAWAL DAN 1 UNIT TNB 11 KV STESEN SUIS UTAMA UNTUK: TETUAN KDU COLLEGE (PG) SDN. BHD	LAND OWNER & BUILDING OWNER SIGNATURE : NAME : DR.CHONG BENG KEOK CHIEF EXECUTIVE OFFICER (CEO) IC. NO : 610612-02-5048 ALAMAT :KDU COLLEGE (PG) SDN.BHD. 32, JALAN ANSON, 10400 GEORGE TOWN, PULAU PINANG. TEL. NO : 604-2386368	DESIGN ARCHITECT :  ARCHITECTURE GROUP - STUDIO A CPG CONSULTANTS PTE LTD 1 Gateway Drive #23-01 Westgate Tower, Singapore 608531 Tel : +63574888 ; fax: +63574188	C&S CONSULTANT :  PERUNDING KELANA CIVIL & STRUCTURAL ENGINEERS Level 12, Unit 12(D), Wisma Boon Siew, No.1, Penang Road, 10000 Penang. Tel: 2622628, Fax: 2641618 (Company No. AS0232772-W)	QS CONSULTANT :  UNITECH QS CONSULTANCY SDN. BHD. 12A-A, MENARA NORTHAM, 55, JALAN SULTAN AHMAD SHAH, 10050 PENANG	DRAWING TITLE : BLOCK B_3RD FLOOR CLASS ROOM 16(M) REFLECTED CEILING PLAN					
		 15TH FLOOR, BANGUNAN AMMETLIFE, NO.1, JLN. LUMUT, 50400 KUALA LUMPUR. TEL: (30)-4046-1346 FAX: (03) 4043-1349 EMAIL: ybhwa@nrasb.com.my	ARCHITECT SIGNATURE :	M&E CONSULTANT :  Consulting Mechanical & Electrical Engineers. 8-01, WISMA PANTAI, TEL. NO. : (604) 3337990 JALAN WISMA PANTAI, FAX NO. : (604) 3317337 12200 BUTTERWORTH, PENANG. E-MAIL : project@pla-group.com	KITCHEN SPECIALIST :  DISHES SDN BHD NO. 21-1, JALAN SEMENYIH SENTRAL 1, SEMENYIH SENTRAL, SEMENYIH, 43500 SELANGOR TEL : +603-872-71201 email : info@dishes.com.my webmail : www.dishes.com.my	DATE : 07.04.17	SCALE : 1:50	CHECK BY : EJ/EDM		
						PROJECT NO. :	STATUS	BLOCK	DWG. NO	REVISION
						55314	CA	B	E106	-