



PODIUM FLOOR
PAVING & MATERIAL PLAN

LANDSCAPE LIGHTING SCHEDULE			
SYM.	LIGHT FITTING DESCRIPTION	APPLICATION	QUANTITY
	ACCENT GARDEN LIGHT (GROUND SPIKE)	HIGHLIGHT PLANTING AREA	70 NOS
	IN-GROUND LIGHT (RECESSED ON FLOOR)	HIGHLIGHT RAMP & STEPS	14 NOS
	BOLLARD LIGHT (0.9M HEIGHT)	HIGHLIGHT TERRACE GARDEN & STEPS	10 NOS
	POLE LIGHT (3.9M HEIGHT)	HIGHLIGHT WALKWAY & POOL DECK AREA	11 NOS
	UNDERWATER LIGHT (RECESSED ON POOL WALL)	HIGHLIGHT INTERNAL POOLS	22 NOS
	PENDANT LIGHT (2-3 NOS PER SET)	HIGHLIGHT INTERNAL SHELTER	10 NOS
	UNDERWATER LED NOZZLE JETS LIGHT (RECESSED ON CASCADING WATER FEATURE)	HIGHLIGHT FOAM JETS	4 NOS
TOTAL			141 NOS


WATER TAP SCHEDULE			
SYM.	DESCRIPTION	APPLICATION	QUANTITY
	WATER TAP	450mm height anti-vandalism water tap with removable head	7 NOS

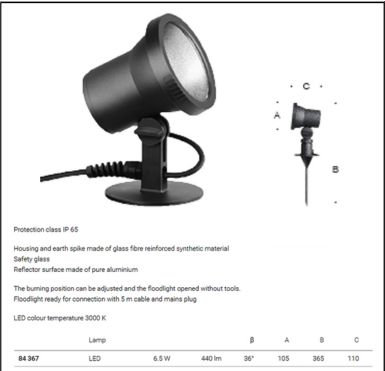


ACCENT GARDEN LIGHT

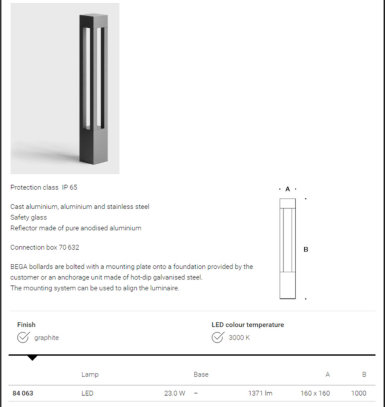


BOLLARD LIGHT

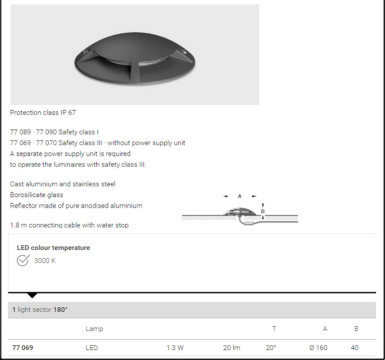


IN-GROUND LIGHT

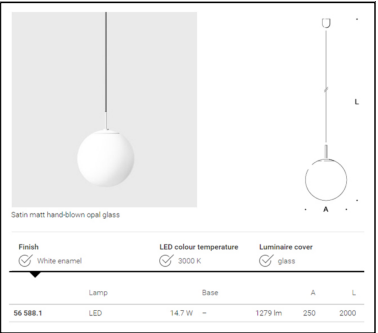

PENDANT LIGHT

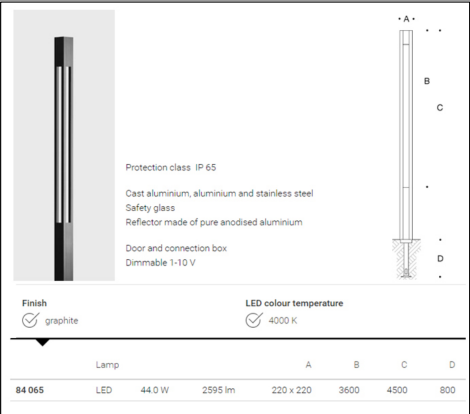

POLE LIGHT

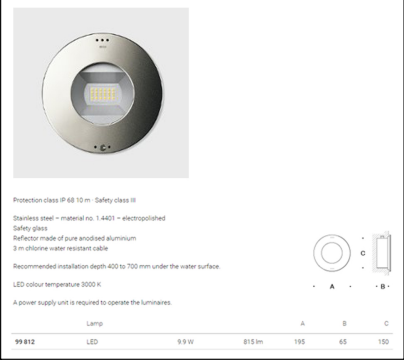

UNDERWATER LIGHT




UNDERWATER LED NOZZLE JETS LIGHT

LEVEL 9 PODIUM FLOOR
LIGHTING PLAN

SCALE 1 : 350

This drawing may not be reproduced or used without the written permission from LANDART DESIGN

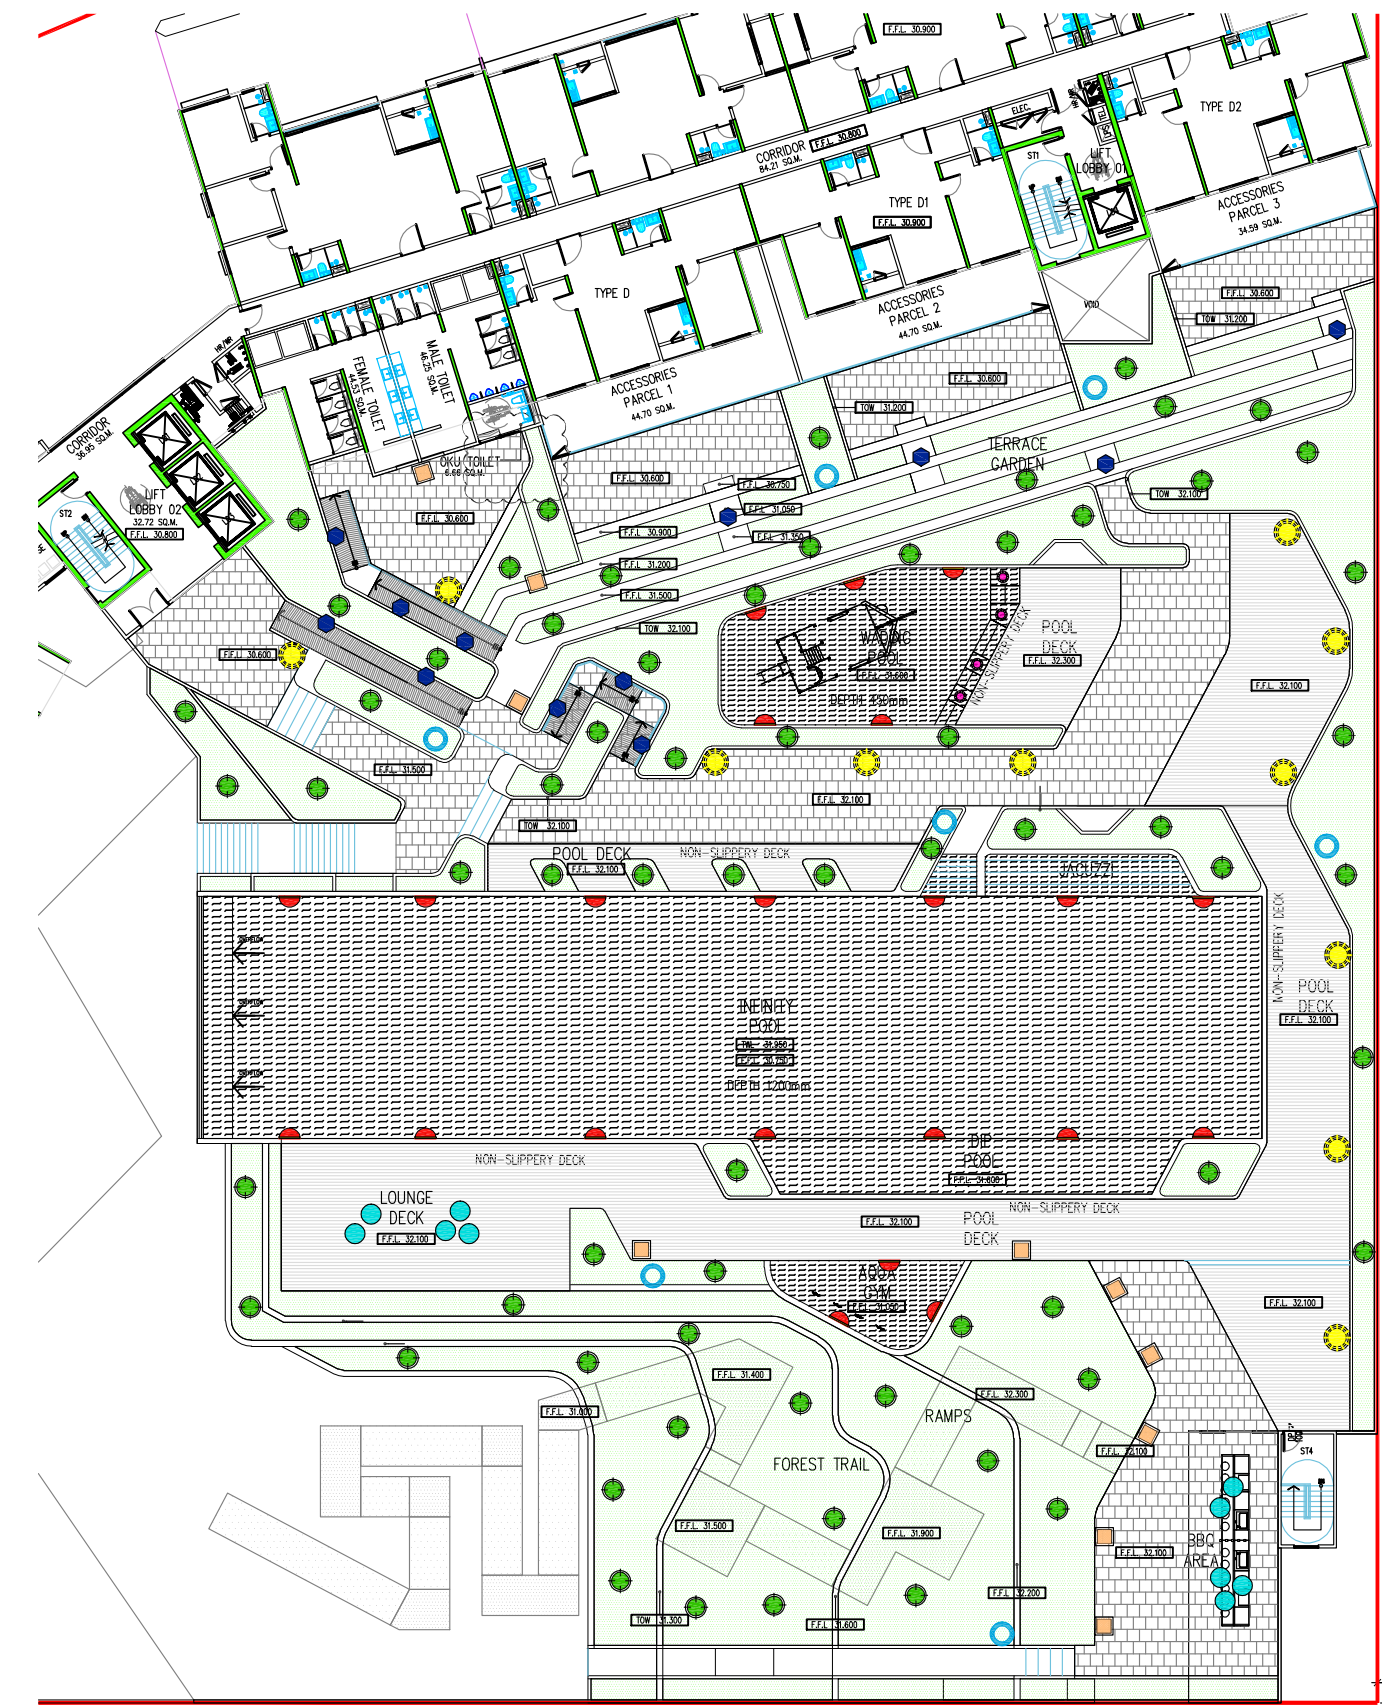

PROJECT
PLOT 2 - UTROPOLIS BATU KAWAN
CADANGAN PEMBANGUNAN (FASA 2) YANG MENGANDUNGI 2 BLOK PANGSAPURI PERKHIDMATAN 40 TINGKAT (491 UNIT) DENGAN TEMPAT LETAK KENDERAAN DI ATAS LOT 21609 (SEBAHAGIAN LOT 21135 SEBELUM INI), JALAN CASSIA BARAT 2, MUKIM 13, SEBERANG PERAI SELATAN, PULAU PINANG

DRAWING TITLE
LEVEL 9 PODIUM FLOOR
- LANDSCAPE LIGHTING PLAN

CLIENT
PARAMOUNT PROPERTY (PW) SDN BHD
(Company No.)
WISMA PARAMOUNT, 1A (1ST FLOOR)
LORONG BLM 1/1, BANDAR LAGUNA
MERBOK, 08000 SG PETANI, KEDAH.
TEL: 04-4419191 FAX: 04-4419090

DRAWING STATUS AND DATE :

DATE	REVISED	REF.	SCALE : AS SHOWN	DRAWING NO :
			UNIT : MM	15052(SB)
			DATE : NOV 2017	
			DRAWN BY : FEEZA	
			CHECKED BY : ATIF	

SHEET NO.	PROJECT NO.
---	15052(SB)
FILE :	557_PT2-BP1A-109_LANDSCAPE

Landart project\15052 (sb) - utropolis paramount\vw consultants drawings\plot 2\171031 - landscape lighting\557_pt2-bp1a-109_landscape lighting.dwg