
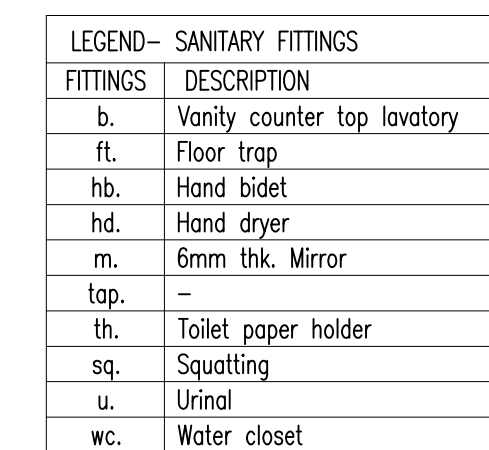


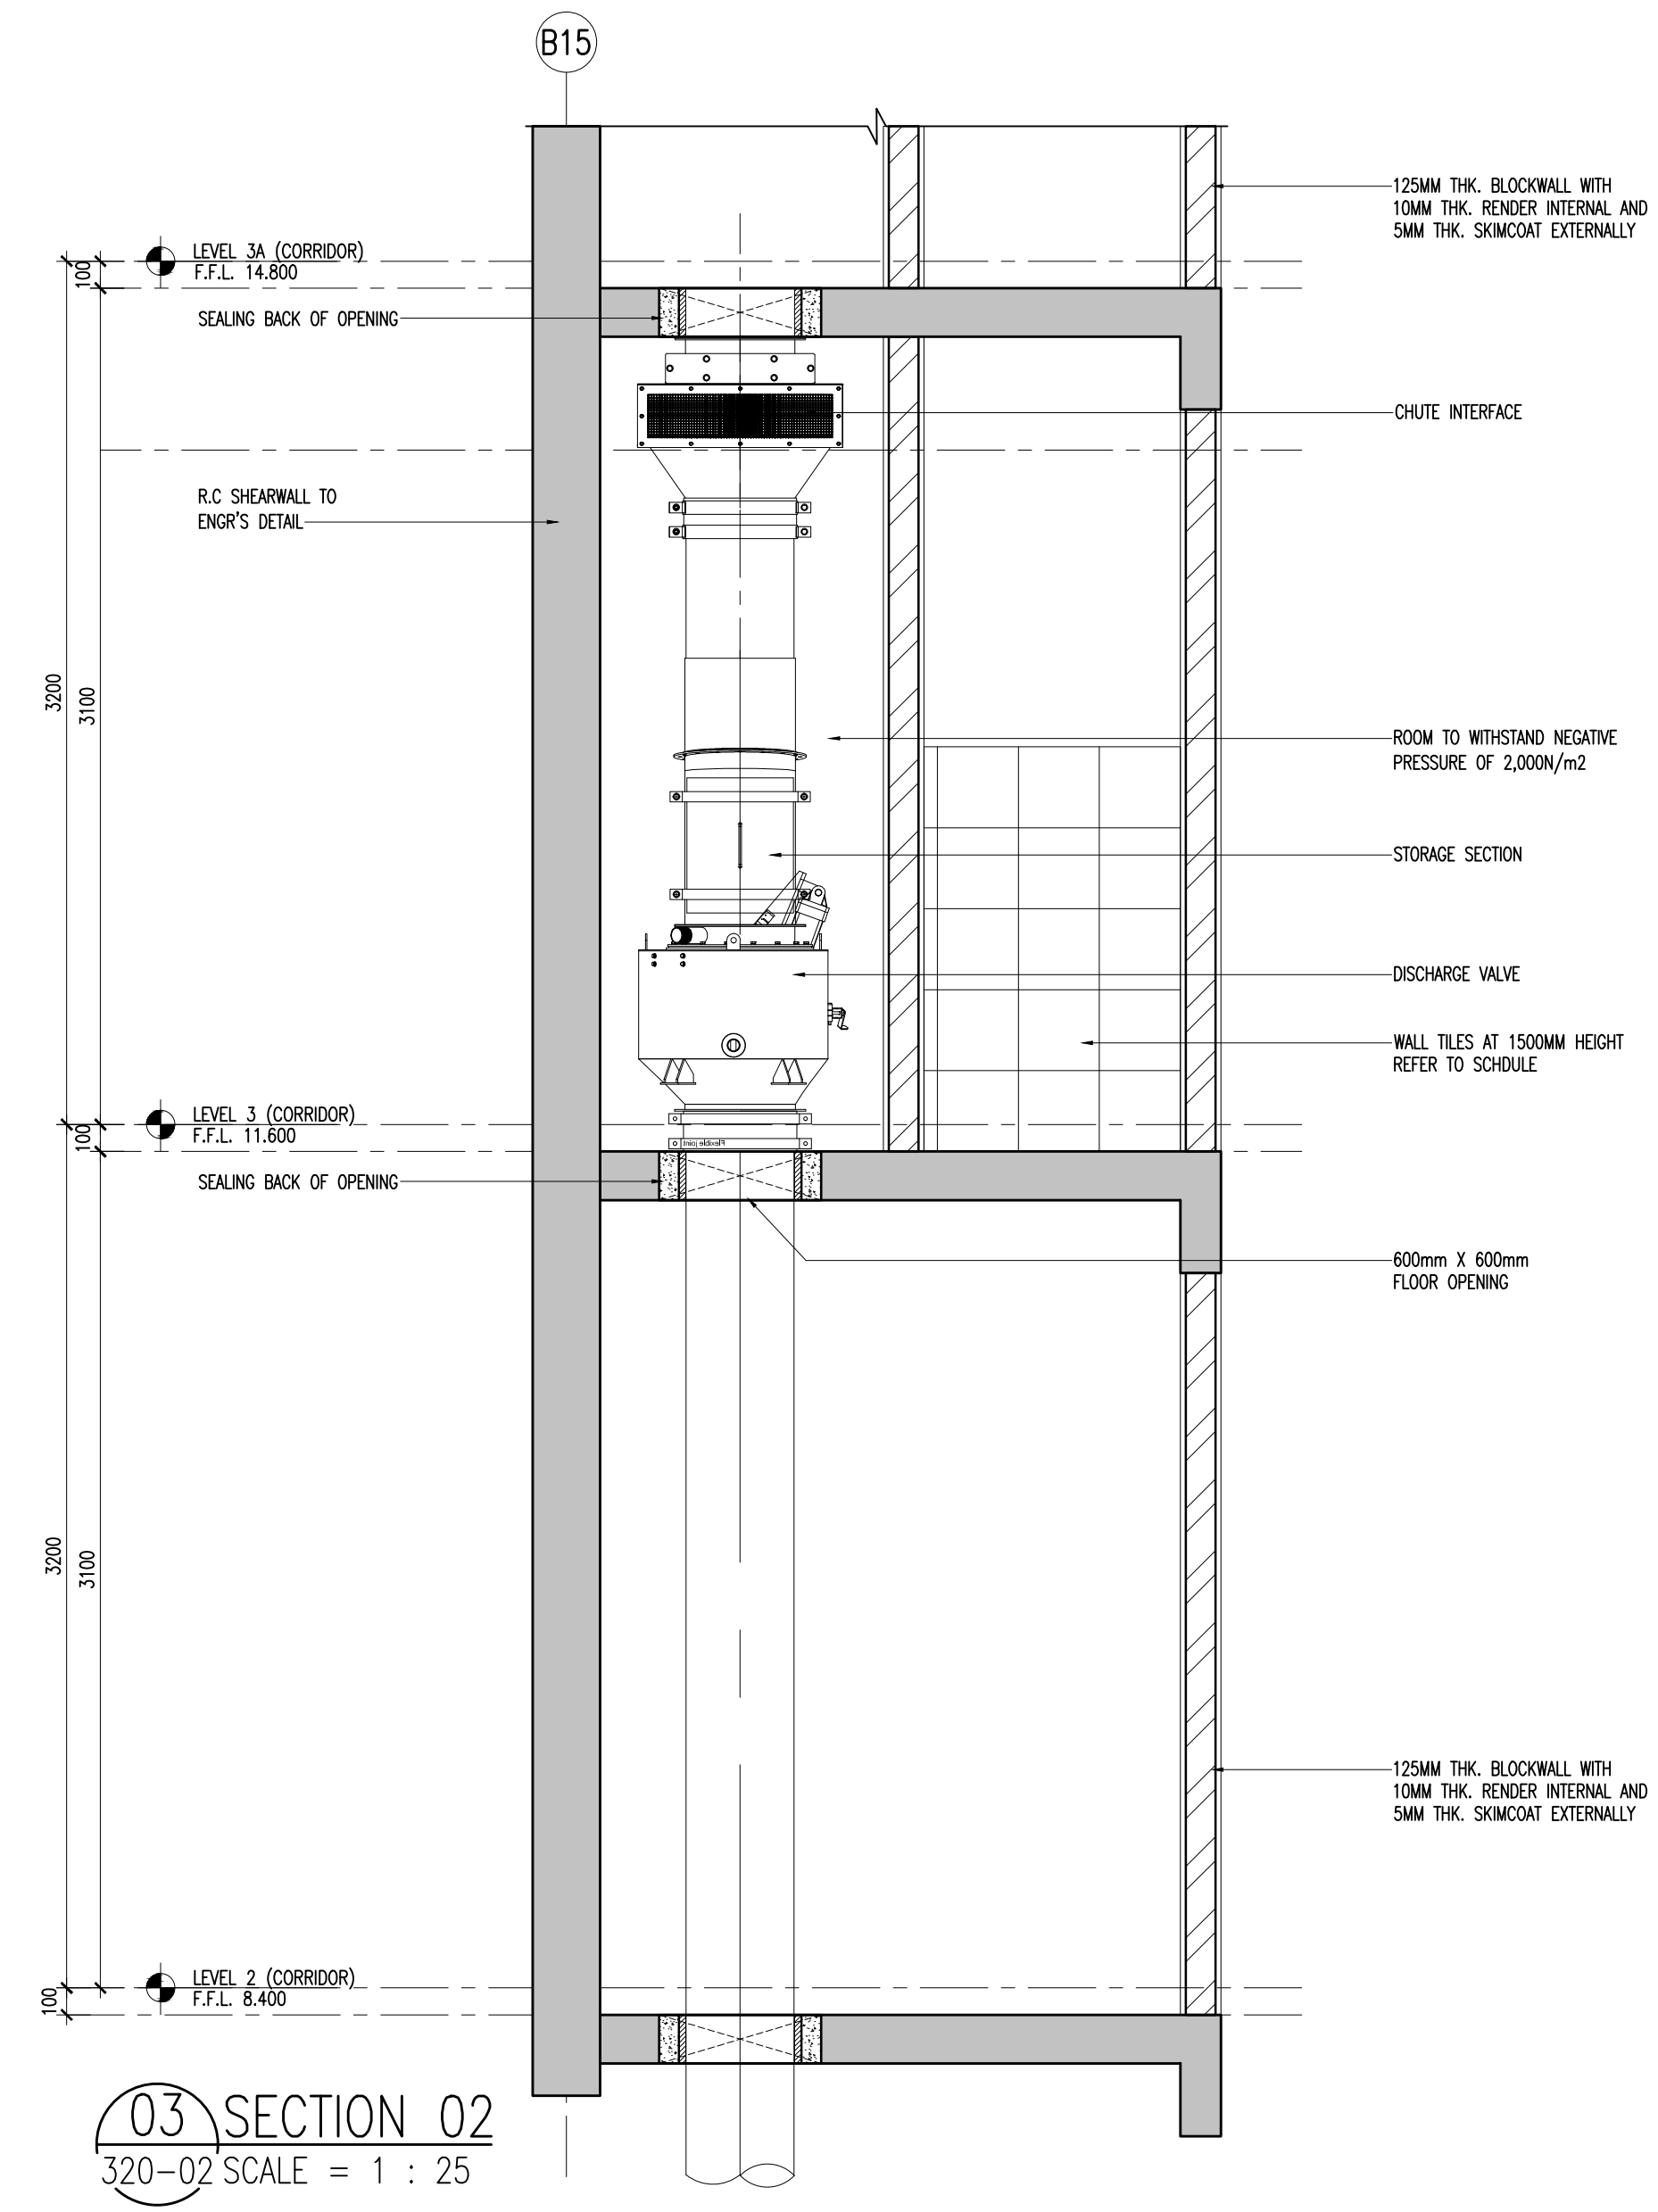


LEGEND	
–	DESCRIPTION
mv	Mechanical ventilation

Hak Cipta Terpelihara. Tidak dibenarkan mencetak mana-mana bahagian ilustrasi dalam apa jua bentuk dan dengan apa cara pun samada secara elektronik, mencetak, mekanik, rakaman atau cara lain sebelum mendapat kebenaran bertulis dari **BHYEW ARCHITECTS SDN. BHD.**

BIL.	DATE	REVISION	DRAWN BY

BIL.	DATE	REVISION	DRAWN BY
------	------	----------	----------

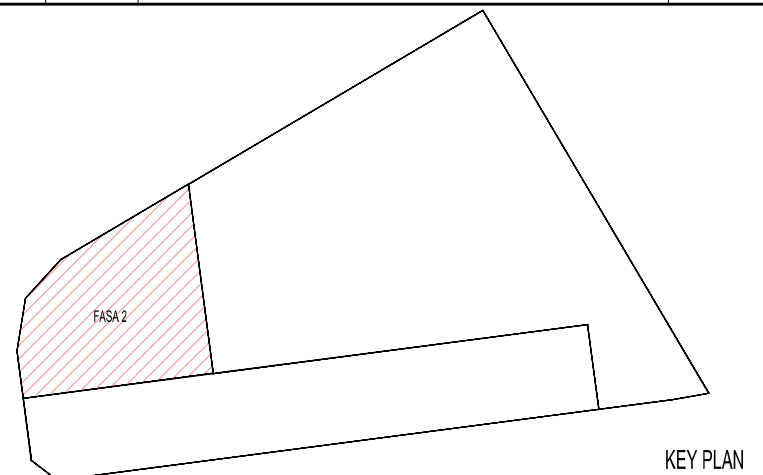

PROJEK :
CADANGAN PEMBANGUNAN (FASA 2) YANG MENGANJUNGKI:-
2 BLOK PANGSAPURI PERKHIDMATAN 40 TINGKAT (491 UNIT)
DENGAN TEMPAT LETAK KENDERAAN

DI ATAS LOT 21609 (SEBAHAGIAN LOT 21135 SEBELUM INI),
JALAN CASSIA BARAT 2, MUKIM 13,
SEBERANG PERAI SELATAN, PULAU PINANG

UNTUK : TETUAN PARAMOUNT PROPERTY (PW) SDN. BHD

PEMILIK DAN PEMAJU :

ALAMAT : PARAMOUNT PROPERTY (PW) SDN. BHD
WISMA PARAMOUNT, 1A (1ST FLOOR), LORONG BLM 1/1,
BANDAR LAGUNA MERBOK, 08000 SUNGAI PETANI, KEDAH

NO. TEL : 604 - 441 9191 FAX : 604 - 441 9090

ARKITEK / SAKSI : **BH** YEWE ARCHITECT (SP/Y61)
15TH FLOOR, MENARA AMMETLIFE
NO.1, JALAN LUMUT, 50400 KUALA LUMPUR
TEL: (03) 4043-1346 FAX: (03) 4043-1349
EMAIL: ybhw@nrasb.com.my

TENDER DRAWING
OCTOBER 2017

LUKSAN : DISCHARGE VALVE ROOM C/W
LOAD STATION DETAIL
3RD FLOOR PLAN
SECTION 01&02

SCALE: AS SHOWN		CAD NO.: 557_CD1-320-02			
DRAWN BY: SURRY		CHECKED BY: KHENG SHOON		DATE: OCT 2017	
PROJECT NO.	STATUS :	BLOCK :	DWG NO.	DWG NO.	REVISION
55714-2	CD	-	320	02	01