



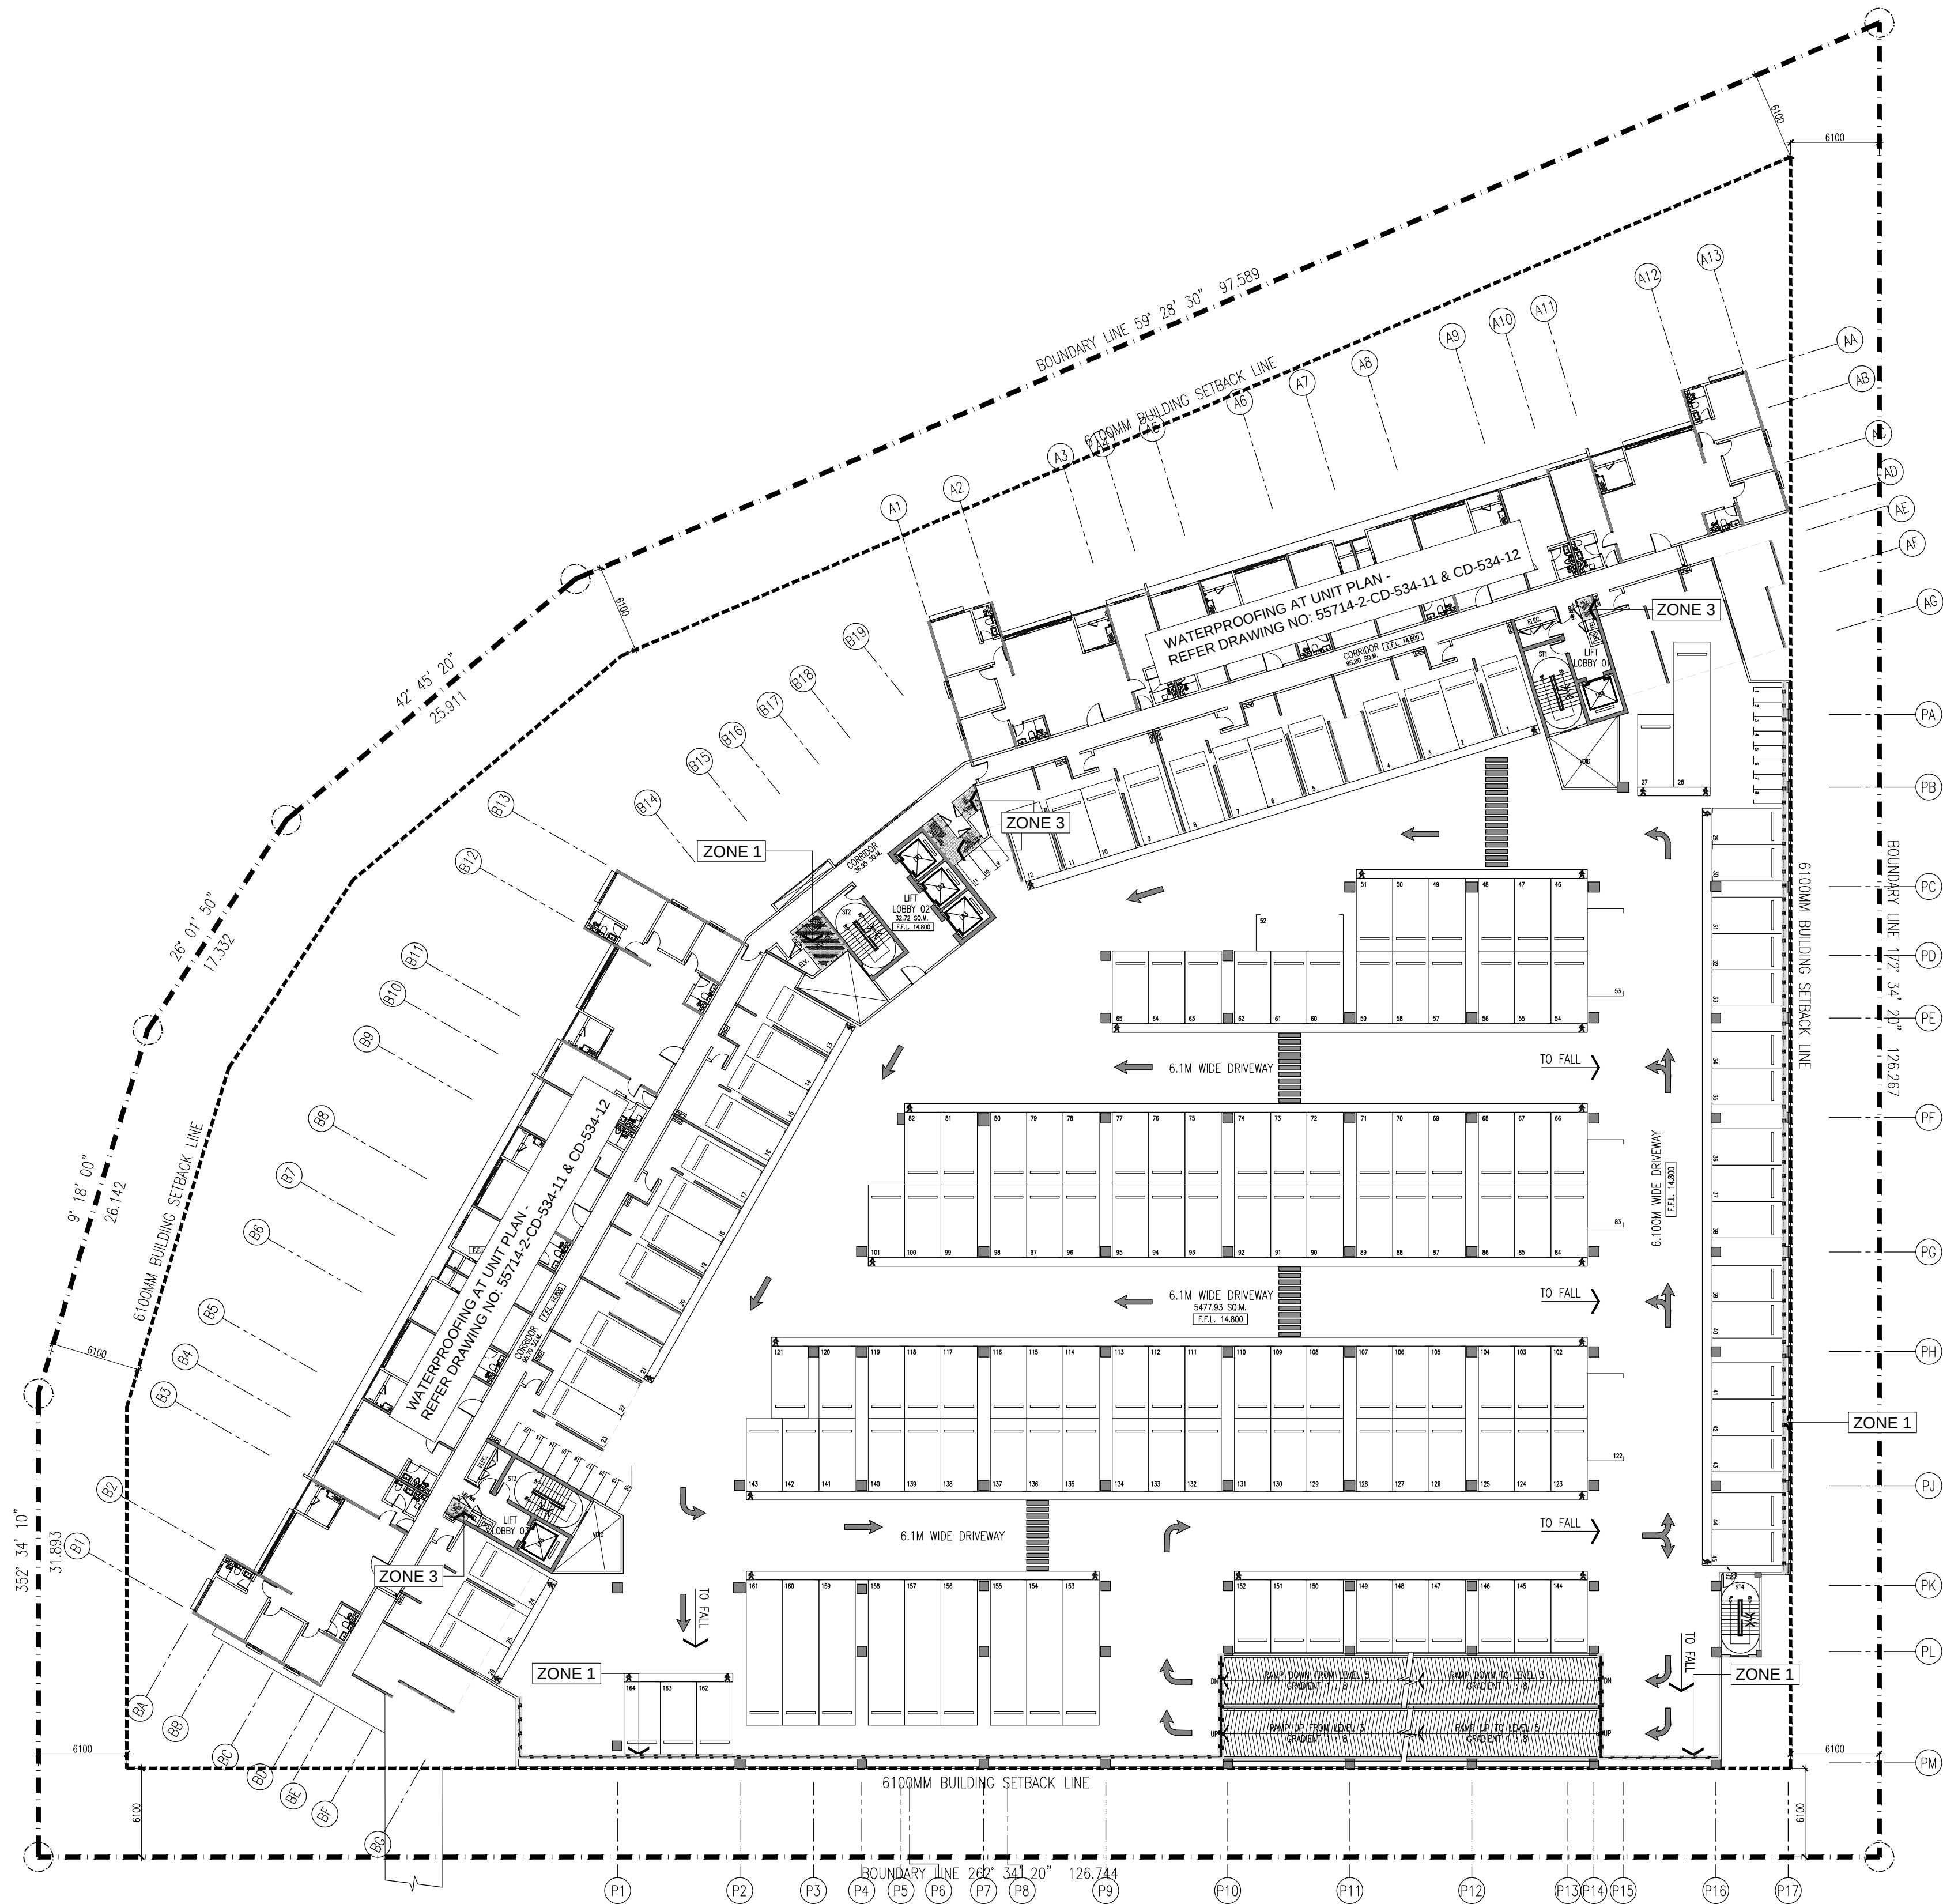

01 WATER PROOFING PLAN DEMARCATION - LEVEL 3A-6 & LEVEL 7
534-04 SCALE = 1 : 300

LEGEND	LOCATION	SPECIFICATION	PRODUCT
	ZONE 1 ABLUTION, TOILET, REFUSE, BULK WASTE PANTRY, WET KITCHEN, RAINWATER HARVESTING TANK, PUMP ROOM & FRP TANK ROOM	ONE COMPONENT, FLEXIBLE, FIBRE REINFORCED, CEMENTITIOUS WATERPROOFING MORTAR	SIKA PRIMER 11MM SIKALASTIC-1 KMY
	ZONE 2 WADING POOL, INFINITY POOL, DIP POOL, AQUA GYM & LIFT PIT	ONE COMPONENT, FLEXIBLE, FIBRE REINFORCED, CEMENTITIOUS WATERPROOFING MORTAR DOUBLE PROTECTION (ADMIXTURE)	SIKA PRIMER 11MM SIKALASTIC-1 KMY SIKA WT-220 PMY
	ZONE 3 SUCTION TANK, SPRINKLE TANK, WET RISER TANK, HOSE REEL TANK & BALANCING TANK	CEMENTITIOUS WATERPROOFING MORTAR SLURRY DOUBLE PROTECTION (ADMIXTURE)	SIKATOP SEAL 107 SIKA WT-220
	ZONE 4 GENSET ROOM	WATER BASED LOW VOC EPOXY COATING	SIKAFLOOR-2530 W LP
	ZONE 5 ROOF ABOVE TNB SUB-STATION	NON METALIC FLOOR HARDENER	SIKAFLOOR-3 QUARTZ-TOP
	ZONE 6 RC FLAT ROOF AT LEVEL 2, LEVEL 3, LEVEL 21, LEVEL 40, LEVEL LMR & LEVEL ROOF	FAST CURING SPRAY APPLIED POLYURETHANE	SIKALASTIC 901 SIKA FLOOR 161 HC
	ZONE 7 TERRACE GARDEN	ANTI-ROOT PVC FULLY BONDED SYSTEM	SIKA SARNAFIL G476-15 SIKA SARNAFIL S-FELT 300G/M2

Hak Cipta Terpelihara. Tidak dibenarkan mencetak mana-mana bahagian ilustrasi dalam apa jua bentuk dan dengan apa cara pun samada secara elektronik, mencetak, mekanik, rakaman atau cara lain sebelum mendapat kebenaran bertulis dari BHIYEW ARCHITECTS SDN. BHD.

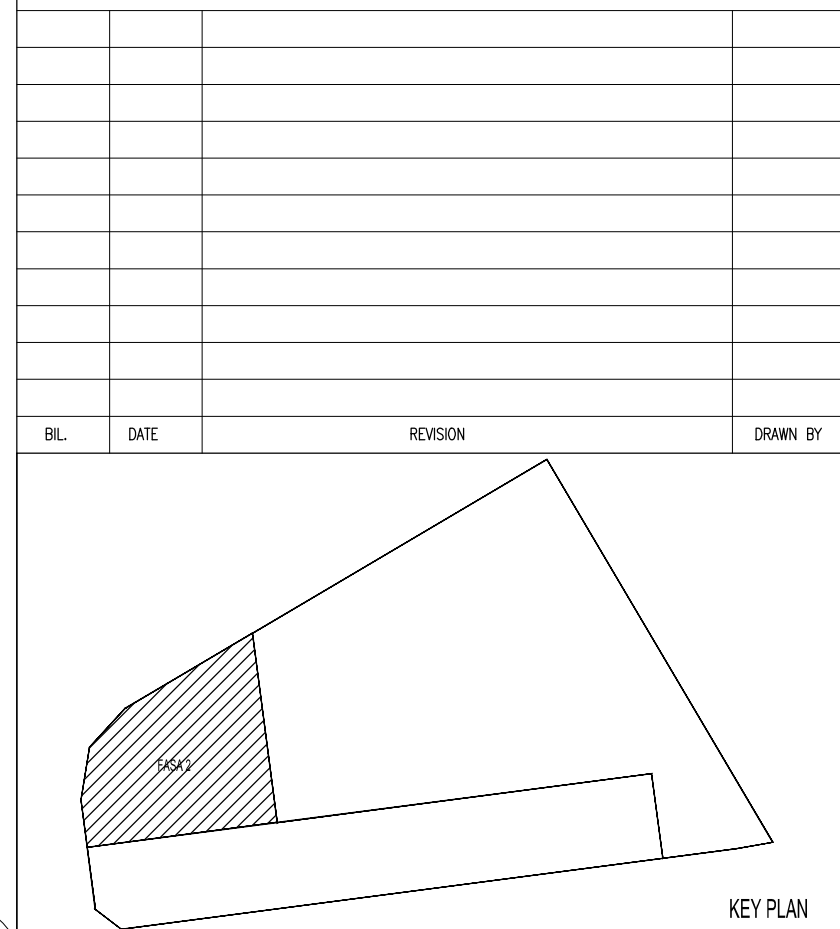

PROJEK :
CADANGAN PEMBANGUNAN (FASA 2) YANG MENGANDUNGI -
2/BLOK PANGSAPURI PERKIDHMATAN 40 TINGKAT (491 UNIT)
DENGAN TEMPAT LETAK KENDERAAN

DI ATAS LOT 21609 (SEBAGIAN LOT 21135 SEBELUM INI),
JALAN CASSIA BARAT 2, MUKIM 13,
SEBERANG PERAI SELATAN, PULAU PINANG

UNTUK : TETUAN PARAMOUNT PROPERTY (PW) SDN. BHD

PEMILIK DAN PEMAJU :
ALAMAT : PARAMOUNT PROPERTY (PW) SDN. BHD
WISMA PARAMOUNT, 1A (1ST FLOOR), LORONG BLM 1/L,
BANDAR LAGUNA MERBOK, 08000 SUNGAI PETANI, KEDAH
NO. TEL : 604 - 441 9191 FAX : 604 - 441 9090

ARKITEK / SAKSI :
BHIYEW
ARCHITECT (SP/Y61)
15TH FLOOR, MENARA AMMETLIFE
NO.1, JALAN LUMUT, 50400 KUALA LUMPUR
TEL: (03) 4043-1346 FAX: (03) 4043-1349
EMAIL: ybhwa@nrasb.com.my

TENDER DRAWING
OCTOBER 2017

LURUSAN :
**WATER PROOFING PLAN DEMARCATION
LEVEL 3A-6 & LEVEL 7 FLOOR PLAN**

SCALE: AS SHOWN	CAD NO.: 557_C01-534-04	DATE: OCT 2017
DRAWN BY: ZURA	CHECKED BY: KHENG SHOON	PROJECT NO.: 55714-2
STATUS : CD	BLOK : -	DWG NO.: 534
		DWG NO.: 04
		REVISION: 01