



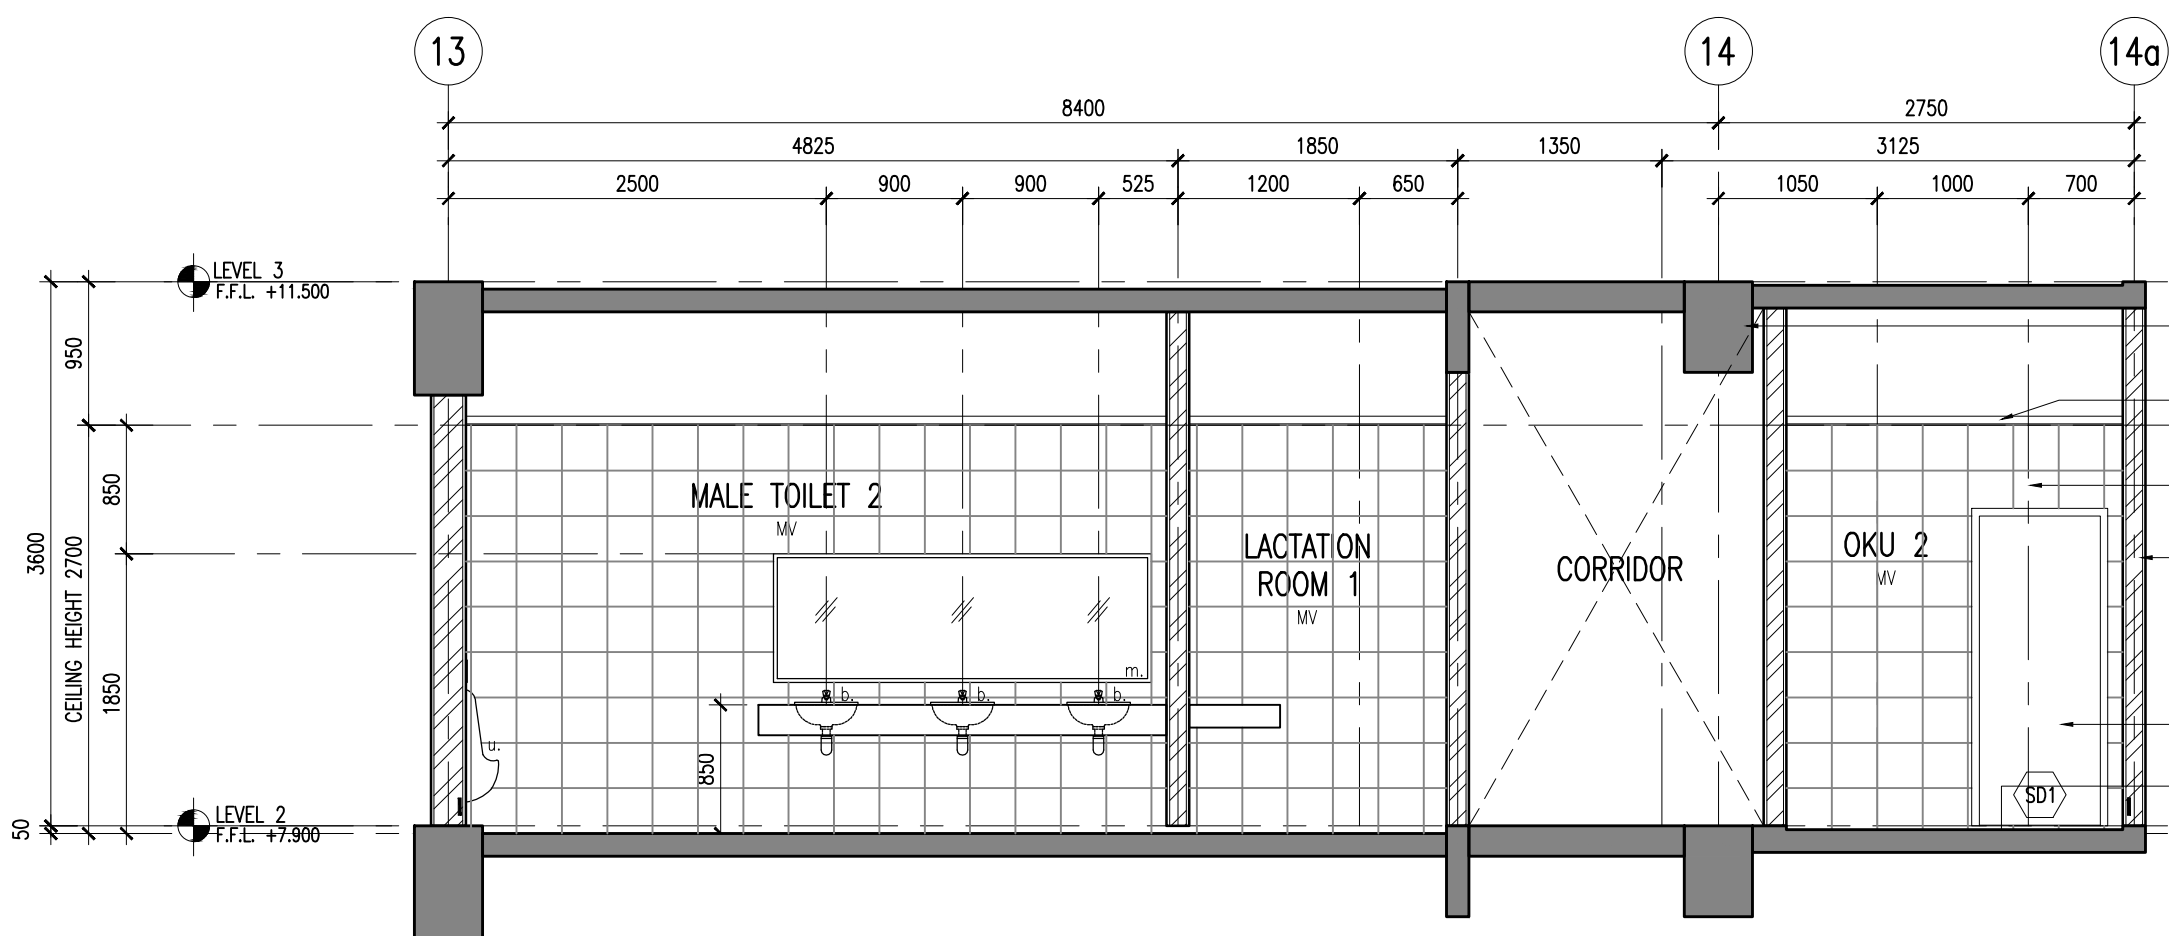


01 TYPICAL SECTION
531-06 SCALE = 1 : 50

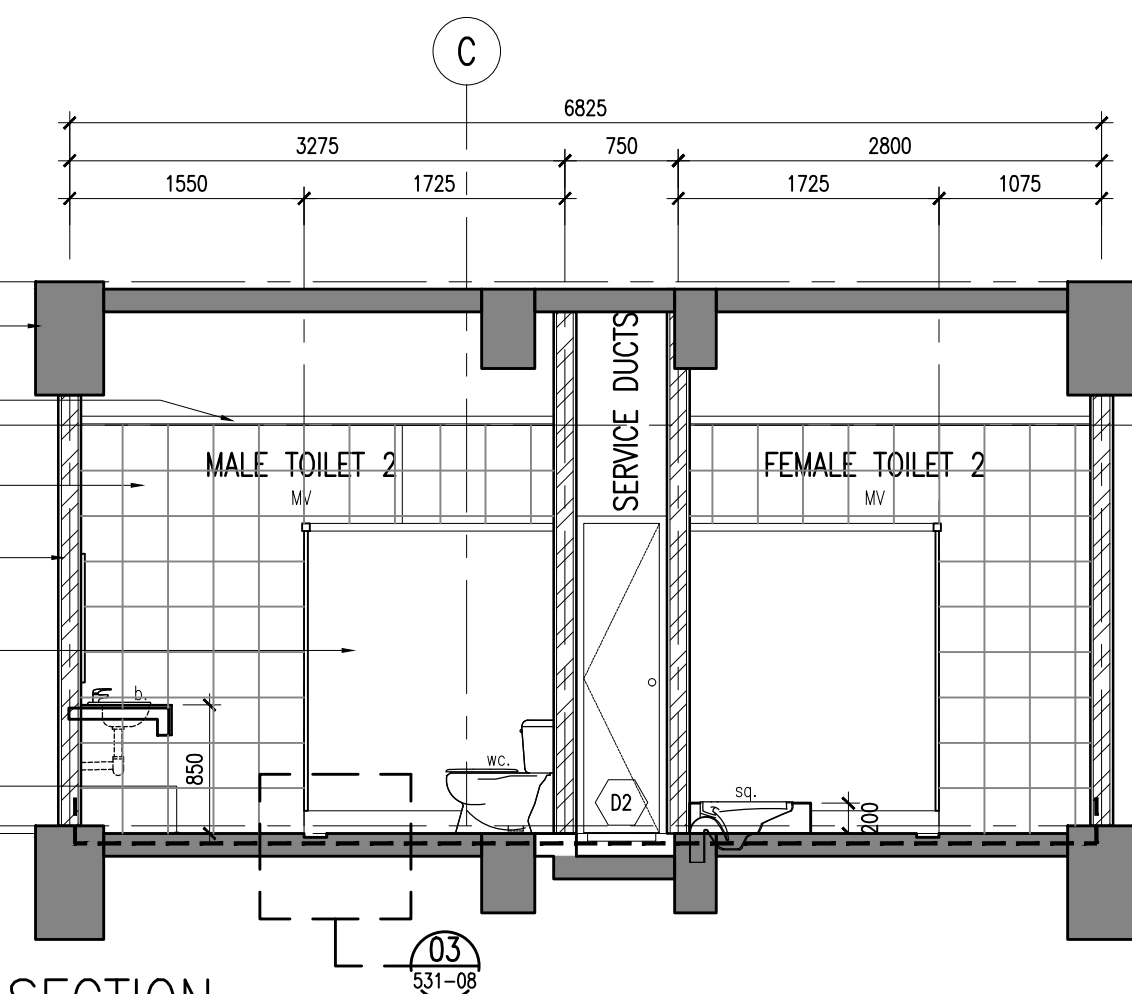

02 TYPICAL SECTION
531-06 SCALE = 1 : 50

LEGEND- SANITARY FITTINGS	
FITTINGS	DESCRIPTION
b.	Vanity counter top lavatory
ft.	Floor trap
hb.	Hand bidet
hd.	Hand dryer
m.	6mm thk. Mirror
top.	Toilet paper holder
sq.	Squatting
u.	Urinal
wc.	Water closet

LEGEND	
-	DESCRIPTION
mv	Mechanical ventilation

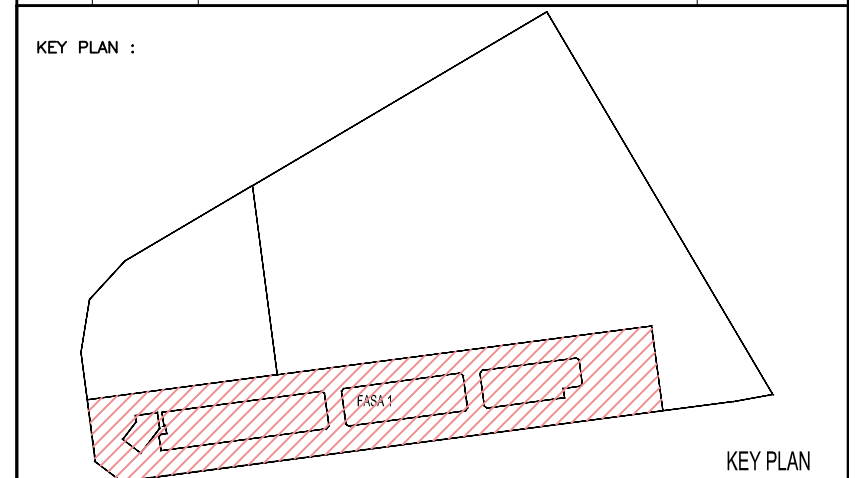

PROJECT TITLE :
CADANGAN MEMBINA PEMBANGUNAN BERCAKUP DI ATAS LOT 21135,
PERSIARAN CASSIA BARAT 3, MUKIM 13, SEBERANG PERAI SELATAN,
PULAU PINANG YANG MENDUNGKI:-

FASA 1
A. 2 BLOK PANGSAPURI PERKHIDMATAN 18 TINGKAT (612 UNIT)
B. KEDAI PEJABAT 3 TINGKAT (196 UNIT)
C. 5 TINGKAT TEMPAT LETAK KENDERAAN

UNTUK : TETUAN PARAMOUNT PROPERTY (PW) SDN. BHD

LAND OWNER & BUILDING OWNER :

NAMA : MR. OOI HUN PENG
JAWATAN : KETUA PEGAWAI EKSEKUTIF
NO IC : 650619-02-5311
ALAMAT : PARAMOUNT PROPERTY (PW) SDN. BHD
WISMA PARAMOUNT, 1A (1ST FLOOR), LORONG BLM 3/1,
BANDAR LAGUNA MERBOK, 08000 SUNGAI PETANI, KEDAH
NO. TEL : 604 - 441 9191 FAX : 604 - 441 9090

KITCHEN SPECIALIST :

QS CONSULTANT :

M&E CONSULTANT :
PERUNDING P.L.A.
Consulting Mechanical & Electrical Engineers.
8-01, WISMA PANTAI, TEL. NO. : (604) 3337990
JALAN WISMA PANTAI, FAX NO. : (604) 3317337
12200 BUTTERWORTH, PENANG. E-MAIL : project@pla-group.com

C&S CONSULTANT :
PERUNDING KELANA
CIVIL & STRUCTURAL ENGINEERS
Level 12, Unit 12(D), Wisma Boon Siew,
No.1, Penang Road, 10000 Penang.
Tel: 2622628, Fax: 2641618
(Company No. AS0232772-W)

DESIGN ARCHITECT :
ARCHITECTURE GROUP - STUDIO A
CPG CONSULTANTS PTE LTD
2388, THOMSON ROAD, #12-02 TOWER B
NOVENA SQUARE, SINGAPORE 307985
TEL : +65 6357 4468 FAX : +65 6357 4469

ARCHITECT :
BH YEW ARCHITECT (SP/Y61)
15TH FLOOR, BANGUNAN AMMETLIFE
NO.1, JALAN LUMUT, 50400 KUALA LUMPUR
TEL: (03) 4043-1346 FAX: (03) 4043-1349
EMAIL: ybhwa@nrab.com.my

Ar. YEW BU HWA
ARKITEK
No. Pendaftaran LAMAA/Y61

Saya mengesahkan bahawa pelan-pelan yang dihandar adalah mengikut Undang-Undang Kecil Bangunan Seragam 1988 dan Undang-Undang Kecil Bangunan Seragam (gubahan) 2007 [UKBS2007] dan gubahan-pelana serta gubahan-pelana-pelana dan pelan-pelana pelana Persebaran Sebaran Perak. Saya mengesahkan bahawa kerja-kerja pembinaan dan dihandar adalah dengan perijinan saya. Saya mengesahkan dan mengikut bahawa pelan-pelan bangunan adalah setara dengan pelan kebenaran merancang yang dihandar dan akan mematuhi ulisan serta syarat-syarat jalan leluasa.


TENDER DRAWING

NOVEMBER 2016


LUKSIK :

TOILET 2 DETAIL- LEVEL 2 & 3
TOILET FLOOR PLAN
TYPICAL SECTION


SCALE: AS SHOWN	QAD NO: 557-001-531-06	DATE: NOVEMBER 2016
DRAWN BY: JANICE	CHECKED BY: JANICE	DISCIPLINE: ARCH
ORIGINATOR ACRONYM BH YEW	PROJECT NO. 55714	DISCIPLINE ARCH
DWG STATUS CD	LOT -	REVISION 00

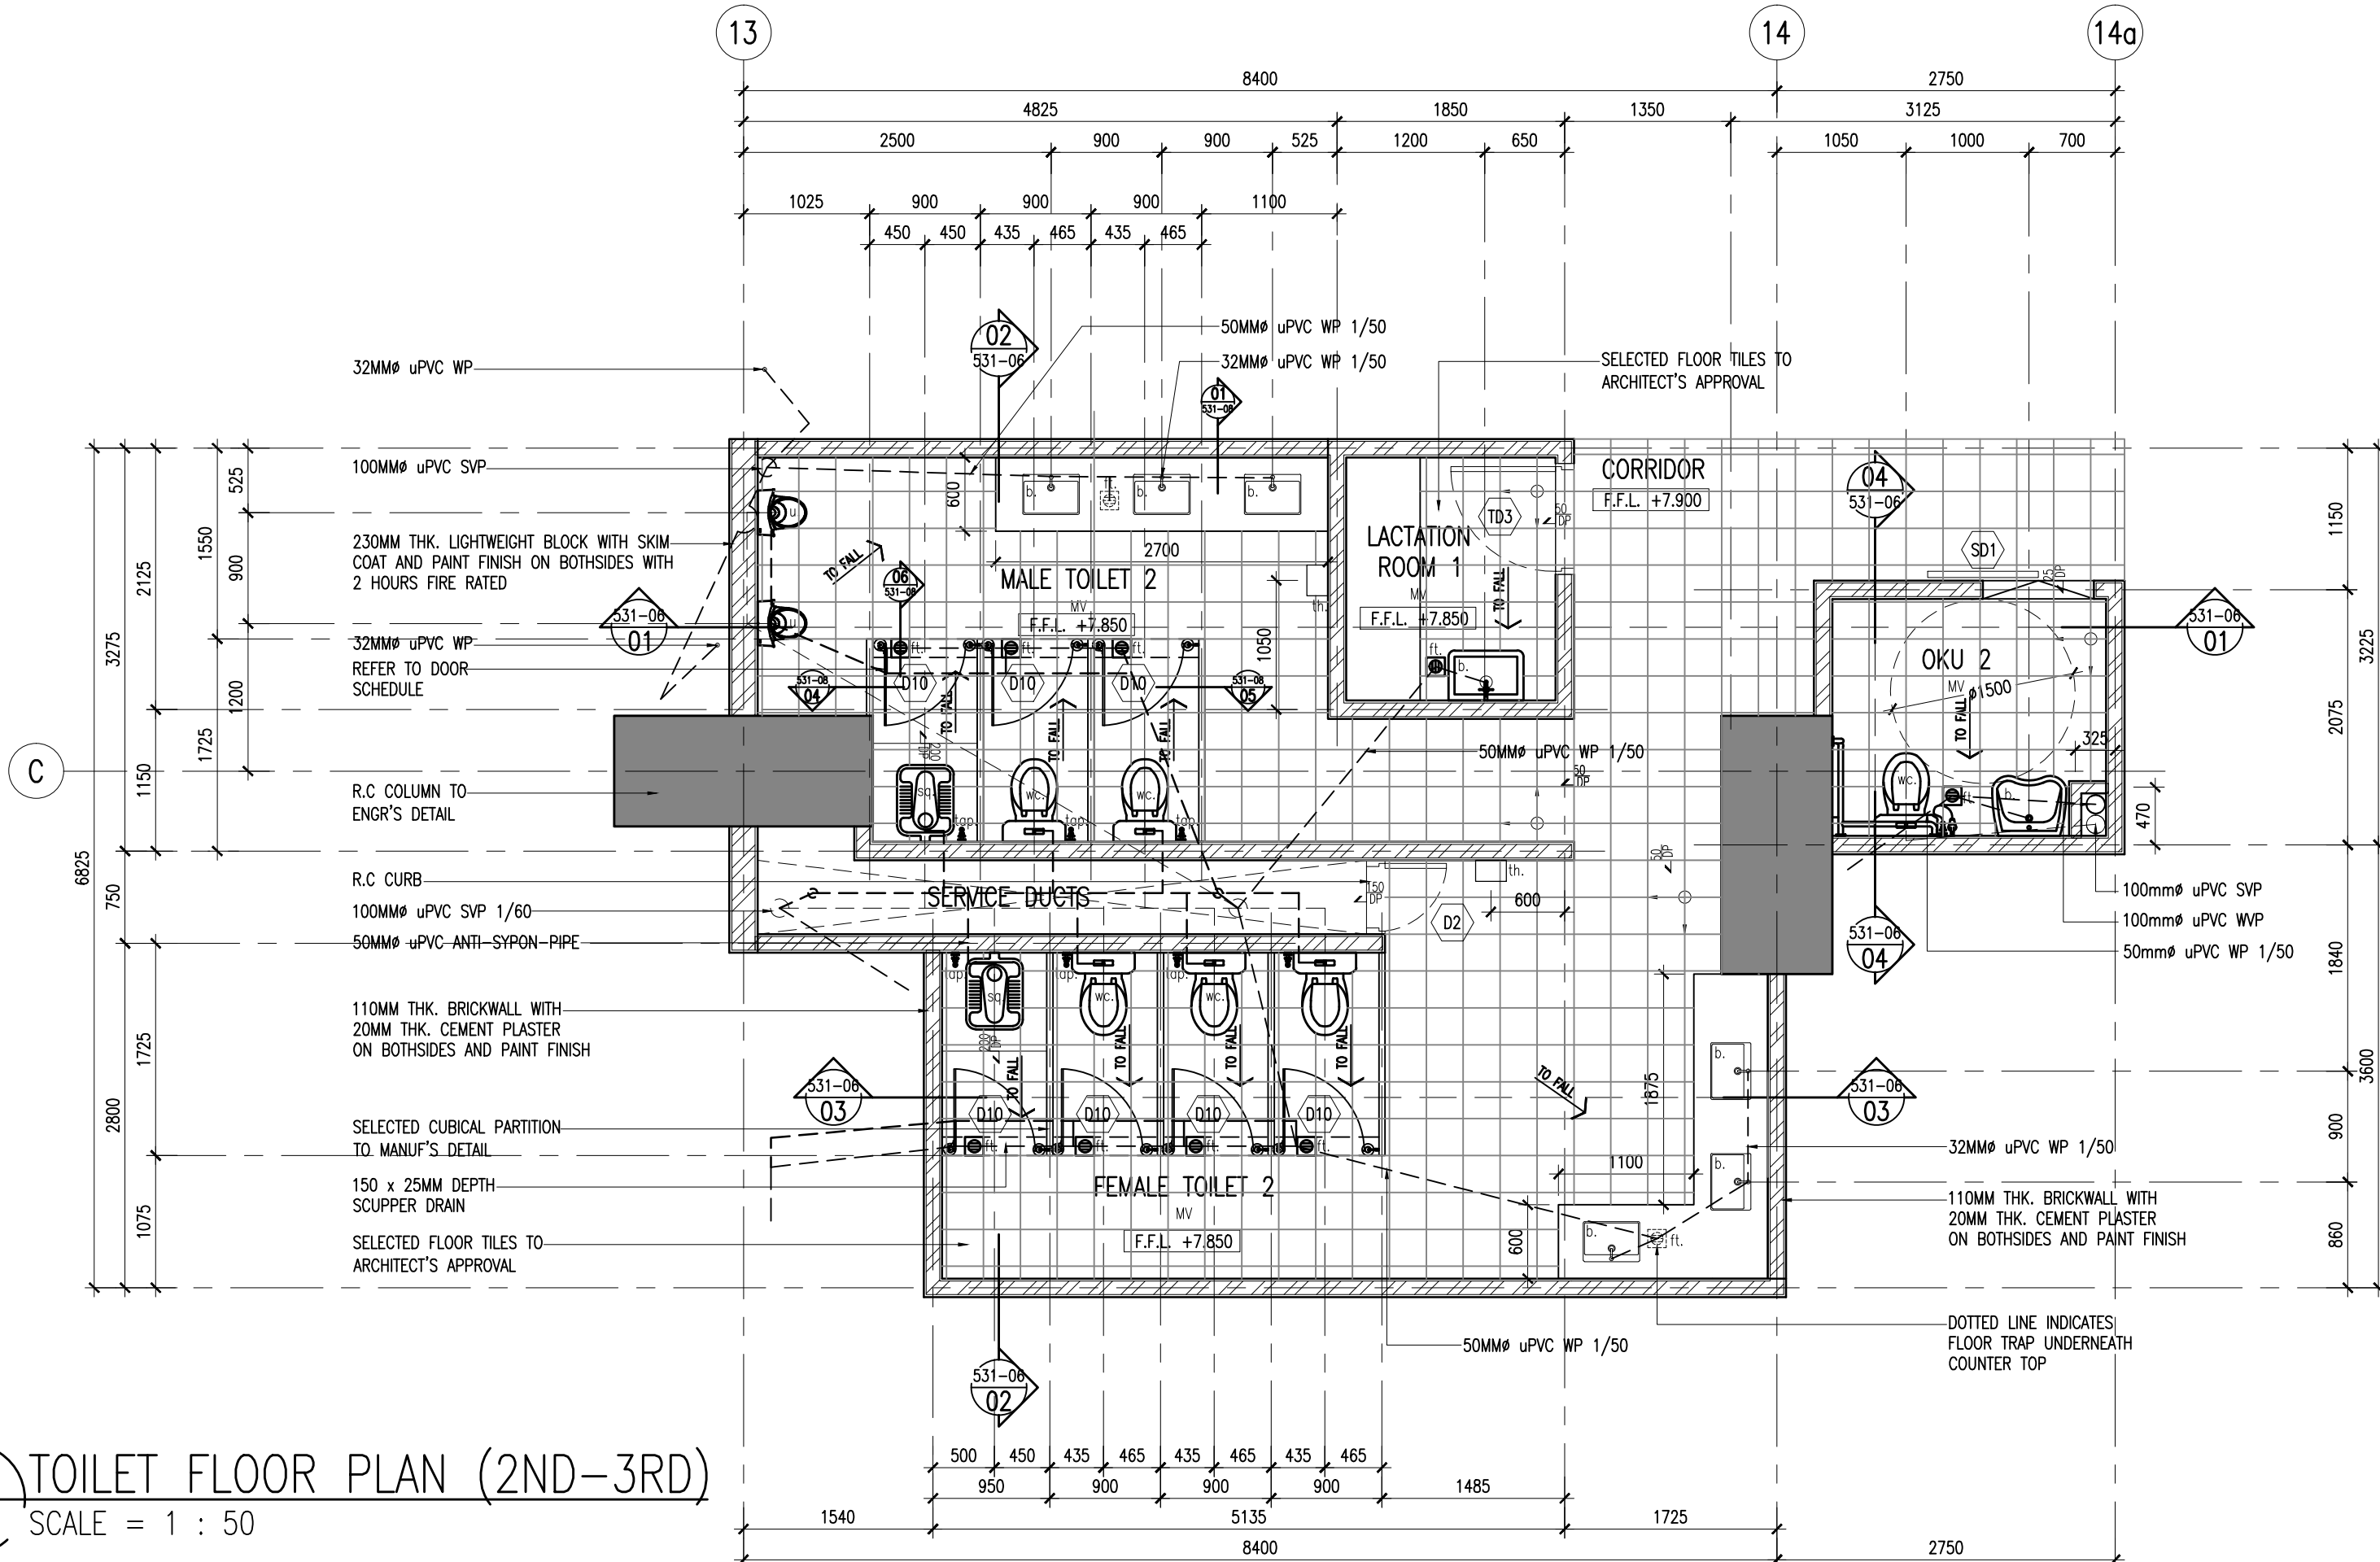

01 TOILET FLOOR PLAN (2ND-3RD)
100 SCALE = 1 : 50

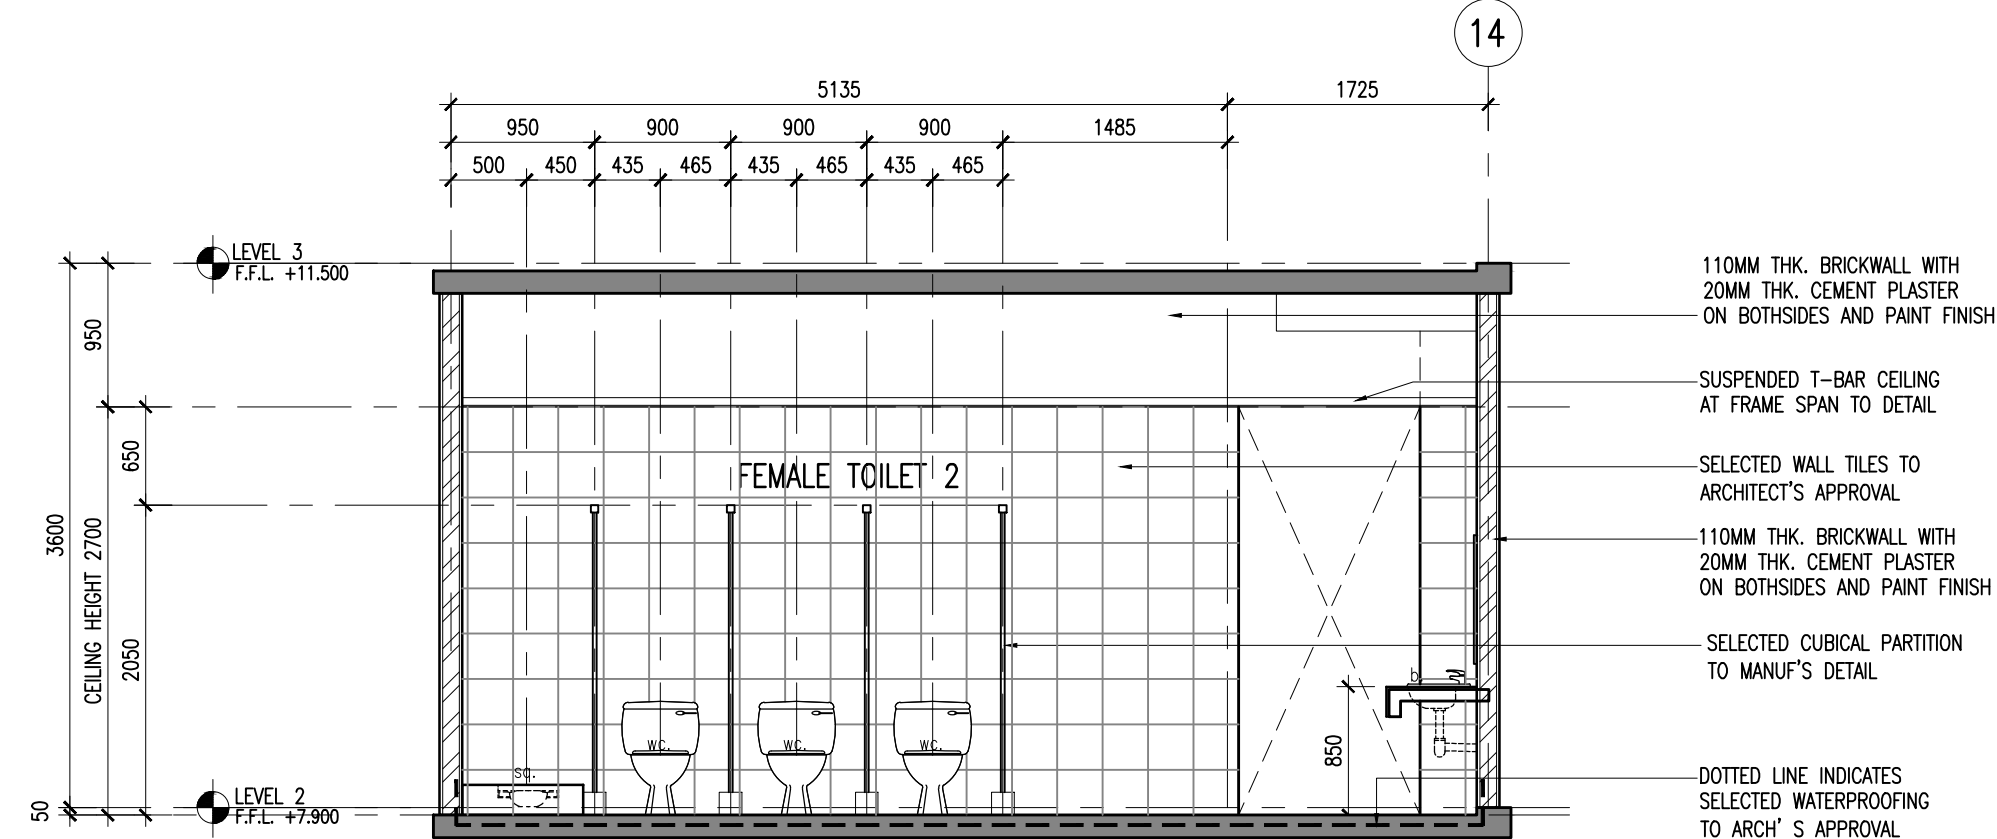

03 TYPICAL SECTION
531-06 SCALE = 1 : 50

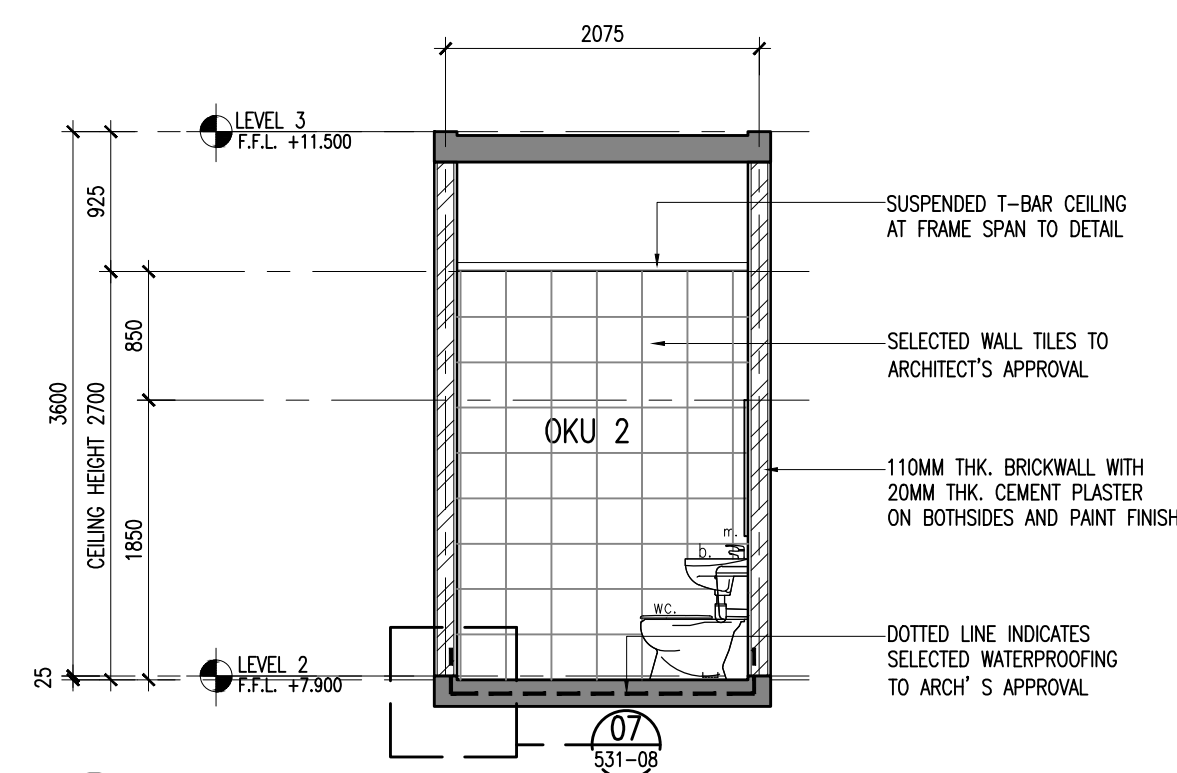

04 TYPICAL SECTION
531-06 SCALE = 1 : 50