



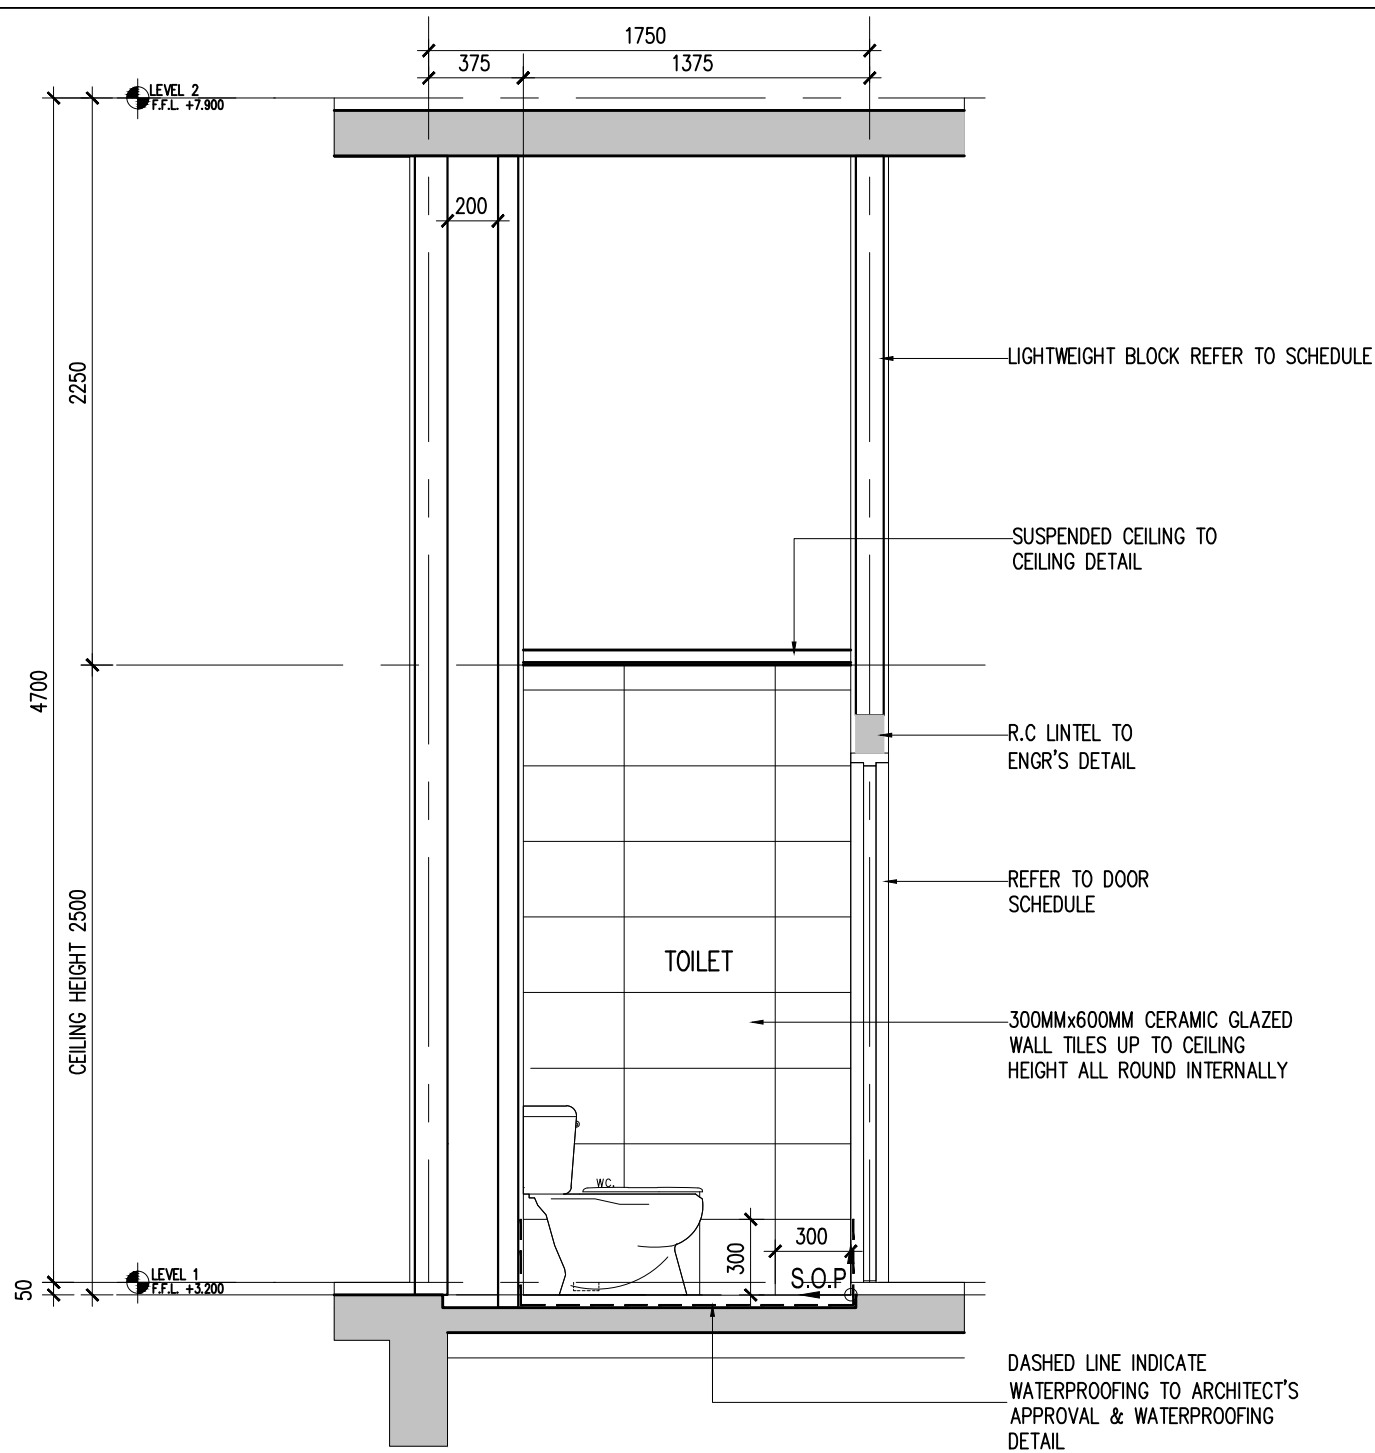


03 TOILET AT FIRE CONTROL ROOM - SECTION 02

531-05 SCALE = 1 : 30

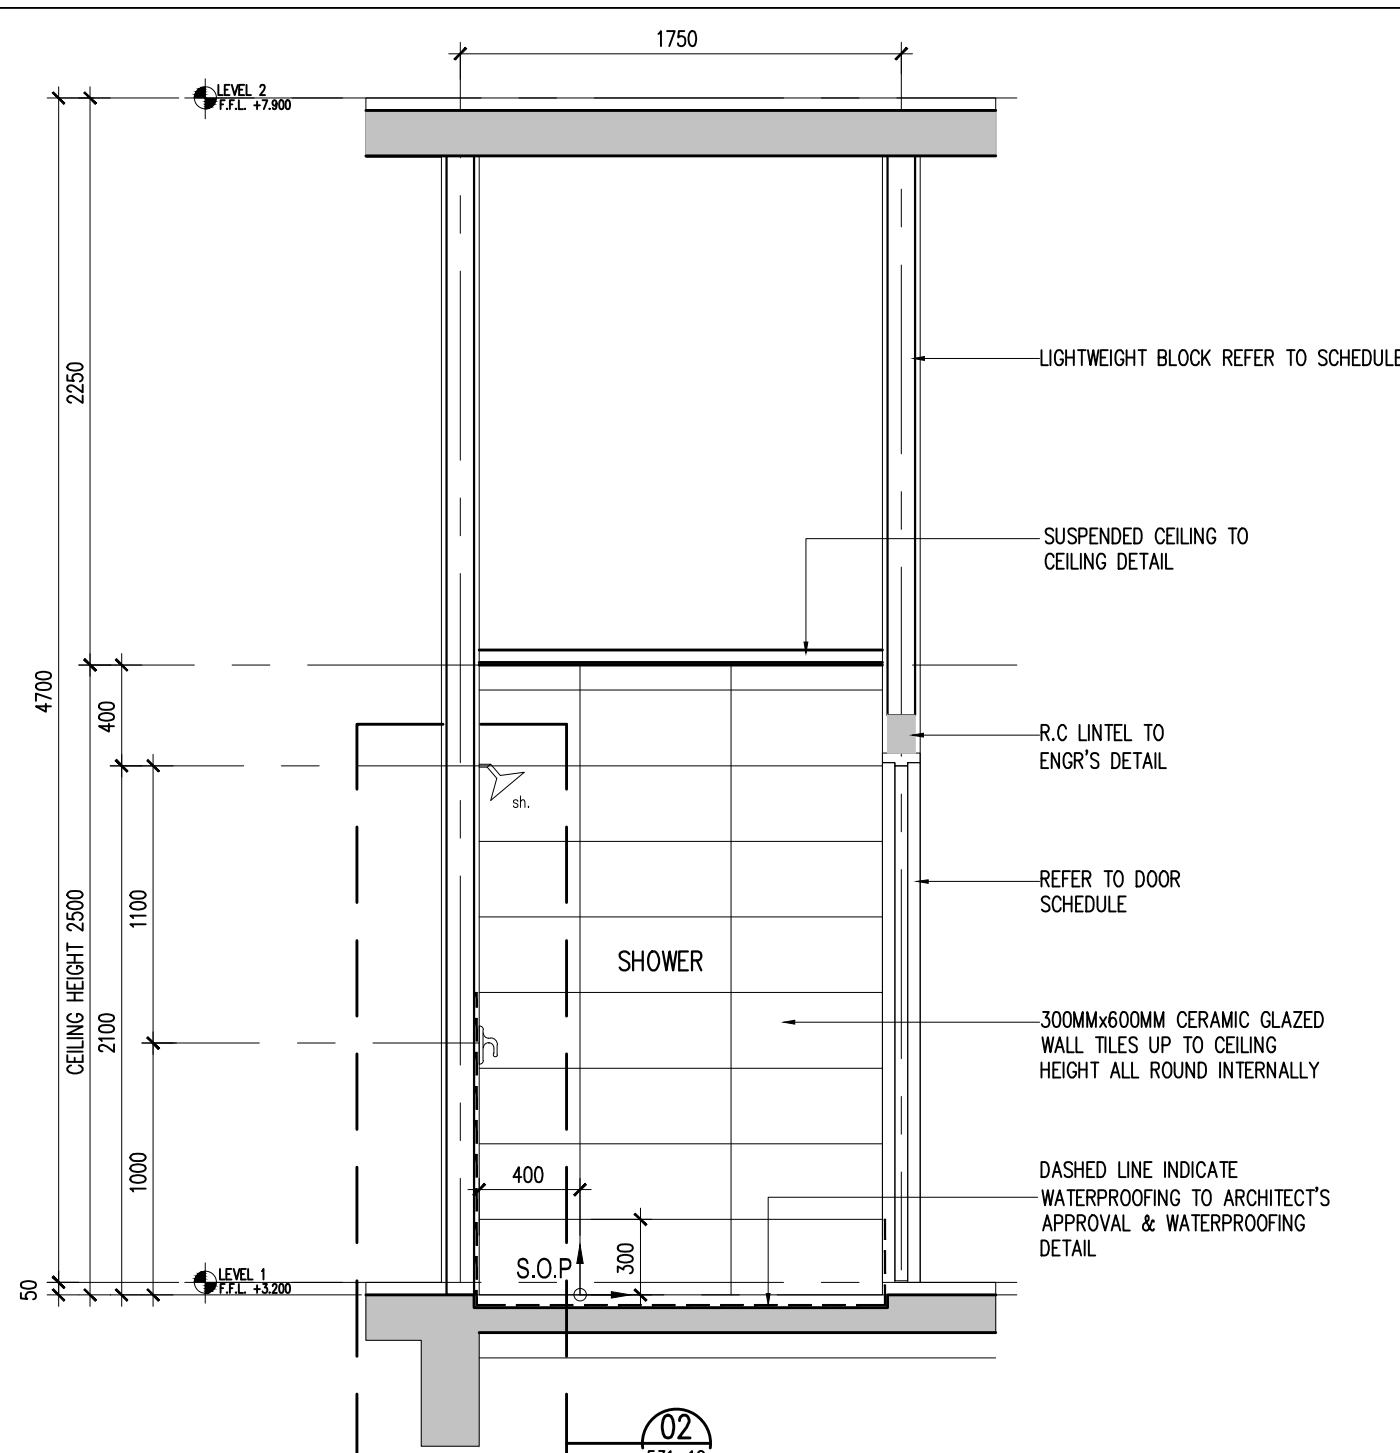


04 TOILET AT FIRE CONTROL ROOM - SECTION 03

531-05 SCALE = 1 : 30

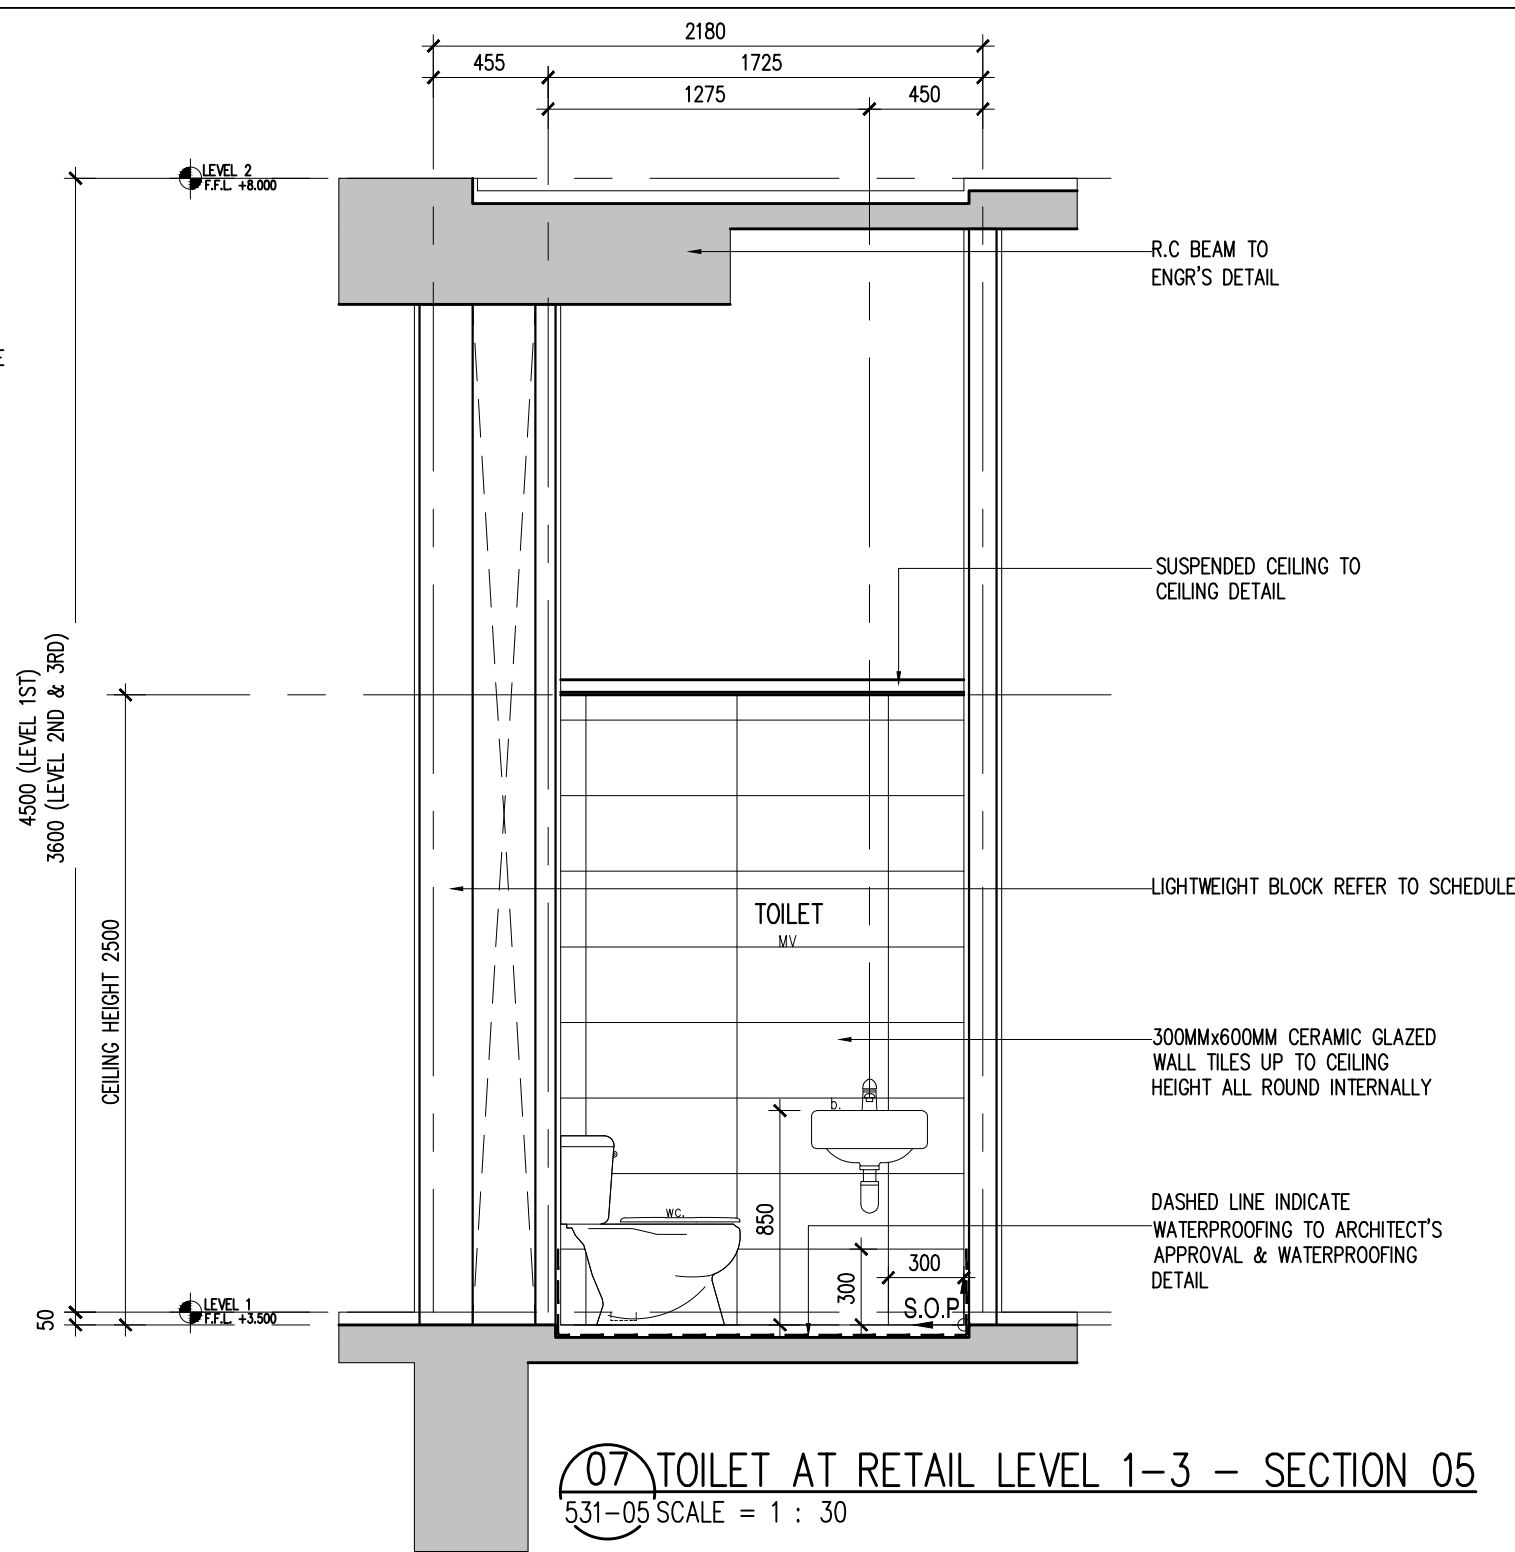

07 TOILET AT RETAIL LEVEL 1-3 - SECTION 05

531-05 SCALE = 1 : 30

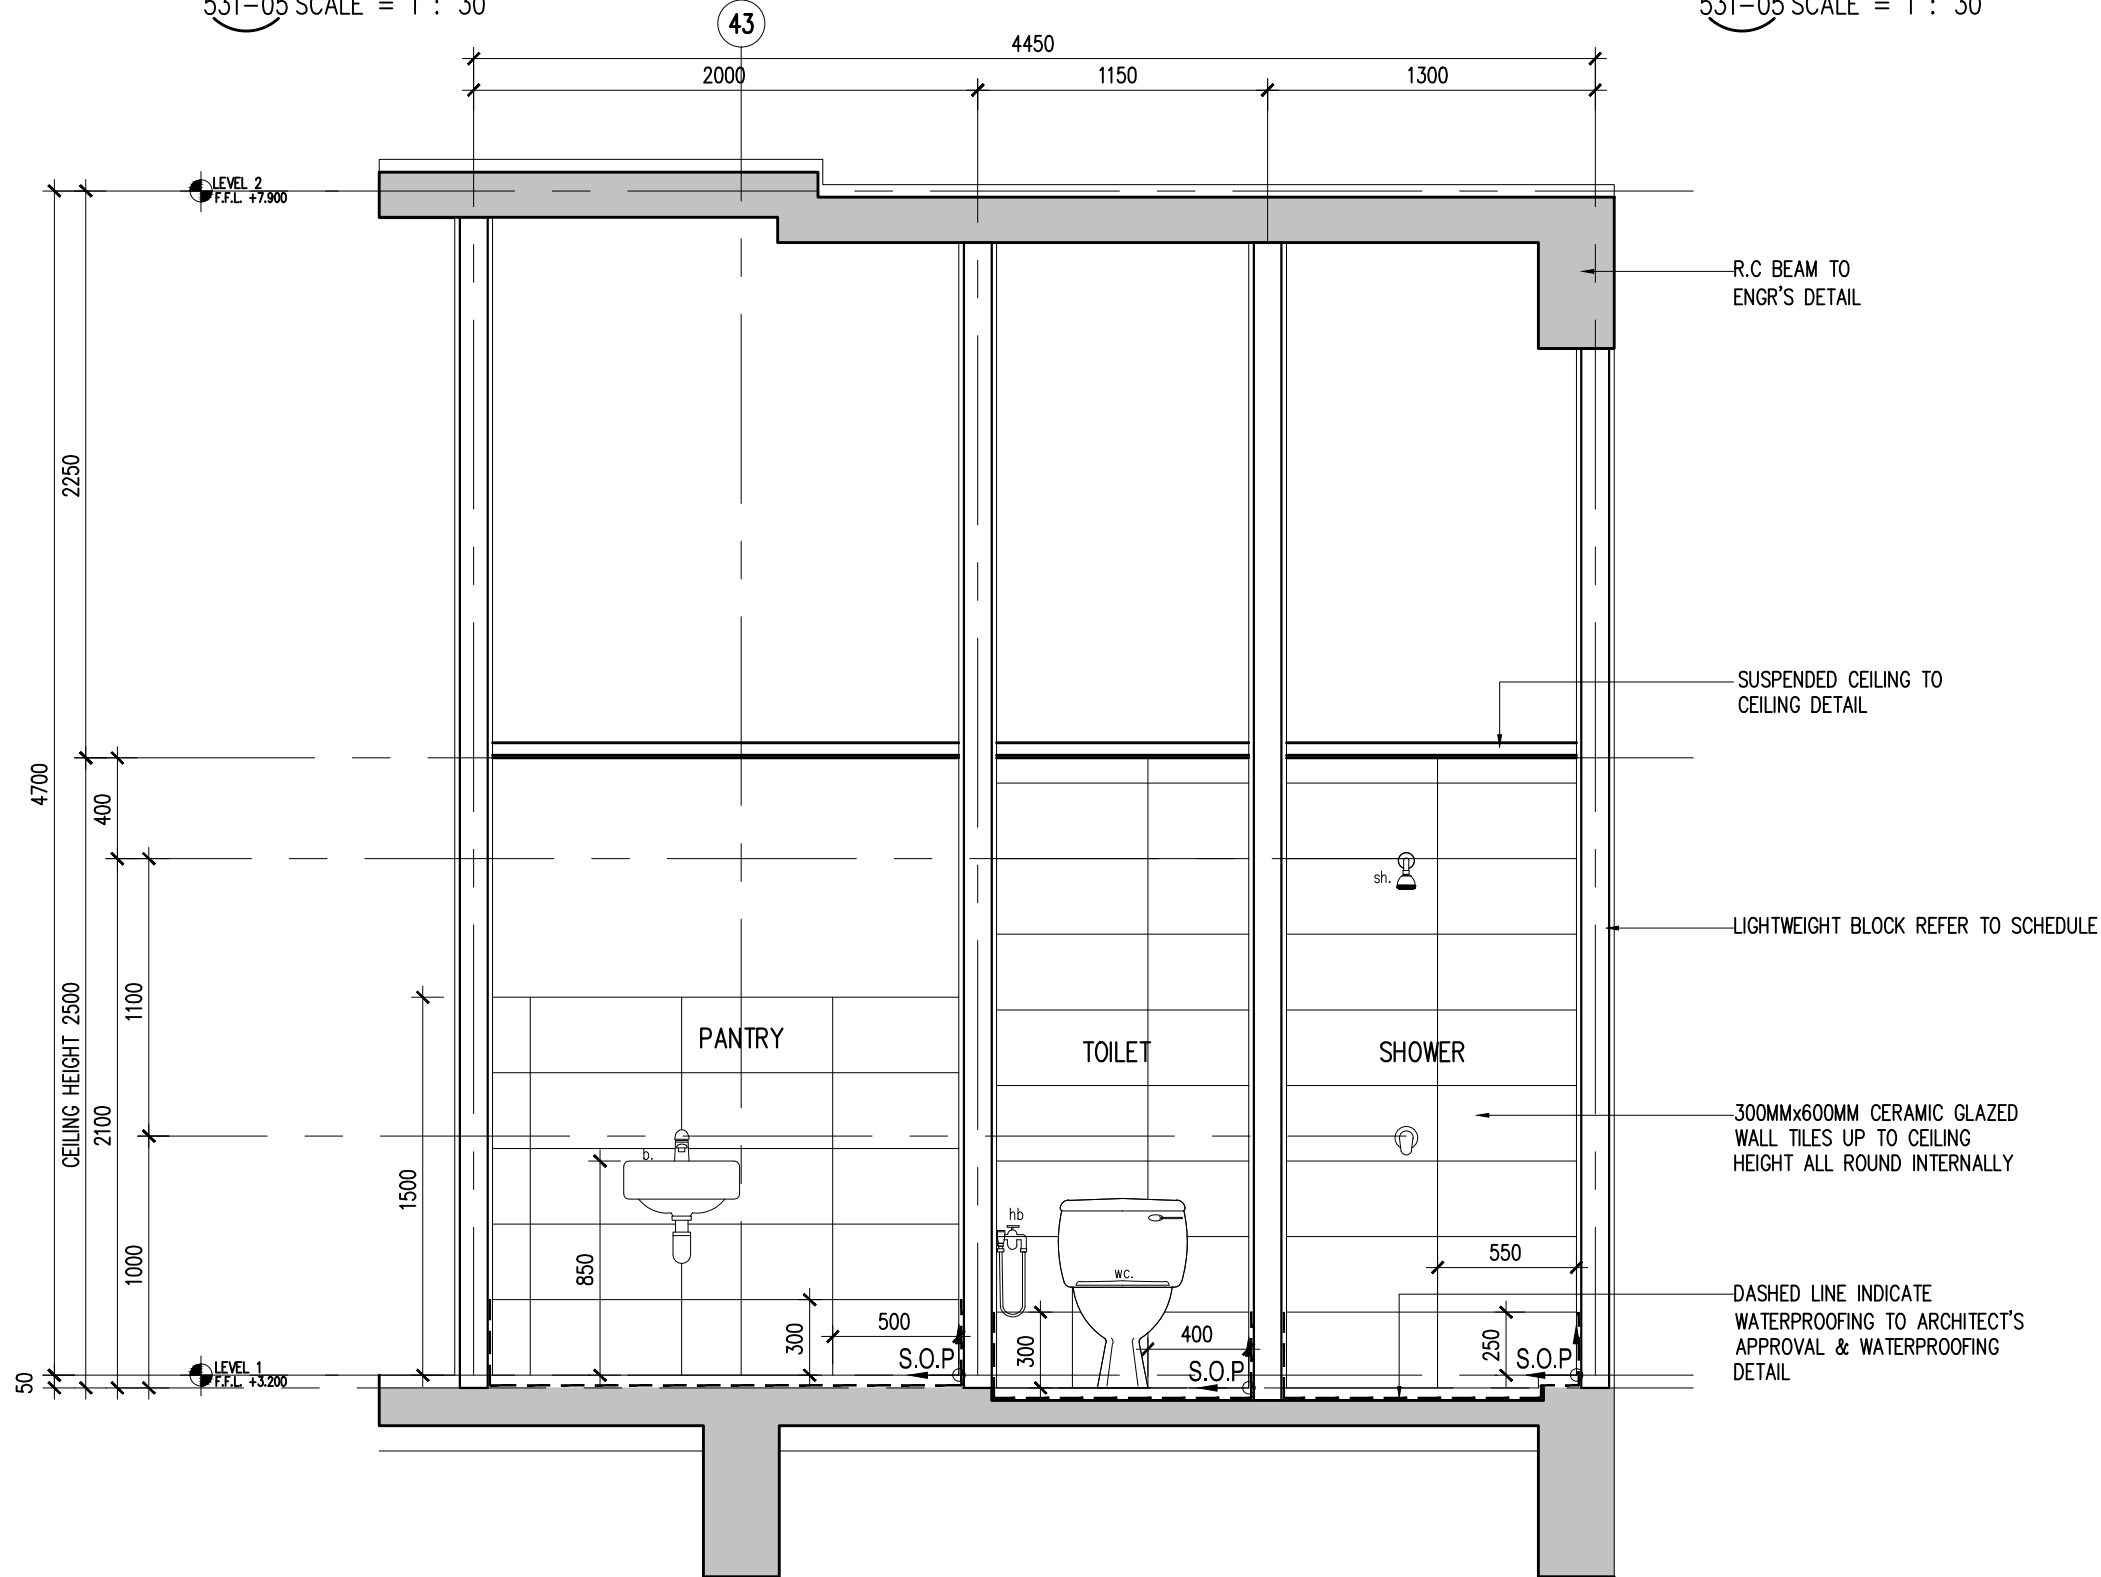


02 TOILET AT FIRE CONTROL ROOM - SECTION 01

531-05 SCALE = 1 : 30


LEGEND- SANITARY FITTINGS	
FITTINGS	DESCRIPTION
b.	Vanity counter top lavatory
ft.	Floor trap
hb.	Hand bidet
hd.	Hand dryer
m.	6mm thk. Mirror
top.	Toilet paper holder
sq.	Squatting
sh.	Shower
s.	Sink
u.	Urinal
wc.	Water closet

LEGEND	
SYMBOL	DESCRIPTION
mv	Mechanical ventilation

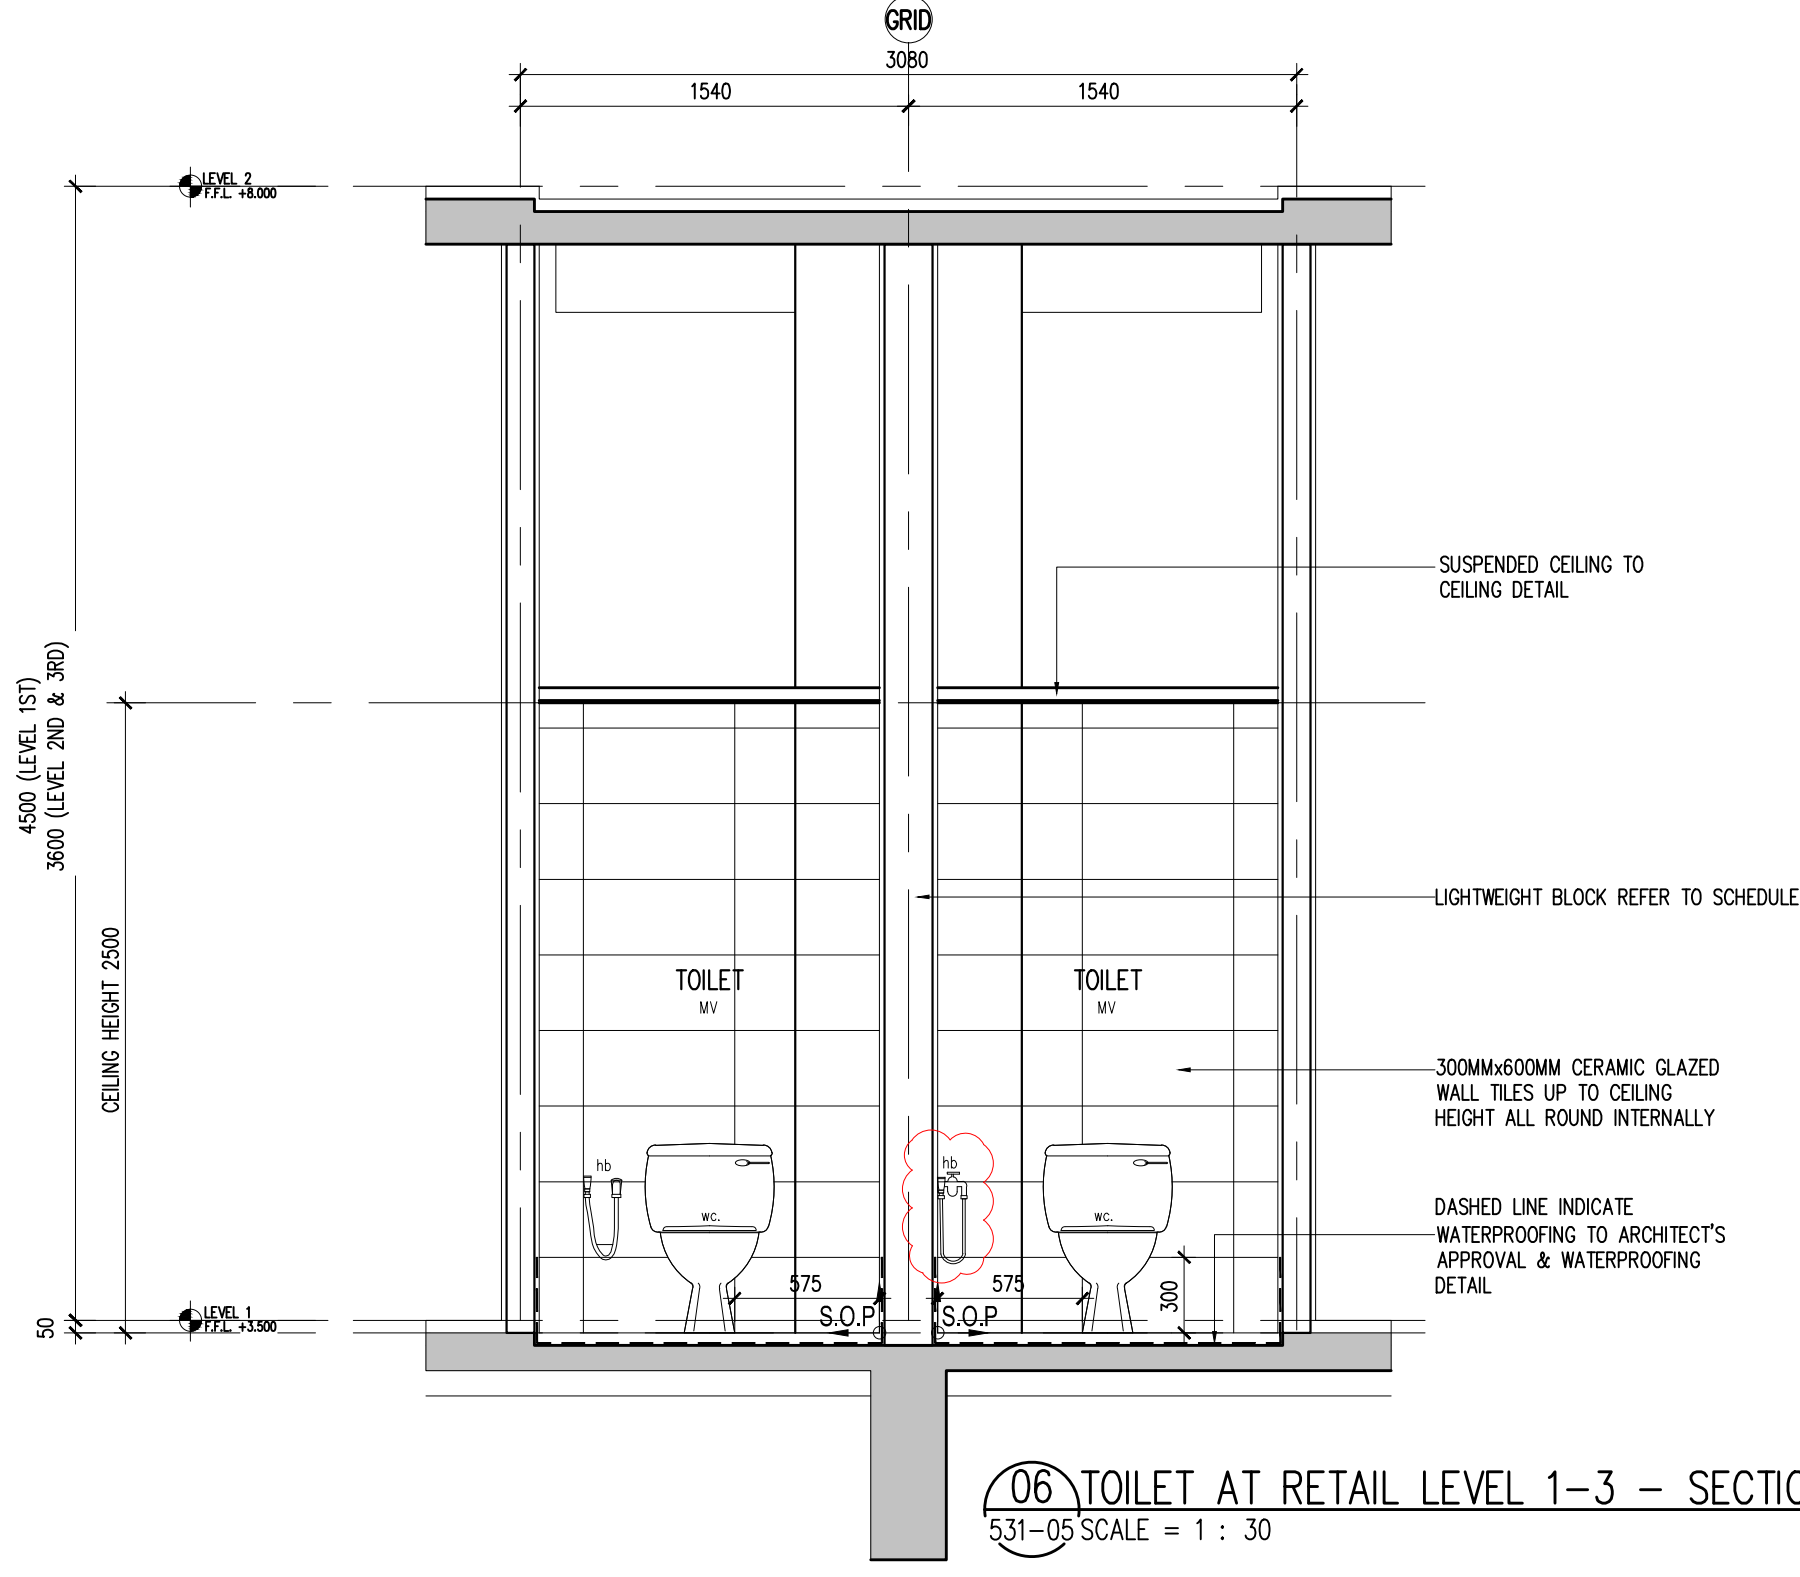

06 TOILET AT RETAIL LEVEL 1-3 - SECTION 04


531-05 SCALE = 1 : 30

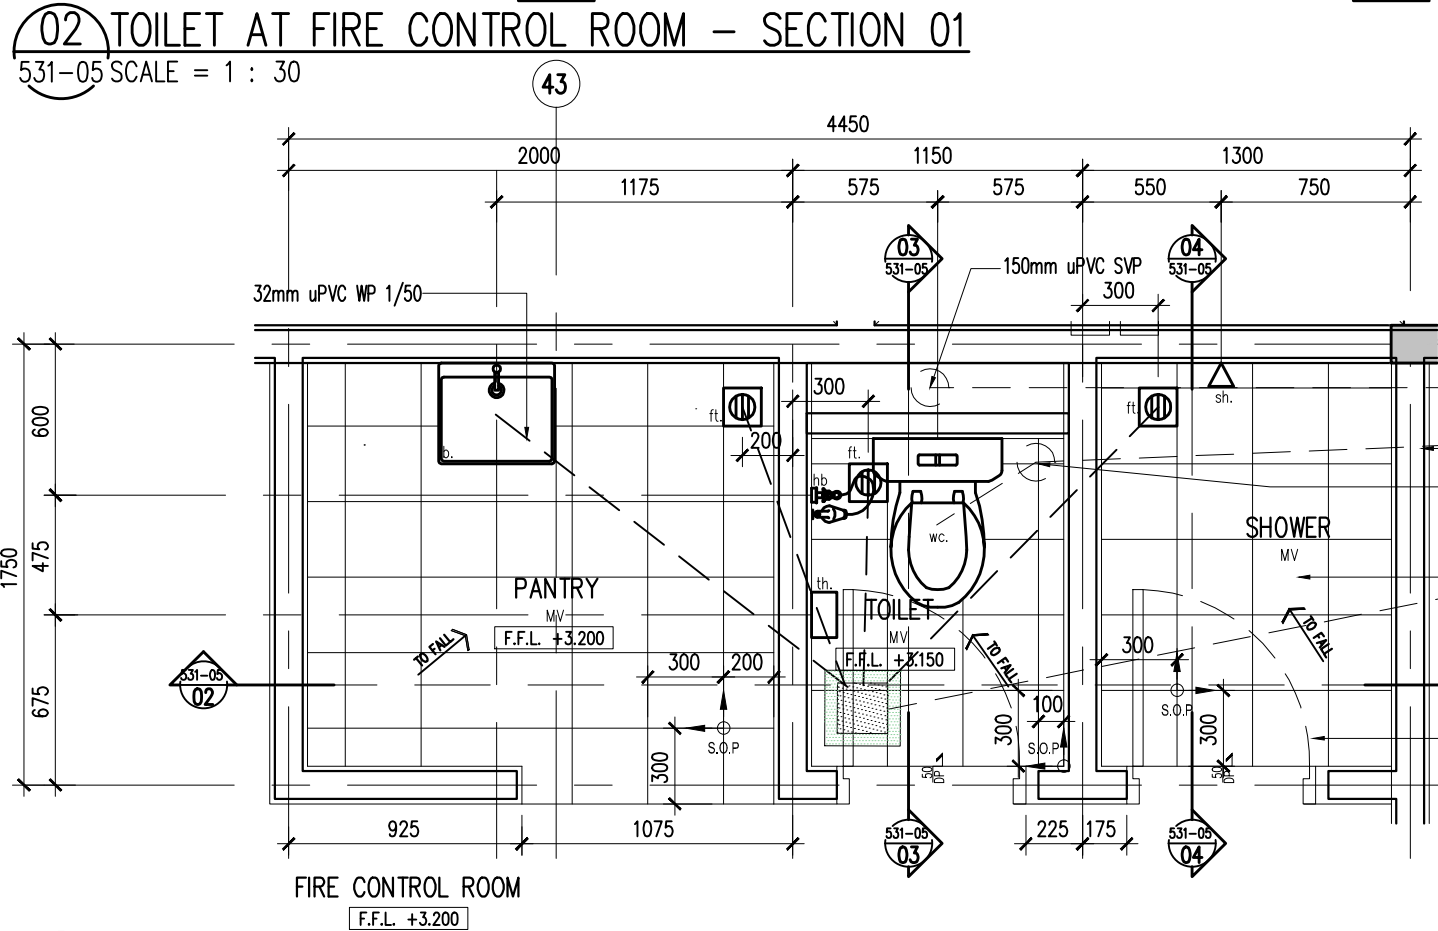

01 TOILET AT FIRE CONTROL ROOM - FLOOR PLAN

531-05 SCALE = 1 : 30

NOTE:
MAINHOLE (MH) AND GULLY TRAP (GT) ARE ONLY AT LEVEL 1

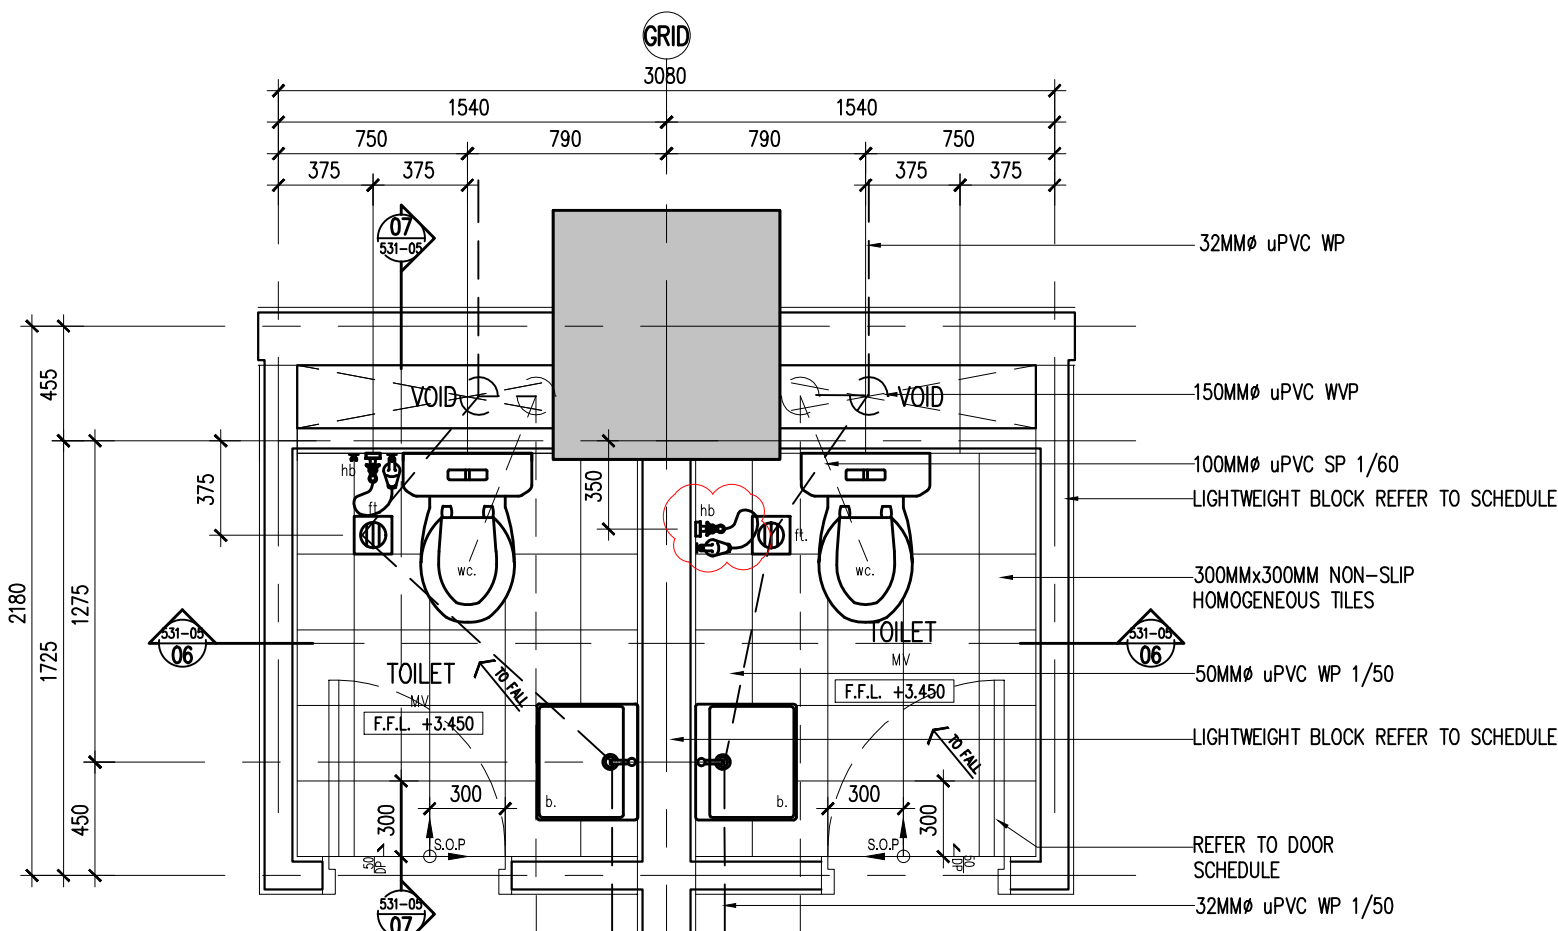


05 TOILET AT RETAIL LEVEL 1-3 - FLOOR PLAN

531-05 SCALE = 1 : 30

Hak Cipta Terpelihara. Tidak dibenarkan mencetak mana-mana bahagian ilustrasi dalam apa jua bentuk dan dengan apa cara pun samada secara elektronik, mencetak, mekanik, rakaman atau cara lain sebelum mendapat kebenaran bertulis dari BH YEW ARCHITECTS SDN. BHD.

REV.	DATE	DESCRIPTION	REMARK
A.01	28/11/2017	REVISED TOILET DETAIL (CLOUDED)	-

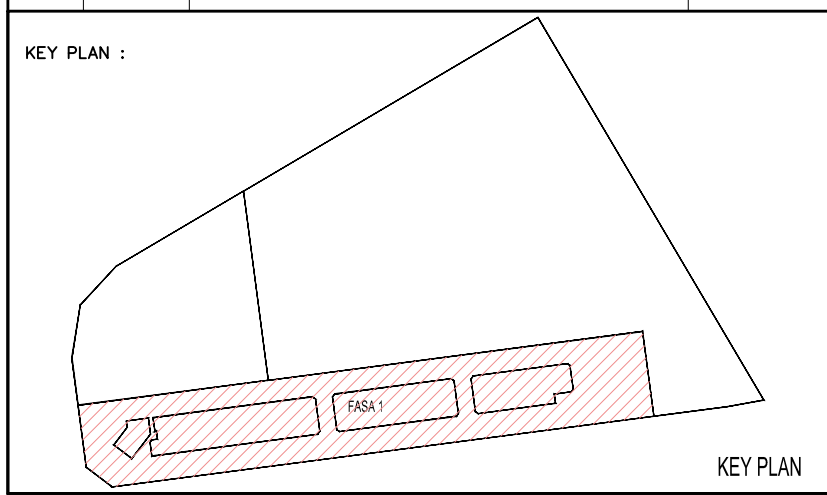

PROJECT TITLE :
CADANGAN PEMBANGUNAN BERCAMPUR DI ATAS LOT 21135, PERSIARAN CASSIA BARAT 3, MUKIM 13, SEBERANG PERAI SELATAN, PULAU PINANG YANG MANGANDUNGI :
FASA 1 :
A. 2 BLOK PANGSAPURI PERKHIDMATAN 18 TINGKAT (612 UNIT)
B. KEDAI PEJABAT 3 TINGKAT (196 UNIT)
C. 5 TINGKAT TEMPAT LETAK KENDERAAN

UNTUK : TETUAN PARAMOUNT PROPERTY (PW) SDN. BHD

LAND OWNER & BUILDING OWNER :

NAMA : MR. OOI HUN PENG
JAWATAN : KETUA PEGAWAI EKSEKUTIF
NO IC : 650619-02-5311
ALAMAT : PARAMOUNT PROPERTY (PW) SDN. BHD
WISMA PARAMOUNT, 1A (1ST FLOOR), LORONG BLM 1/1,
BANDAR LAGUNA MERBOK, 08000 SUNGAI PETANI, KEDAH
NO. TEL : 604 - 441 9191 FAX : 604 - 441 9090

KITCHEN SPECIALIST :

QS CONSULTANT :

M&E CONSULTANT :
PERUNDING P.L.A.
Consulting Mechanical & Electrical Engineers.
8-01, WISMA PANTAI, TEL. NO. : (604) 3337990
JALAN WISMA PANTAI, NO IC : 650619-02-5311
12200 BUTTERWORTH, PENANG. FAX NO. : (604) 3317337
E-MAIL : project@pla-group.com

C&S CONSULTANT :
PERUNDING KELANA
CIVIL & STRUCTURAL ENGINEERS
Level 12, Unit 12(D), Wisma Boon Siew,
No.1, Penang Road, 10000 Penang.
Tel: 2622628, Fax: 2641618
(Company No. AS0232772-W)

DESIGN ARCHITECT :
ARCHITECTURE GROUP - STUDIO A
CPG CONSULTANTS PTE LTD
2388, THOMSON ROAD, #12-00 TOWER B
NOVENA SQUARE, SINGAPORE 307685
TEL : +65 6357 4468 FAX : +65 6357 4469

ARCHITECT :
BH YEW ARCHITECT (SP/Y61)
15TH FLOOR, BANGUNAN AMMETULIFE
NO.1, JALAN LUMUT, 50400 KUALA LUMPUR
TEL: (03) 4043-1346 FAX: (03) 4043-1349
EMAIL: yhw@nrsb.com.my

LEMBAGA ARKITER MALAYSIA
Ar. YEW BU HWA
ARKITEK
No. Pendaftaran LAM: A/Y61
Saya mengesahkan bahawa pelan-pelan yang dihantar adalah mengikut Undang-Undang Ketiangan Seragam 1986 dan Undang-Undang Ketiangan Seragam (Ginapan) 2007 [UGS2007] dan piagam-piagam serta perundangan-perundangan dan piagam-piagam Perundangan Selangor Perai. Saya mengesahkan bahawa kerja-kerja pembinaan akan dijalankan dibawah pengawasan saya. Saya mengesahkan dan mengikut piagam-piagam bangunan adalah sah dan dengan piagam kebenaran merancang yang diluluskan dan akan mematuhi ulusan serta syarat-syarat jabatan teknik.

CONSTRUCTION DRAWING
NOVEMBER 2017

LUKISAN :

TOILET DETAIL :
-TOILET AT FIRE CONTROL ROOM PLAN
AND RETAIL LEVEL 1-3 FLOOR PLAN
-SECTION 01,02,03,04,05

SCALE: AS SHOWN	CAD NO: 557_CA-531-05	DATE: 28 November 2017
DRAWN BY: izwan/abdul rahim	CHECKED BY: HAZRAL/ANICE	DISCIPLINE
ORIGINATOR ACRONYM	PROJECT NO.	DISCIPLINE
BH YEW	55714	ARCH
DWG STATUS	BLOCK	DWG NO.
CA	-	531
DWG NO.	05	REVISION
A.01		