



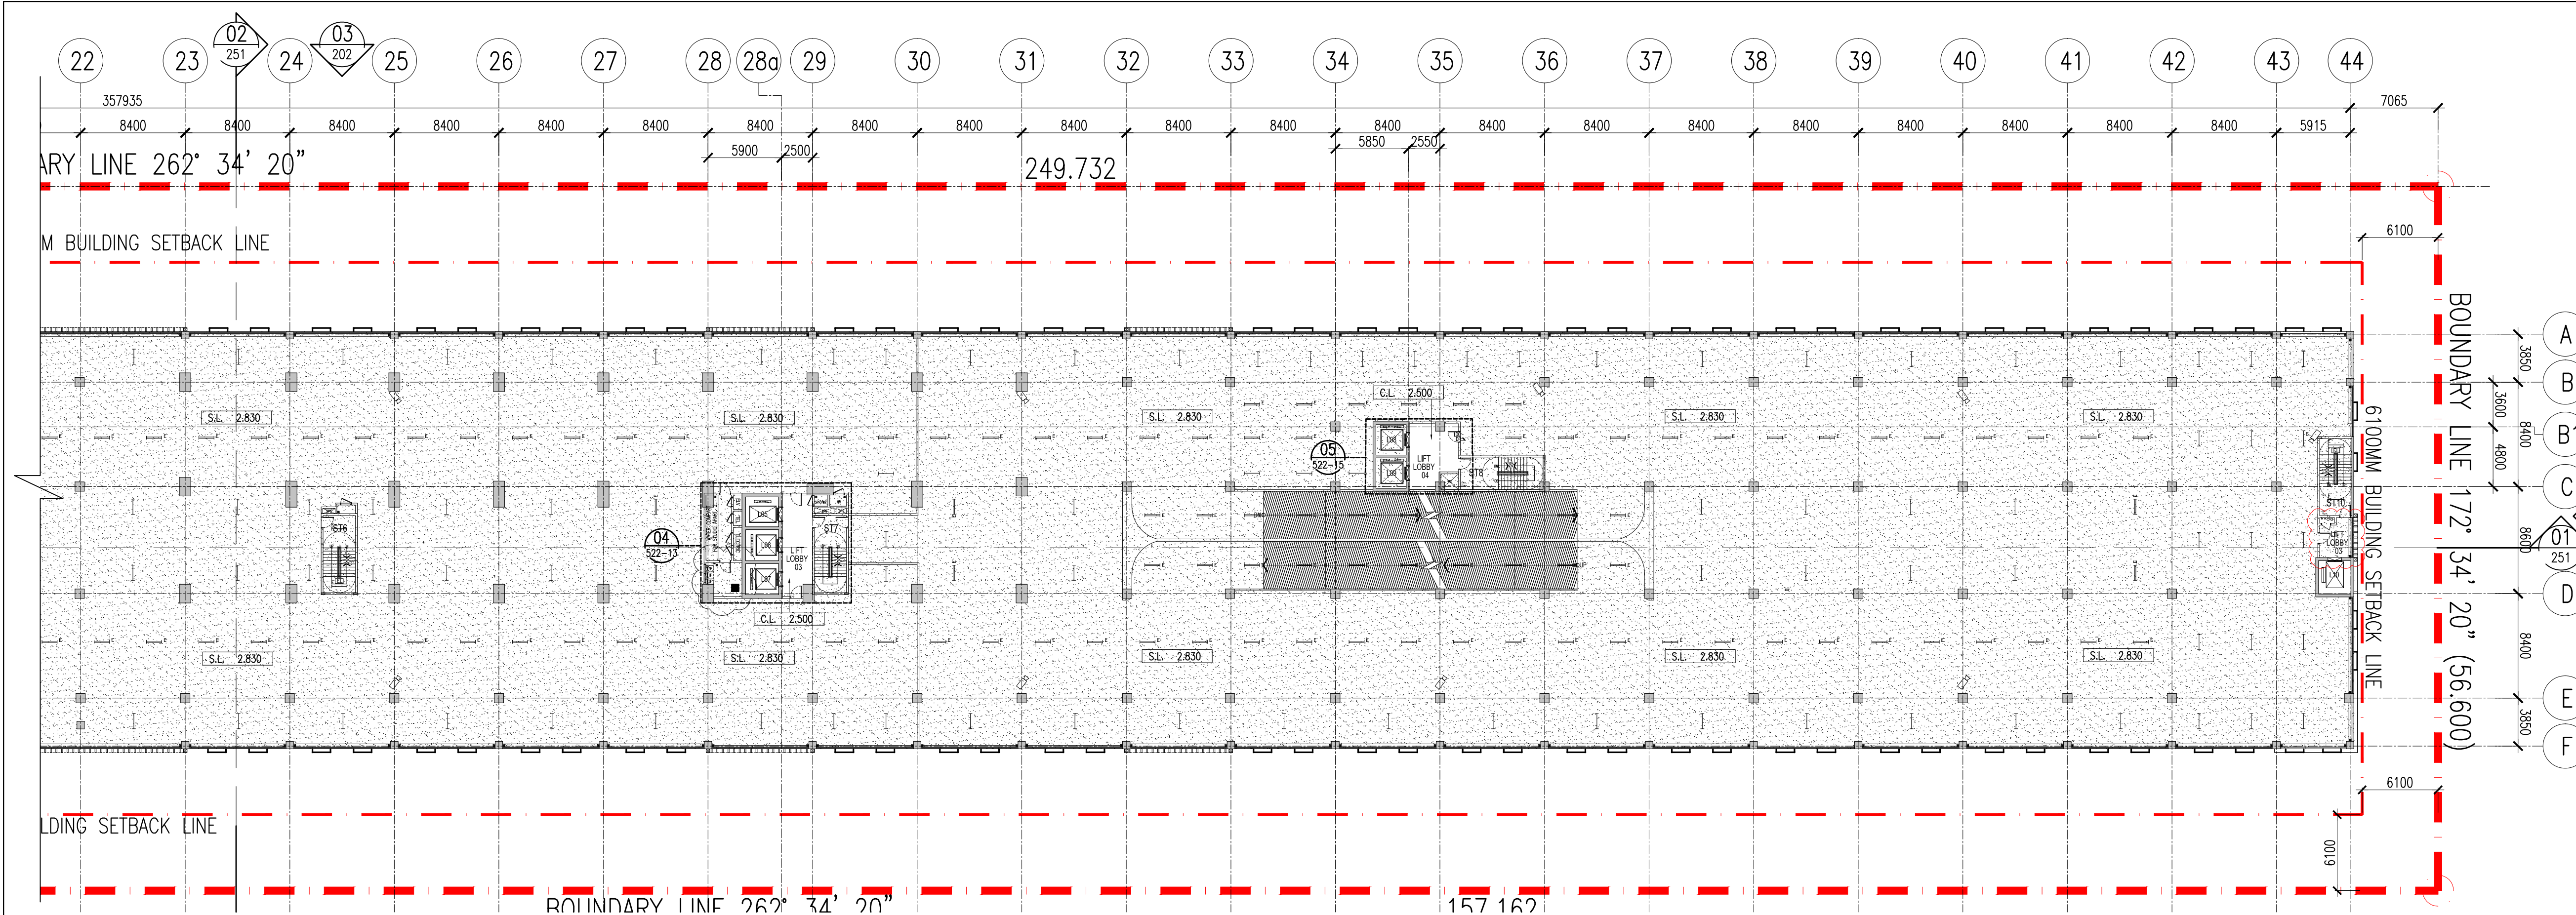

02 REFLECTED CEILING PLAN DEMARCATION (2 OF 2) - LEVEL 5-6
710-05 SCALE = 1 : 300

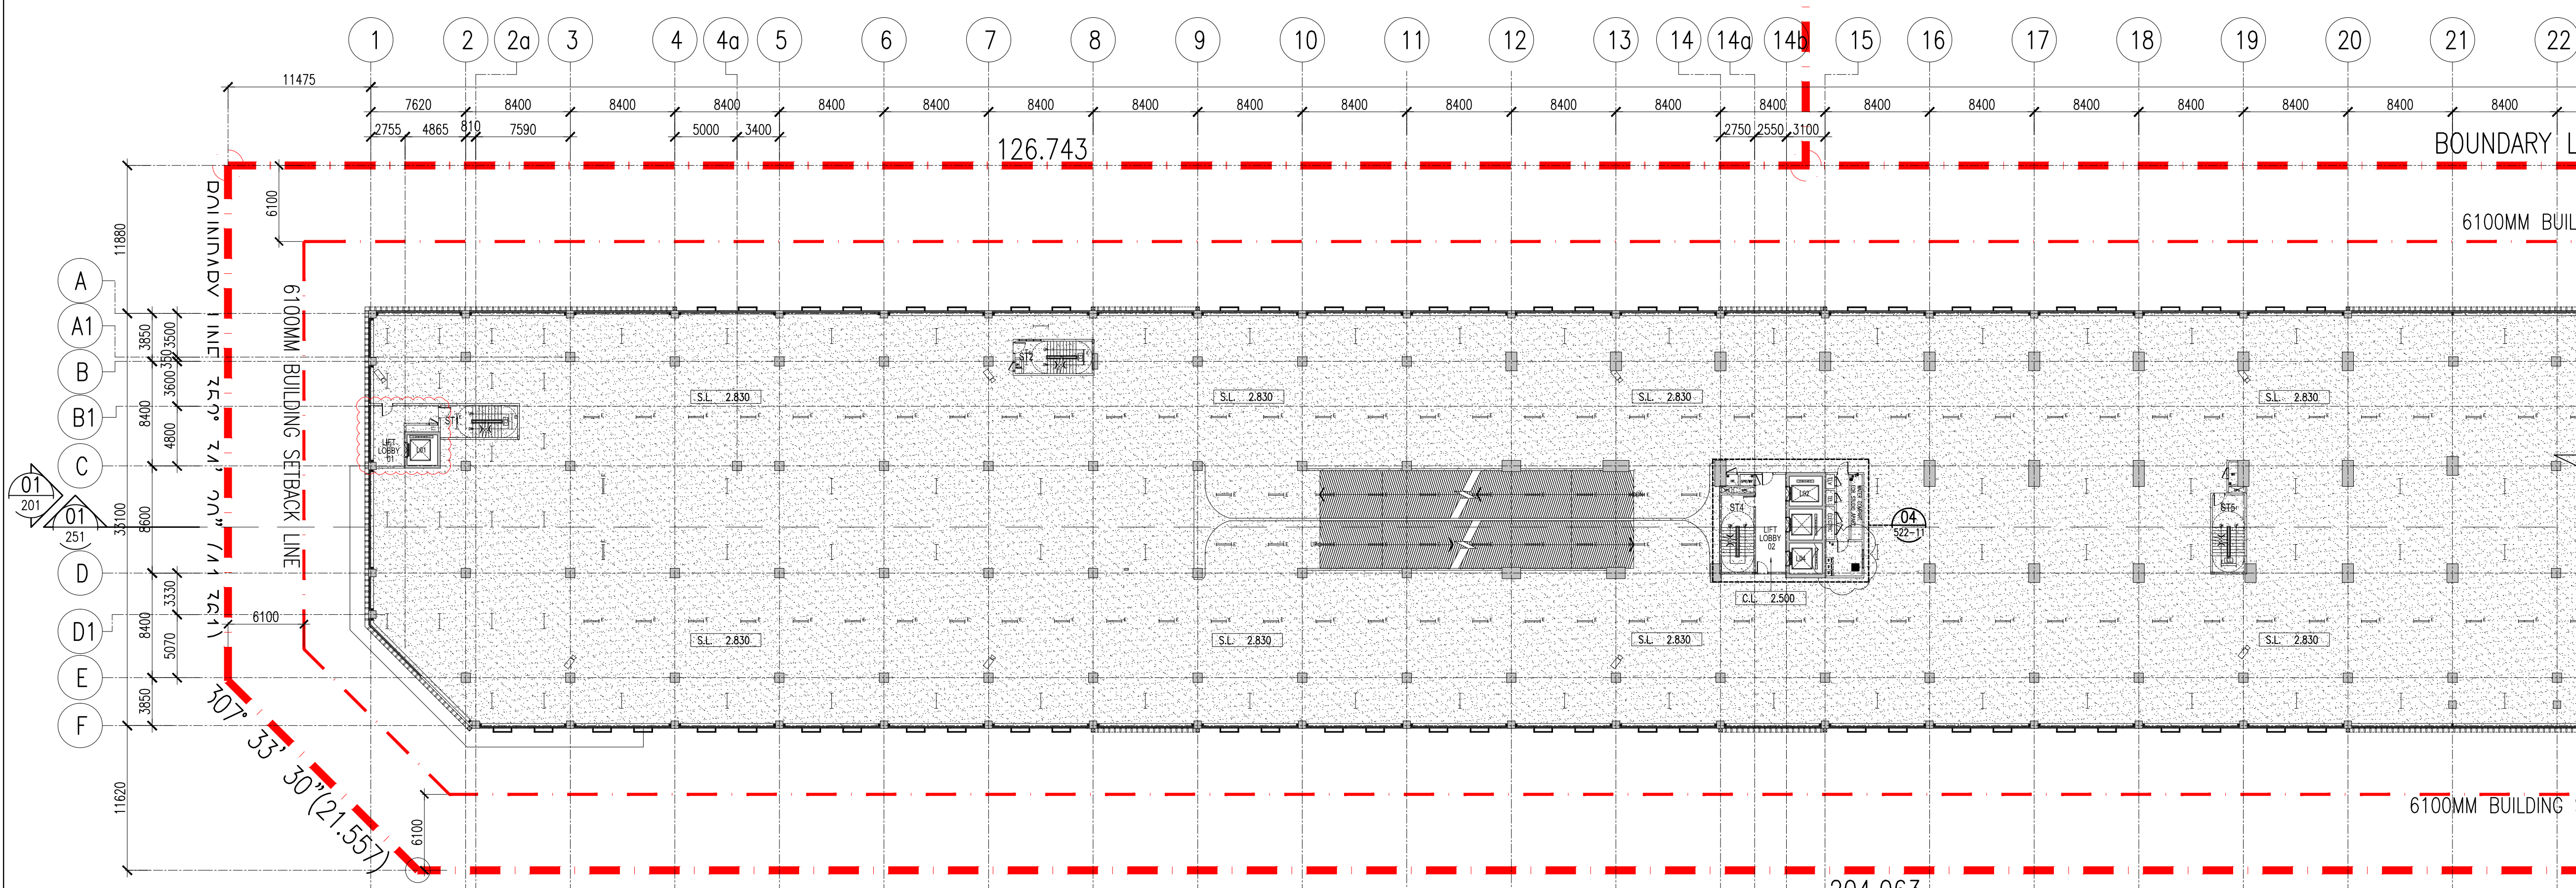

01 REFLECTED CEILING PLAN DEMARCATION (1 OF 2) - LEVEL 5-6
710-05 SCALE = 1 : 300

Hak Cipta Terpelihara. Tidak dibenarkan mencetak mana-mana bahagian ilustrasi dalam apa jua bentuk dan dengan apa cara pun samada secara elektronik, pencetak, mekanik, rakaman atau cara lain sebelum mendapat kebenaran bertulis dari BH YEW ARCHITECTS SDN. BHD.

REV.	DATE	DESCRIPTION	REMARK
A.01	30/01/2018	REVISED CEILING HEIGHT	
	04/09/2018	UPDATING DRAWING	abdul rahim

KEY PLAN :

PROJECT TITLE :

CADANGAN MEMBINA PEMBANGUNAN BERCAMPUR DI ATAS LOT 21135, PERSIARAN CASSIA BARAT 3, MUKIM 13, SEBERANG PERAI SELATAN, PULAU PINANG YANG MENGANDUNGI:-

FASA 1

- A. 2 BLOK PANGSAPURI PERKHIDMATAN 18 TINGKAT (612 UNIT)
- B. KEDAI PEJABAT 3 TINGKAT (196 UNIT)
- C. 5 TINGKAT TEMPAT LETAK KENDERAAN

UNTUK : TETUAN PARAMOUNT PROPERTY (PW) SDN. BHD

LAND OWNER & BUILDING OWNER :

NAMA : MR. OOI HUN PENG
JAWATAN : KETUA PEGAWAI EKSEKUTIF
NO IC : 650619-02-9311
ALAMAT : PARAMOUNT PROPERTY (PW) SDN. BHD
WISMA PARAMOUNT, 1A (1ST FLOOR), LORONG BLM 1/1,
BANDAR LAGUNA MERBOK, 08000 SUNGAI PETANI, KEDAH
NO. TEL : 604 - 441 9191 FAX : 604 - 441 9090

KITCHEN SPECIALIST :

GS CONSULTANT :

MAE CONSULTANT :

PERUNDING P.L.A.
Consulting Mechanical & Electrical Engineers.
8-01, WISMA PANTAI, TEL NO. : (604) 3337990
JALAN WISMA PANTAI, FAX NO. : (604) 3317337
12200 BUTTERWORTH, PENANG. E-MAIL : project@pla-group.com

DES CONSULTANT :

PERUNDING KELANA
CIVIL & STRUCTURAL ENGINEERS
Level 12, Unit 12(D), Wisma Boon Siew,
No.1, Penang Road, 10000 Penang.
Tel: 2622628, Fax: 2641618
(Company No. AS0232772-W)

DESIGN ARCHITECT :

ARCHITECTURE GROUP - STUDIO A
CPG CONSULTANTS PTE LTD
2388, THOMSON ROAD, #12-00 TOWER B
NOVENA SQUARE, SINGAPORE 307685
TEL : +65 6357 4468 FAX : +65 6357 4469

ARCHITECT :

BH YEW ARCHITECT (SP/Y61)
15TH FLOOR, BANGUNAN AMMETLIFE
NO.1, JALAN LUJUT, 50400 KUALA LUMPUR
TEL (03) 4043-1346 FAX: (03) 4043-1349
EMAIL: ybhw@nrsb.com.my

CONSTRUCTION DRAWING
MARCH 2018

LUKSAN :

REFLECTED CEILING PLAN DEMARCATION
-LEVEL 5-6

SCALE:	AS SHOWN	CMD NO:	557_CA-710-05
DRAWN BY:	abdul rahim	CHECKED BY:	JANICE
ORIGINATOR ACRONYM	BH YEW	PROJECT NO.	55714
DWG STATUS	CA	BLOCK	-
DWG NO.	710	DWG NO.	05
REVISION	A.01		