

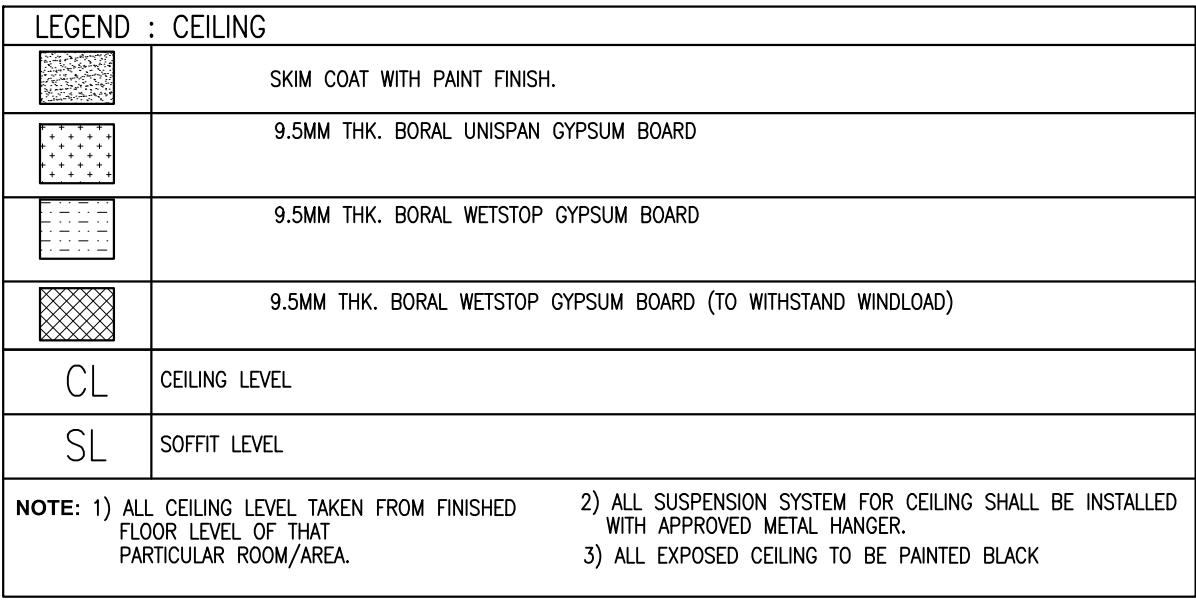
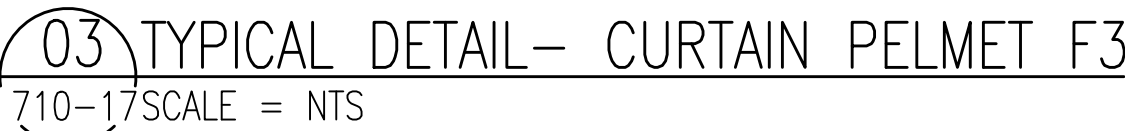
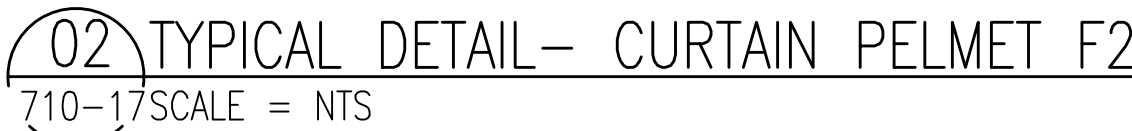
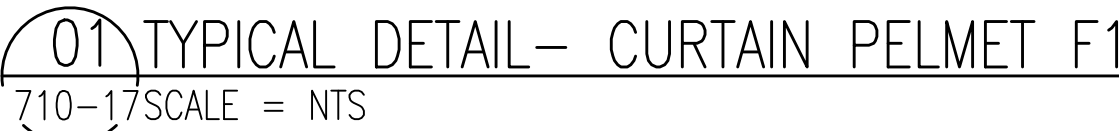


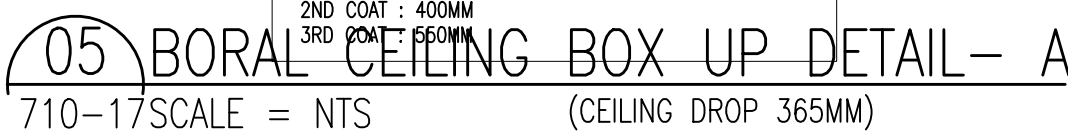

SYMBOL	DESCRIPTION
	CEILING LIGHTING POINT.
	CEILING FAN POINT C/W FAN HOOK.
	1 X 20W LED TUBE BARE CHANNEL C/W INTERNAL DRIVER (1000 LUMEN,3000K) (PHILIPS, OSRAM OR EQUIVALENT)
	1 X 20W LED TUBE BARE CHANNEL WALL MOUNTED TYPE C/W INTERNAL DRIVER (1000 LUMEN,3000K) (PHILIPS, OSRAM OR EQUIVALENT)
	1 X 10W LED TUBE BARE CHANNEL C/W INTERNAL DIVER (1000 LUMEN,3000K) (PHILIPS, OSRAM OR EQUIVALENT)
	1 X 10W LED TUBE BARE CHANNEL WALL MOUNTED TYPE C/W INTERNAL DRIVER (1000 LUMEN,3000K) (PHILIPS, OSRAM OR EQUIVALENT)

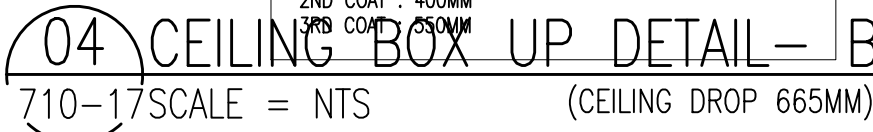

REV.	DATE	DESCRIPTION	REMARK
A.01	30/01/2018	REVISED CEILING HEIGHT	
	04/09/2018	UPDATING DRAWING	abdul rahim

A. 2 BLOK PANGSAPURI PERKHIDMATAN 18 TINGKAT (612 UNIT)
B. KEDAI PEJABAT 3 TINGKAT (196 UNIT)
C. 5 TINGKAT TEMPAT LETAK KENDERAAN

UNTUK : TETUAN PARAMOUNT PROPERTY (PW) SDN. BHD

LAND OWNER & BUILDING OWNER :

NAMA : MR. OOI HUN PENG
JAWATAN : KETUA PEGAUAI EKSEKUTIF
NO IC : 650619-02-5311
ALAMAT : PARAMOUNT PROPERTY (PW) SDN. BHD
WISMA PARAMOUNT, 1A (1ST FLOOR), LORONG BLM 1/1,
BANDAR LAGUNA MEROK, 08000 SUNGAI PETANI, KEDAH
NO. TEL : 604 - 441 9191 FAX : 604 - 441 9090

KITCHEN SPECIALIST :

QS CONSULTANT

 
M&E CONSULTANT :
PERUNDING
Consulting Mechanical & Electrical Engineers.

8-01, WISMA PANTAI,
JALAN WISMA PANTAI,
12200 BUTTERWORTH, PENANG.

P.L.A.
TEL. NO. : (604) 3337990
FAX NO. : (604) 3317337
E-MAIL : project@pla-group.com

C&S CONSULTANT : **PERUNDING KELANA**
 **CIVIL & STRUCTURAL ENGINEERS**
 Level 12, Unit 12(D), Wisma Boon Siew,
 No.1, Penang Road, 10000 Penang.
 Tel: 2622628, Fax: 2641618
 (Company No. AS0232772-W)

DESIGN ARCHITECT :

 ARCHITECTURE GROUP - STUDIO A
CPG CONSULTANTS PTE LTD

238B, THOMSON ROAD, #12-00 TOWER B
NOVENA SQUARE, SINGAPORE 307685
TEL : +65 6357 4468 FAX : +65 6357 4469

ARCHITECT : **BH YEW**
ARCHITECT (SP/Y61)
15TH FLOOR, BANGUNAN AMMETLIFE
NO.1, JALAN LUMUT, 50400 KUALA LUMPUR
TEL: (03) 4043-1346 FAX: (03) 4043-1349
EMAIL: ybhwa@nrasb.com.my

CONSTRUCTION DRAWING
MARCH 2018

LUKISAN :

CEILING AND ELECTRICAL LEGEND

SCALE: AS SHOWN		CAD NO.: 557-CA-710-18			
DRAWN BY: abdulrahim		CHECKED BY: JANICE		DATE: MARCH 2018	
ORIGINATOR ACRONYM		PROJECT NO.		DISCIPLINE	
BH YEY		55714		ARCH	
DWG STATUS	BLOCK	BLOCK	DWG NO.	DWG NO.	REVISION
CA	—	—	710	18	A.01