


02 TOILET 3 LEVEL 1 – REFLECTED CEILING PLAN PLAN

531-04 SCALE = 1 : 50

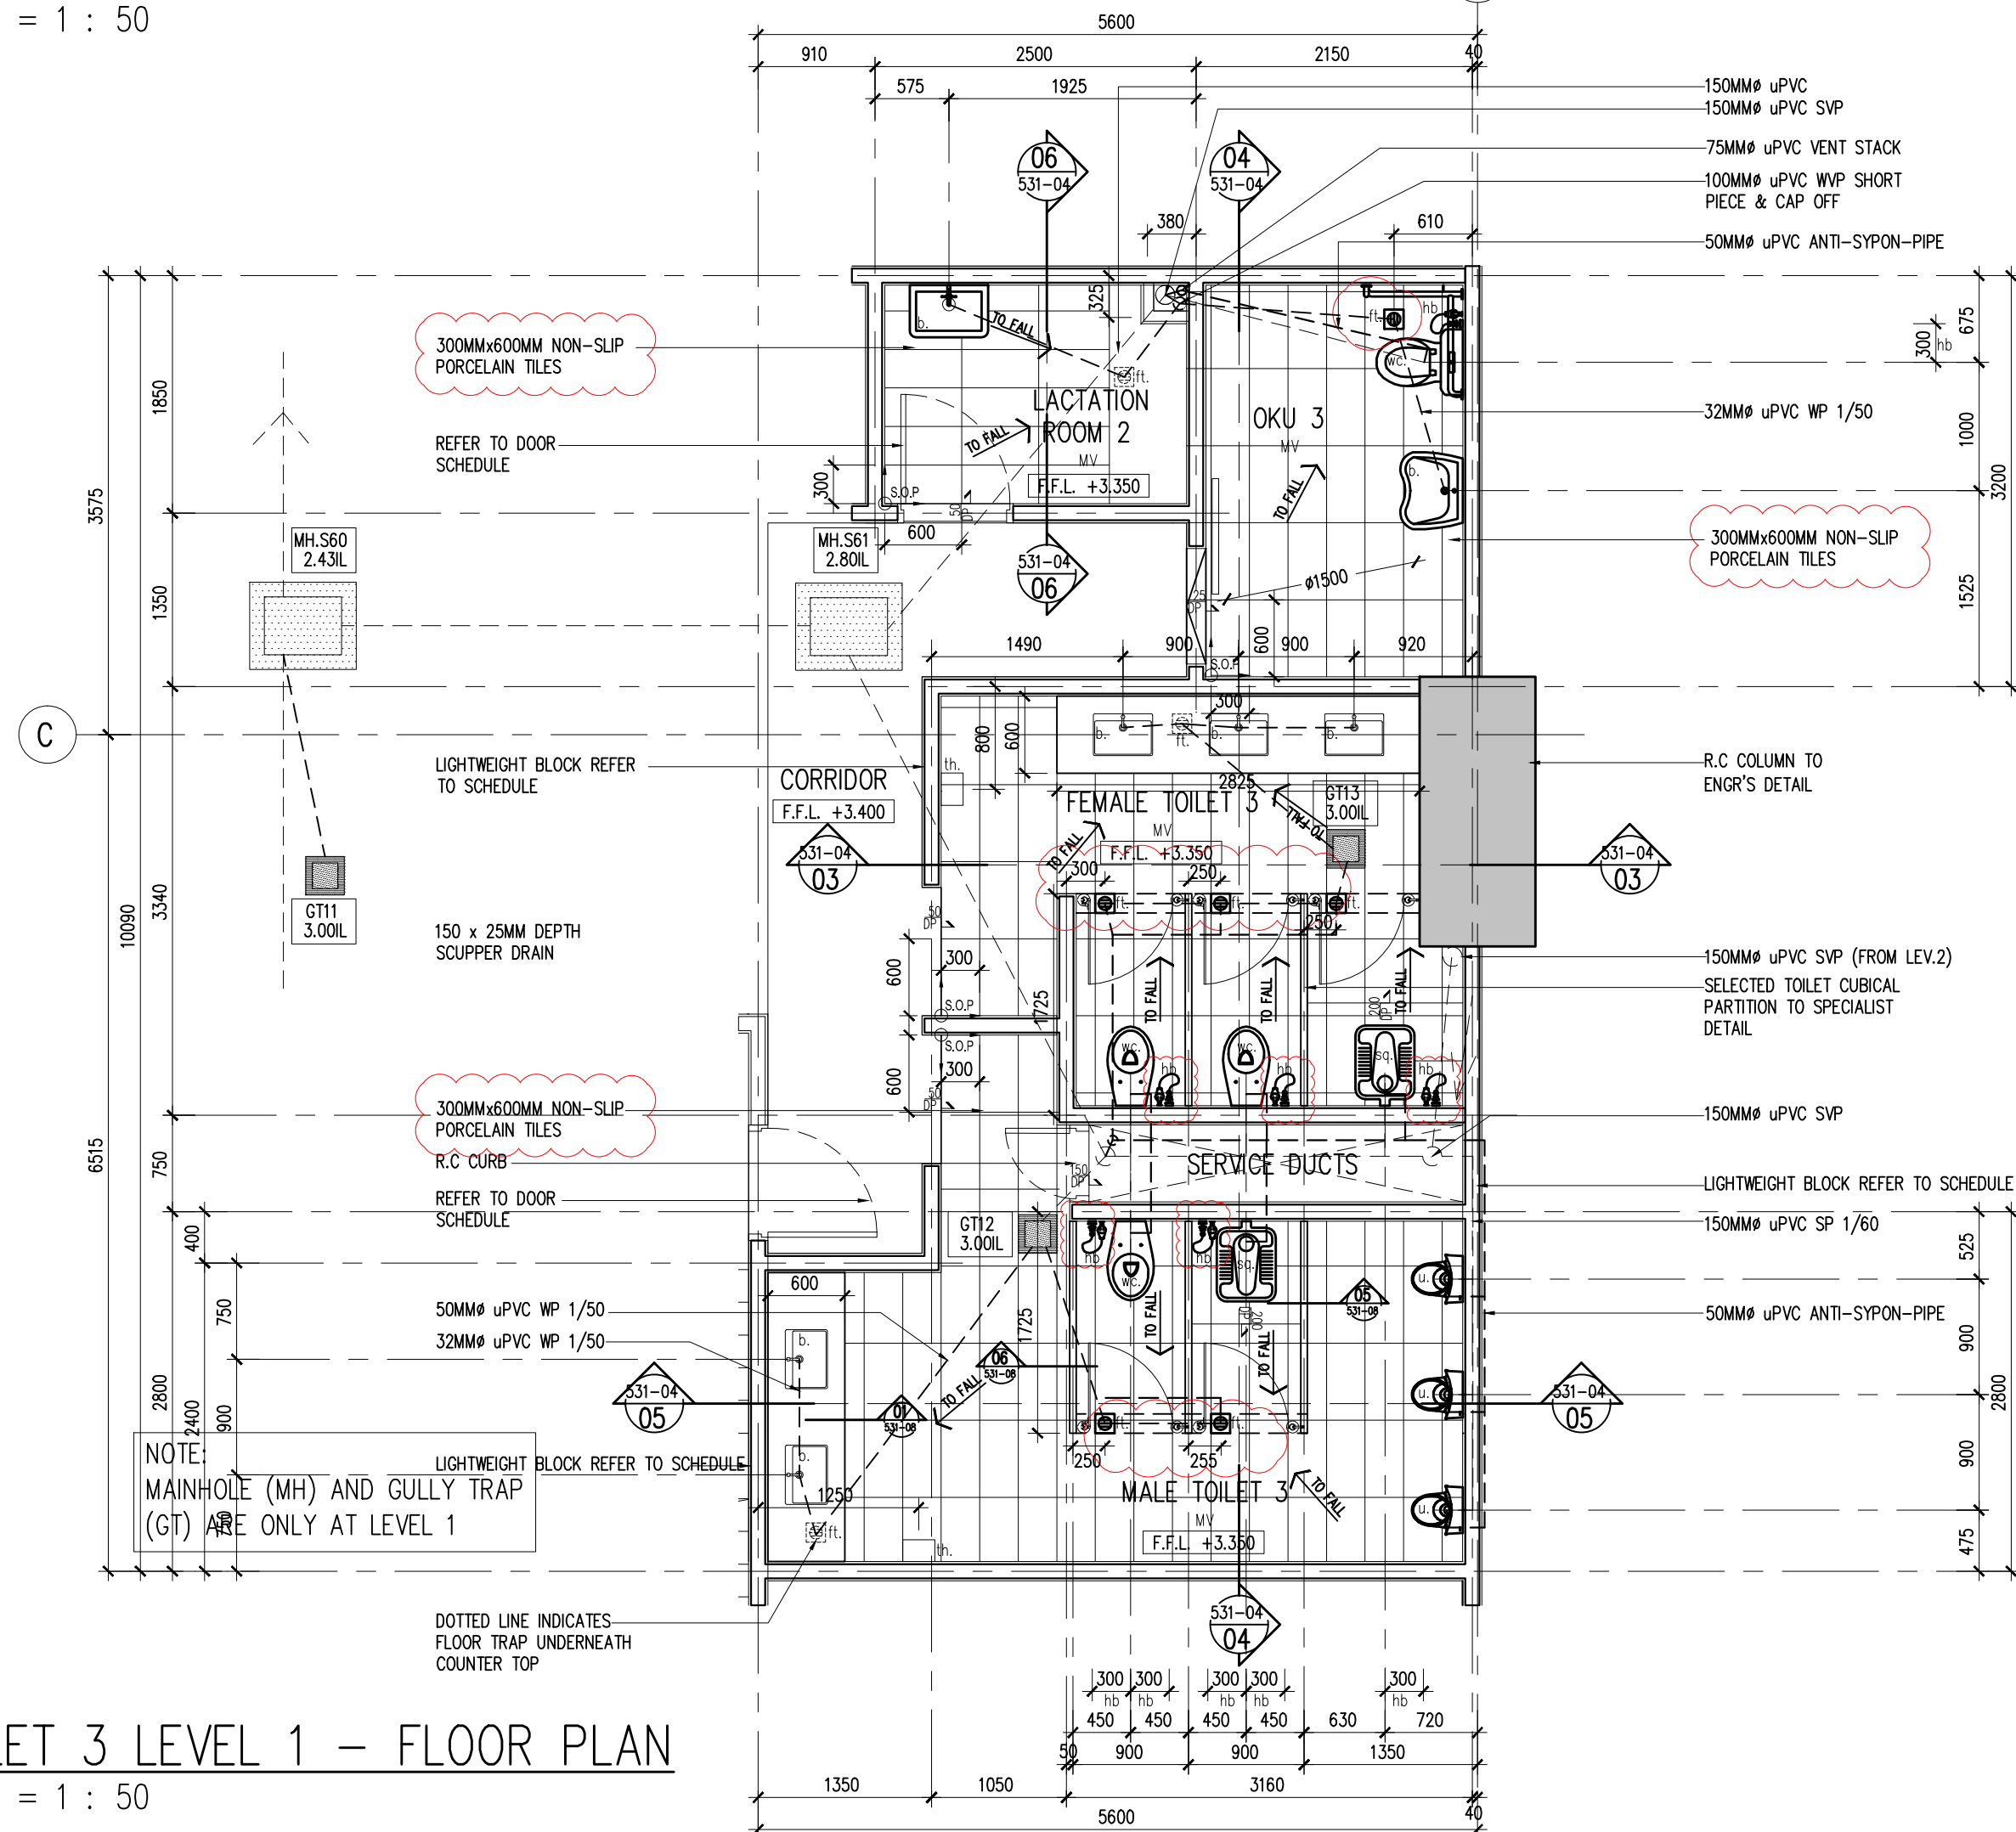


01 TOILET 3 LEVEL 1 – FLOOR PLAN

531-04 SCALE = 1 : 50


06 TOILET 3 LEVEL 1 – SECTION 05

531-04 SCALE = 1 : 50

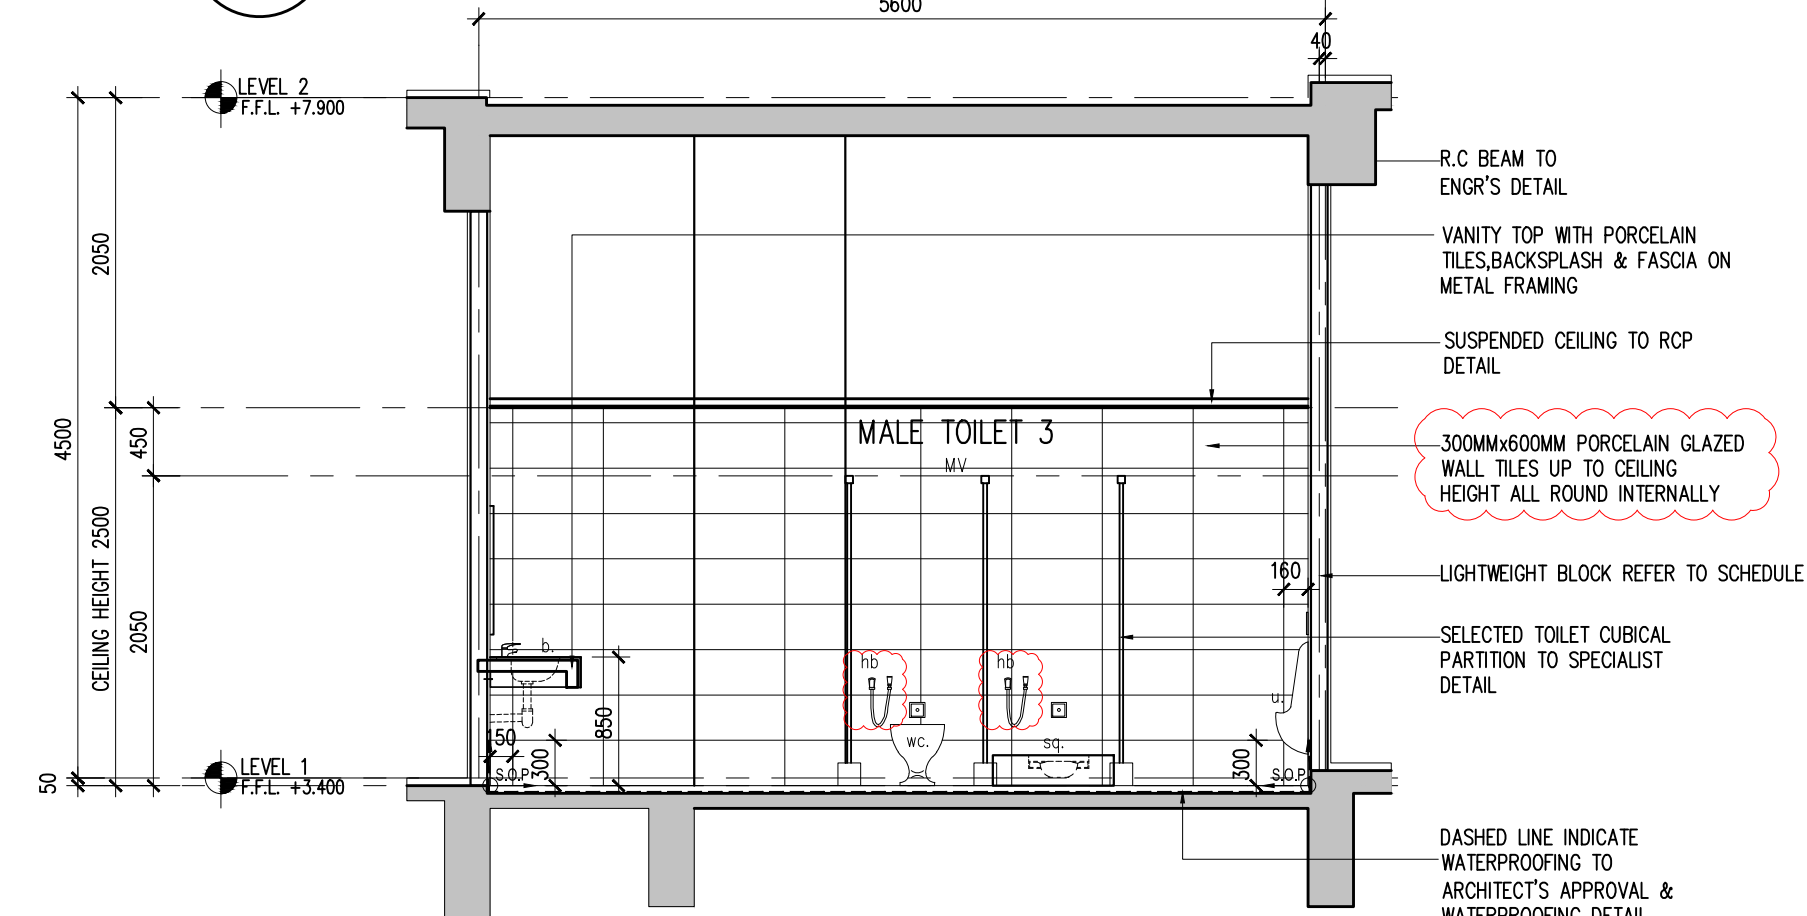


05 TOILET 3 LEVEL 1 – SECTION 04

531-04 SCALE = 1 : 50

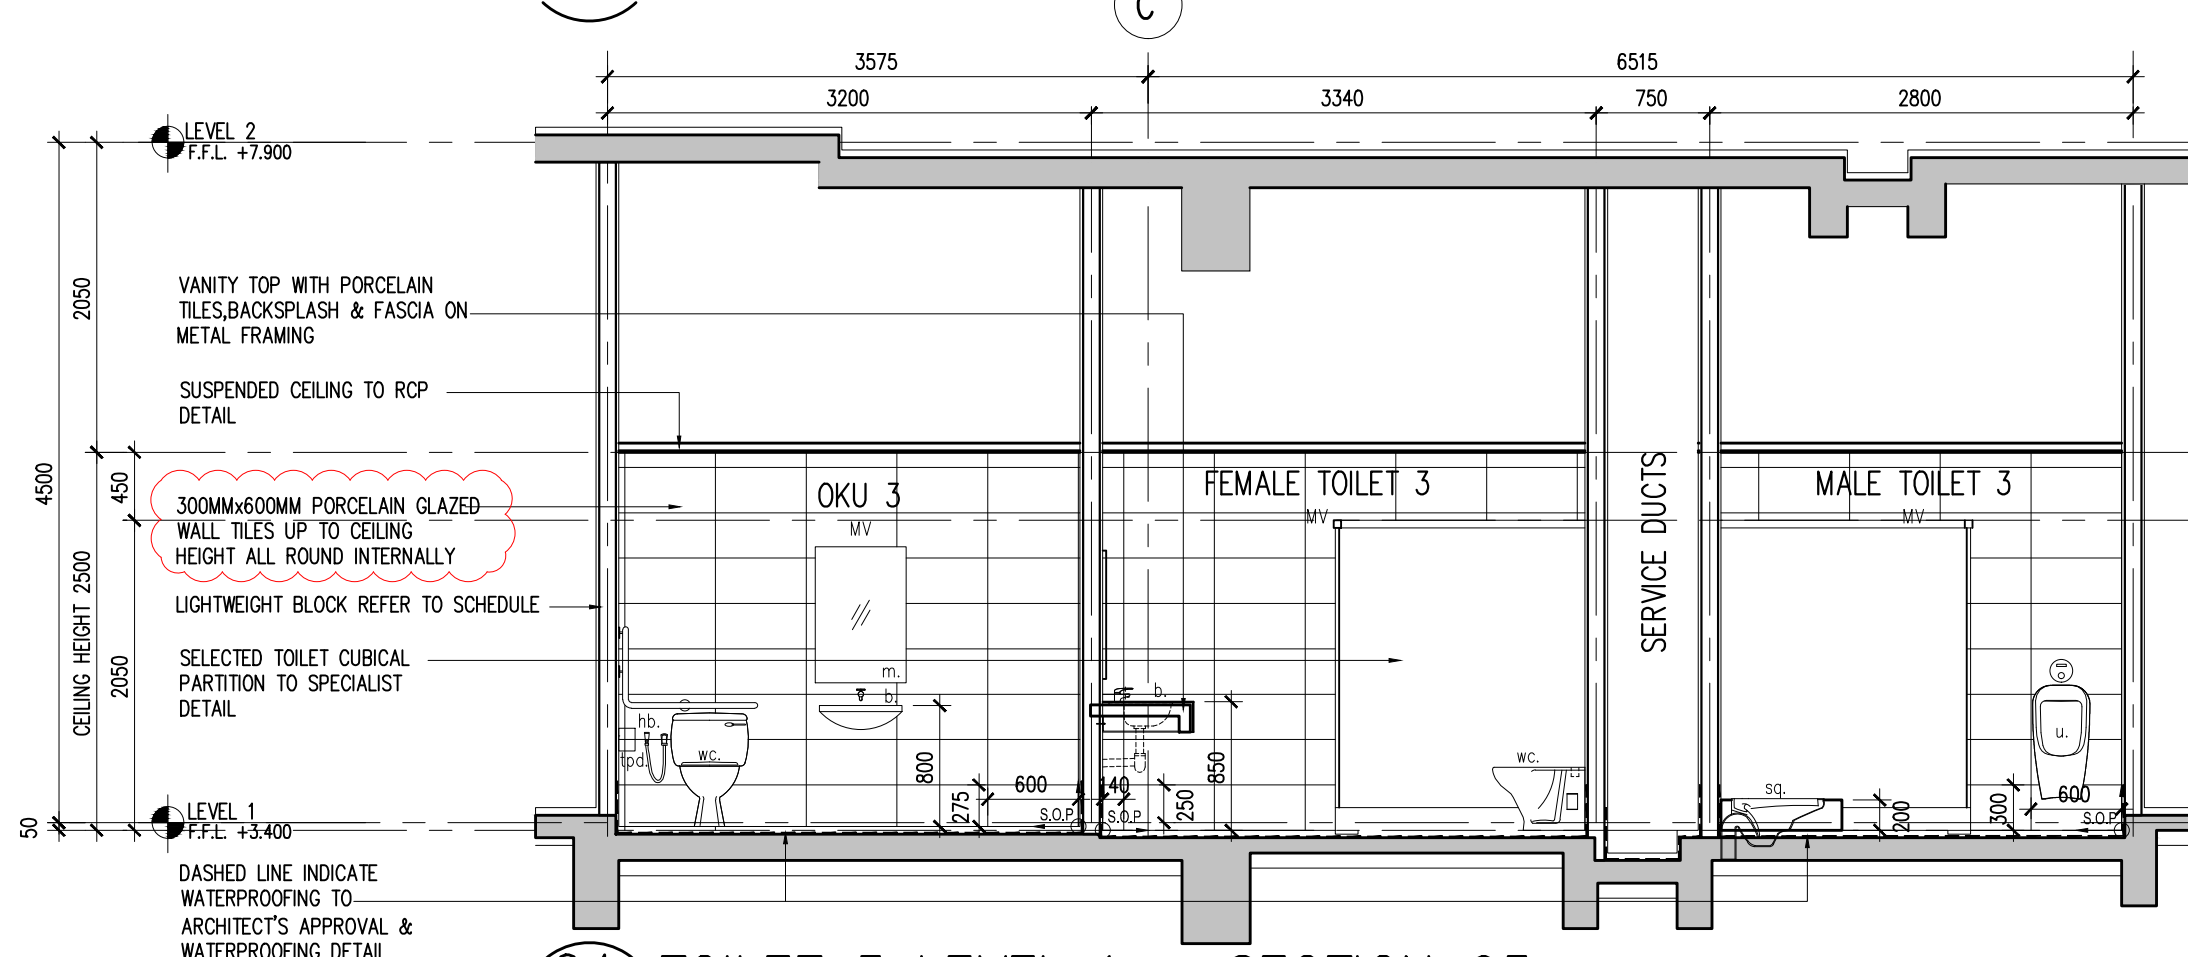

04 TOILET 3 LEVEL 1 – SECTION 03

531-04 SCALE = 1 : 50

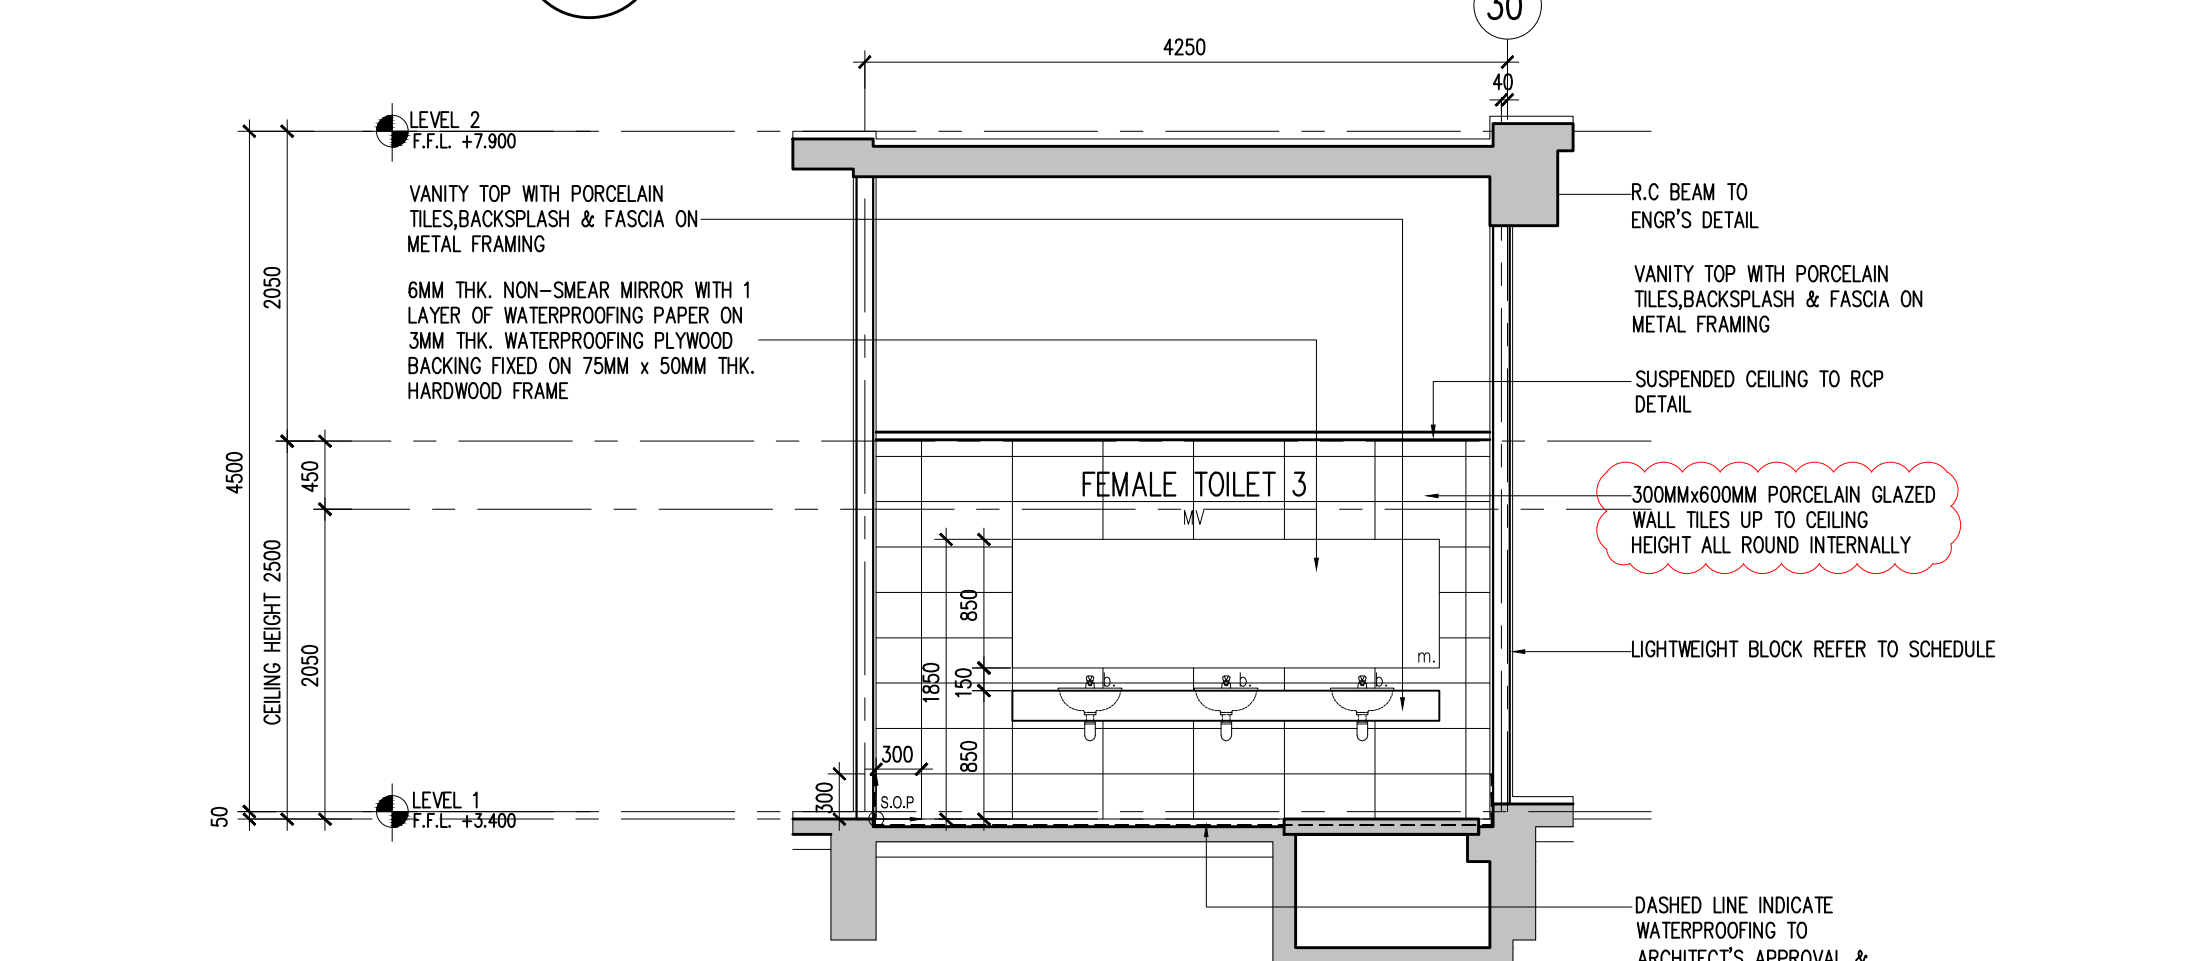

03 TOILET 3 LEVEL 1 – SECTION 01

531-04 SCALE = 1 : 50


Note : M&E power points setting out to refer to M&E detail drawing

DESCRIPTION	FITTINGS
Vanity counter top	lavatory
Floor trap	ft.
Hand bidet	hb.
Hand dryer	hd.
6mm thk. Mirror	in.
Toilet paper holder	th.
Squatting	sq.
Urinal	u.
Water closet	wc.

LEGEND	
DESCRIPTION	
Mechanical ventilation	mv

Hak Cipta Terpelihara. Tidak dibenarkan mencetak mana-mana bahagian ilustrasi dalam apa jua bentuk dan dengan apa cara pun samada secara elektronik, mencetak, mekanik, rakaman atau cara lain sebelum mendapat kebenaran bertulis dari BH YEW ARCHITECTS SDN. BHD.

REV.	DATE	DESCRIPTION	REMARK
A.01	28/11/2017	REVISED TOILET DETAIL (CLOUDED)	
A.02	03/09/2018	UPDATING DRAWING (REVISED DETAIL - CLOUDED)	abdul rahim
		ADD CEILING PLAN, TILES TYPE CHANGES	

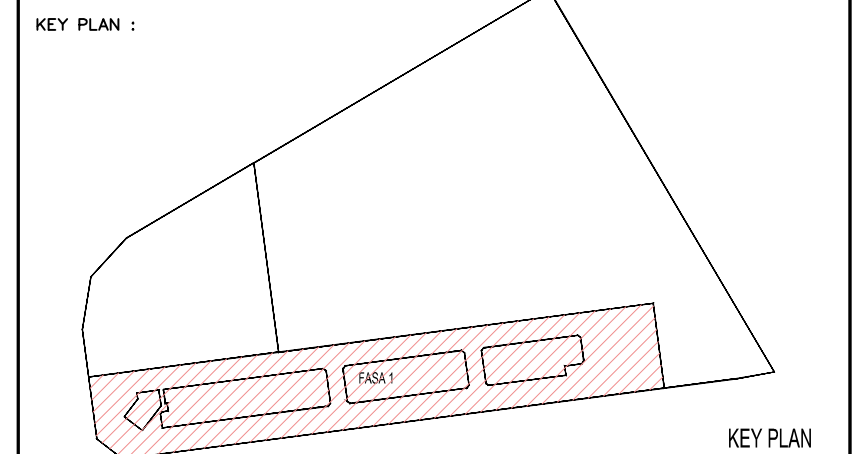

PROJECT TITLE :
CADANGAN MEMBINA PEMBANGUNAN BERCAMPUR DI ATAS LOT 21135, PERSIARAN CASSIA BARAT 3, MUKIM 13, SEBERANG PERAI SELATAN, PULAU PINANG YANG MENGANDUNGI:-
FASA 1
A. 2 BLOK PANGSAPURI PERKHIDMATAN 18 TINGKAT (612 UNIT)
B. KEDAI PEJABAT 3 TINGKAT (196 UNIT)
C. 5 TINGKAT TEMPAT LETAK KENDERAAN

UNTUK : TETUAN PARAMOUNT PROPERTY (PW) SDN. BHD

LAND OWNER & BUILDING OWNER :
NAMA : MR. OOI HUN PENG
JAWATAN : KETUA PECAKAWAI EKSEKUTIF
NO IC : 650619-02-5311
ALAMAT : PARAMOUNT PROPERTY (PW) SDN. BHD
WISMA PARAMOUNT, 1A (1ST FLOOR), LORONG BLM 1/1,
BANDAR LAGUNA MERBOK, 08000 SUNGAI PETANI, KEDAH
NO. TEL : 604 - 441 9191 FAX : 604 - 441 9090

KITCHEN SPECIALIST :
QS CONSULTANT :

M&E CONSULTANT :
PERUNDING P.L.A.
Consulting Mechanical & Electrical Engineers.
8-01, WISMA PANTAI, TEL. NO. : (604) 3337990
JALAN WISMA PANTAI, FAX NO. : (604) 3317337
12200 BUTTERWORTH, PENANG. E-MAIL : project@pla-group.com

C&S CONSULTANT :
PERUNDING KELANA
CIVIL & STRUCTURAL ENGINEERS
Level 12, Unit 12(D), Wisma Boon Siew,
No.1, Penang Road, 10000 Penang.
Tel: 2622628, Fax: 2641616
(Company No. AS0232772-W)

DESIGN ARCHITECT :
ARCHITECTURE GROUP - STUDIO A
CPG CONSULTANTS PTE LTD
2388, THOMSON ROAD, #12-00 TOWER B
NOVENA SQUARE, SINGAPORE 307695
TEL: +65 6357 4468 FAX: +65 6357 4469

ARCHITECT :
BH YEW ARCHITECT (SP/Y61)
15TH FLOOR, BANGUNAN AMMETUFE
NO.1, JALAN LUMUT, 50400 KUALA LUMPUR
TEL: (03) 4043-1346 FAX: (03) 4043-1349
EMAIL: yhw@nrsb.com.my

CONSTRUCTION DRAWING
SEPTEMBER 2018

LUNGAN :
TOILET DETAIL : TOILET 3 LEVEL 1
-FLOOR & REFLECTED CEILING PLAN
-SECTION 01,03,04 & 05

SCALE:
AS SHOWN
DRAWN BY:
abdul rahim
ORIGINATOR ACRONYM
BH YEW
DWC STATUS
CA

CAD NO:
557_CA-531-03
CHECKED BY:
JANICE
PROJECT NO.
55714
BLOCK
-
DWC NO.
531

DATE:
03 SEPT 2018
DISCIPLINE
ARCH
DWC NO.
03

REVISION
A.02