



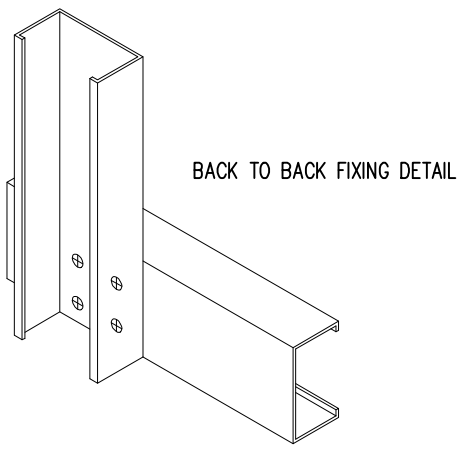

BACK TO BACK FIXING DETAIL


LEGEND : CEILING	
	SKIM COAT WITH PAINT FINISH:
	9.5MM THK. BORAL UNISPAN GYPSUM BOARD
	9.5MM THK. BORAL WETSTOP GYPSUM BOARD
	9.5MM THK. BORAL WETSTOP GYPSUM BOARD (TO WITHSTAND WINDLOAD)
CL	CEILING LEVEL
SL	SOFFIT LEVEL
NOTE: 1) ALL CEILING LEVEL TAKEN FROM FINISHED FLOOR LEVEL OF THAT PARTICULAR ROOM/AREA. 2) ALL SUSPENSION SYSTEM FOR CEILING SHALL BE INSTALLED WITH APPROVED METAL HANGER. 3) ALL EXPOSED CEILING TO BE PAINTED BLACK	

SYMBOL	DESCRIPTION
	CEILING LIGHTING POINT.
	CEILING FAN POINT C/W FAN HOOK.
	1 X 20W LED TUBE BARE CHANNEL C/W INTERNAL DRIVER (1000 LUMEN,3000K) (PHILIPS, OSRAM OR EQUIVALENT)
	1 X 20W LED TUBE BARE CHANNEL WALL MOUNTED TYPE C/W INTERNAL DRIVER (1000 LUMEN,3000K) (PHILIPS, OSRAM OR EQUIVALENT)
	1 X 10W LED TUBE BARE CHANNEL C/W INTERNAL DRIVER (1000 LUMEN,3000K) (PHILIPS, OSRAM OR EQUIVALENT)
	1 X 10W LED TUBE BARE CHANNEL WALL MOUNTED TYPE C/W INTERNAL DRIVER (1000 LUMEN,3000K) (PHILIPS, OSRAM OR EQUIVALENT)

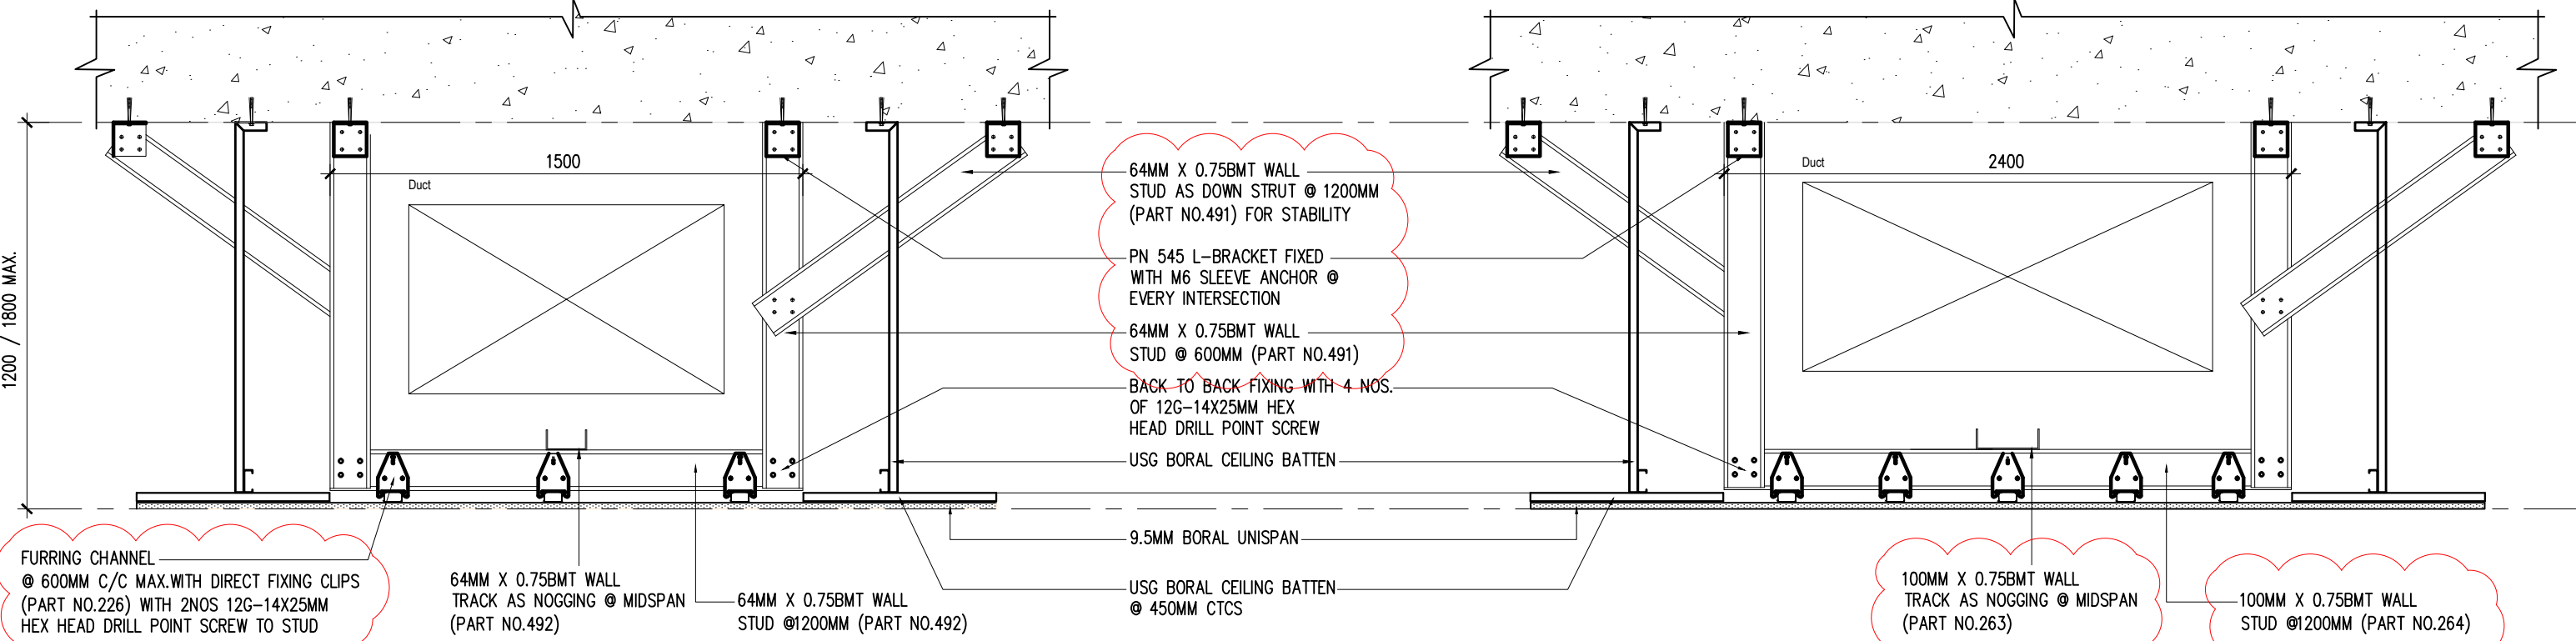


06 DUCT BRIDGING DETAIL- A
710-17 SCALE = NTS


07 DUCT BRIDGING DETAIL- B
710-17 SCALE = NTS

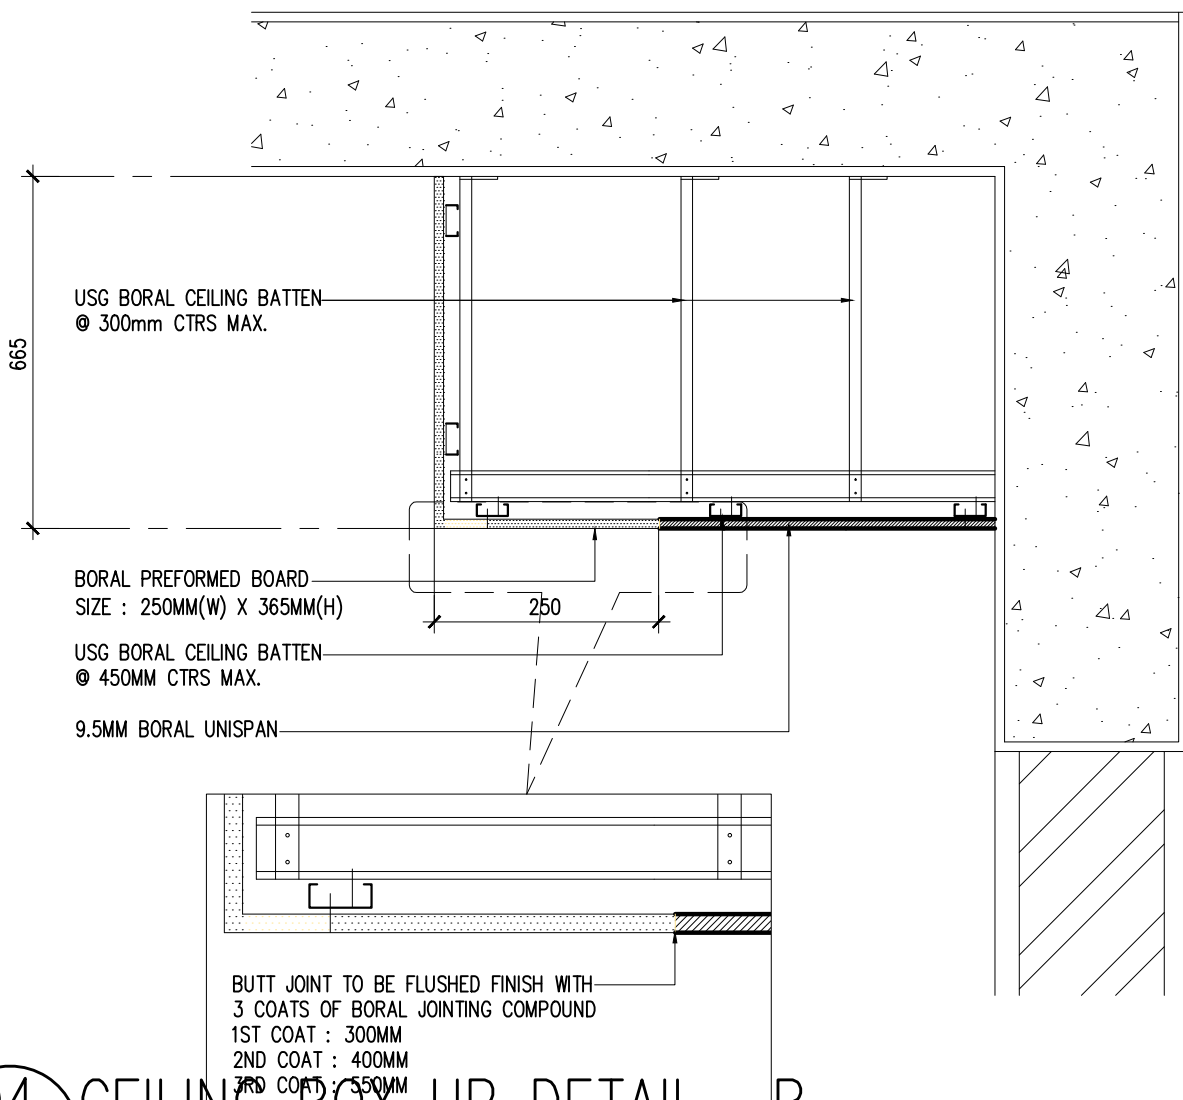


04 CEILING BOX UP DETAIL- B
710-17 SCALE = NTS (CEILING DROP 665MM)

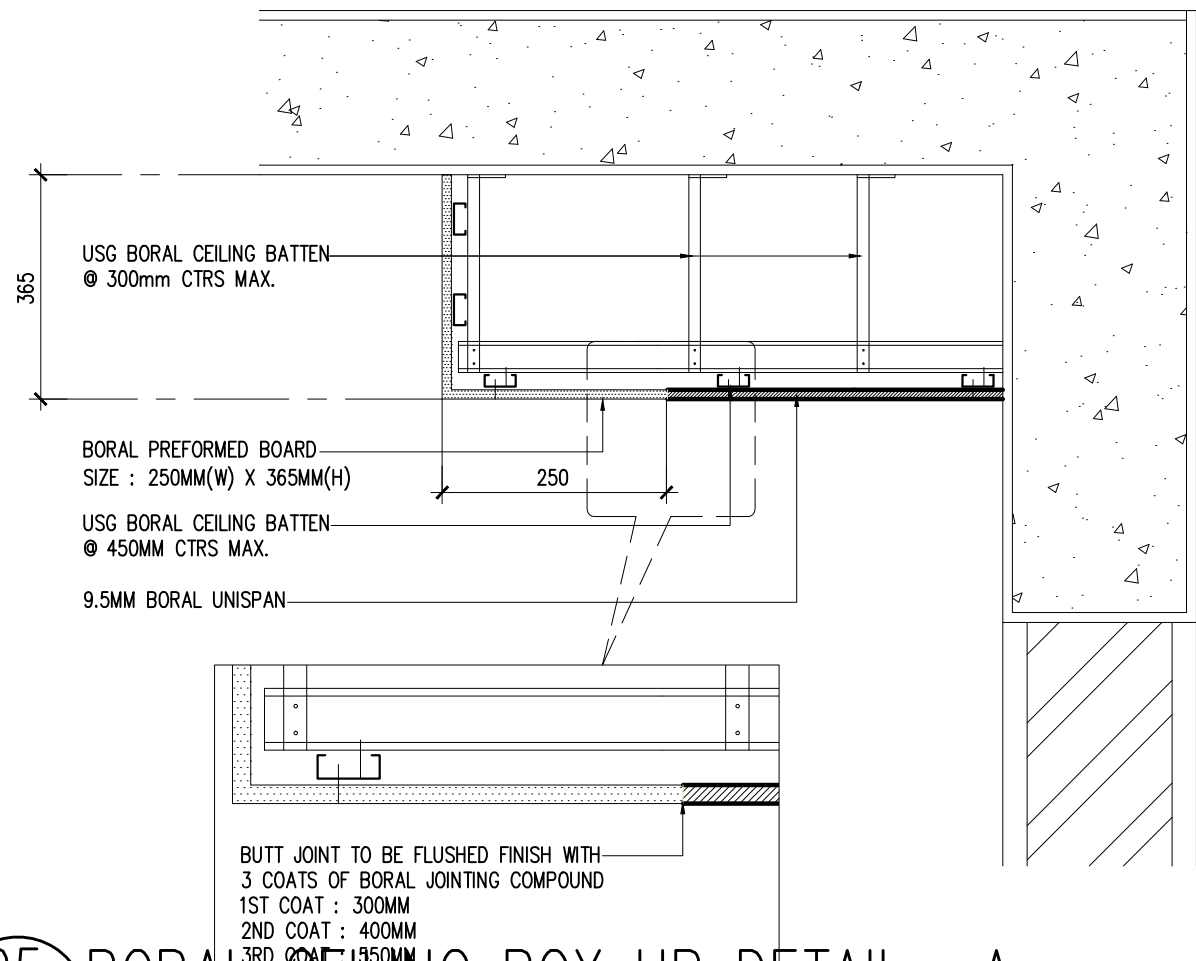


05 BORAL CEILING BOX UP DETAIL- A
710-17 SCALE = NTS (CEILING DROP 365MM)

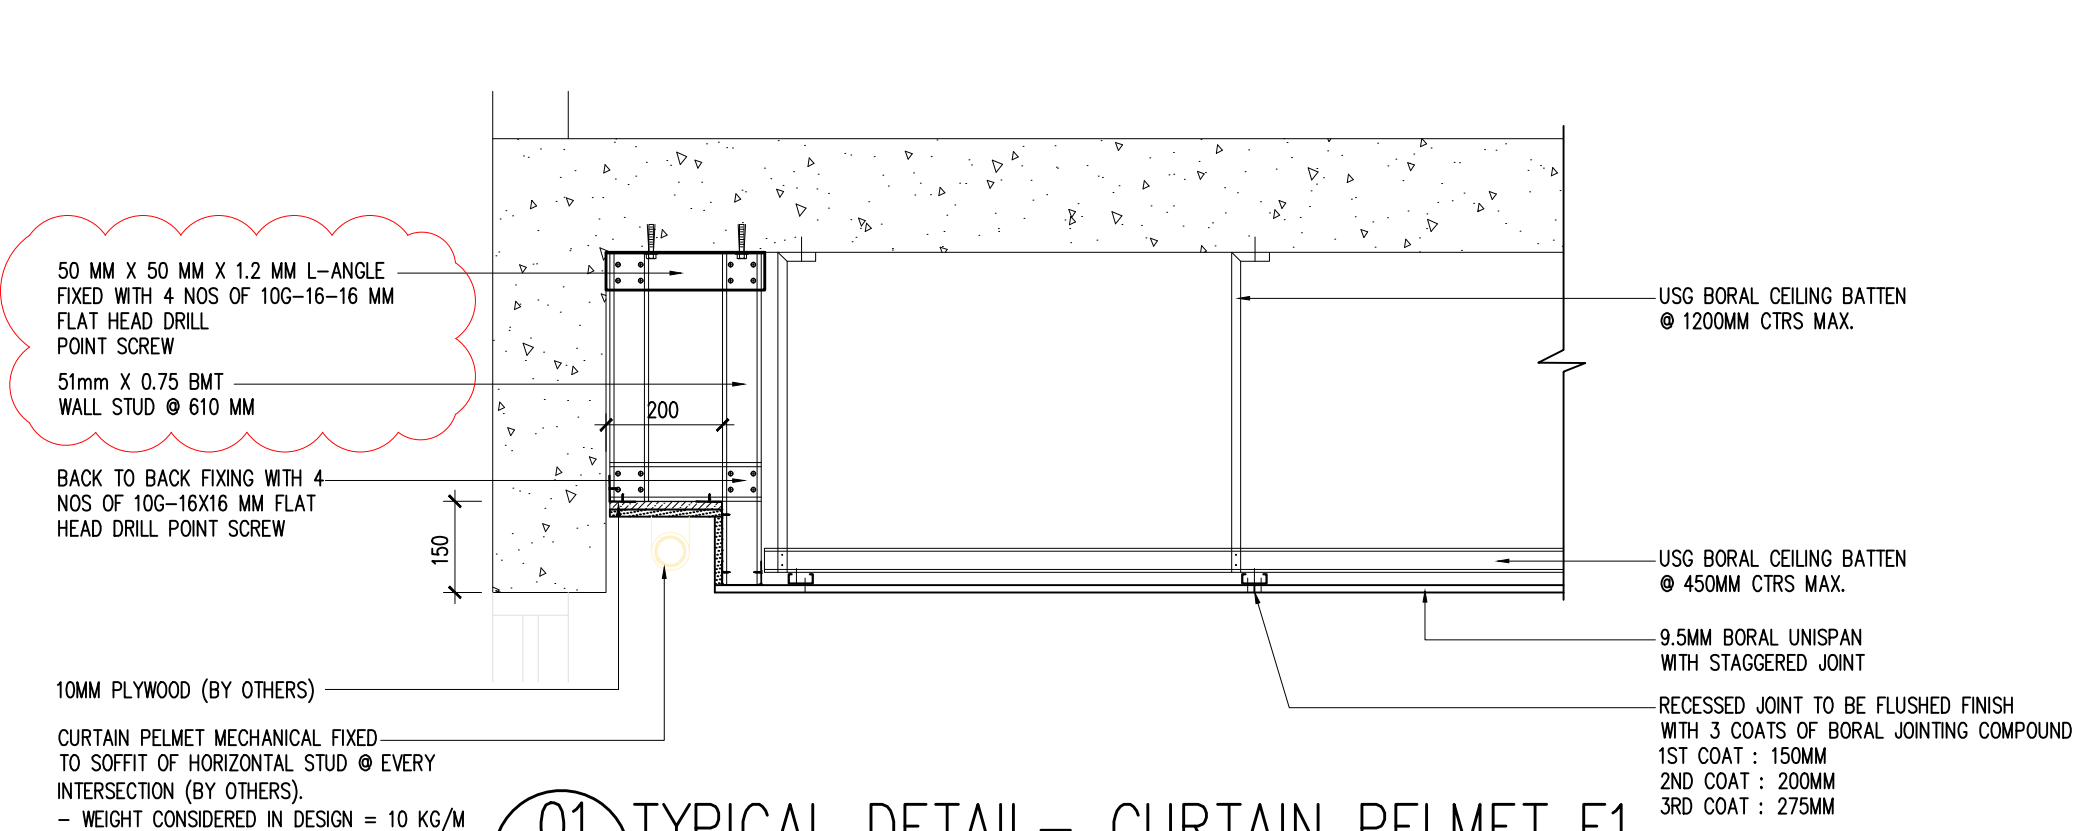

01 TYPICAL DETAIL- CURTAIN PELMET F1
710-17 SCALE = NTS

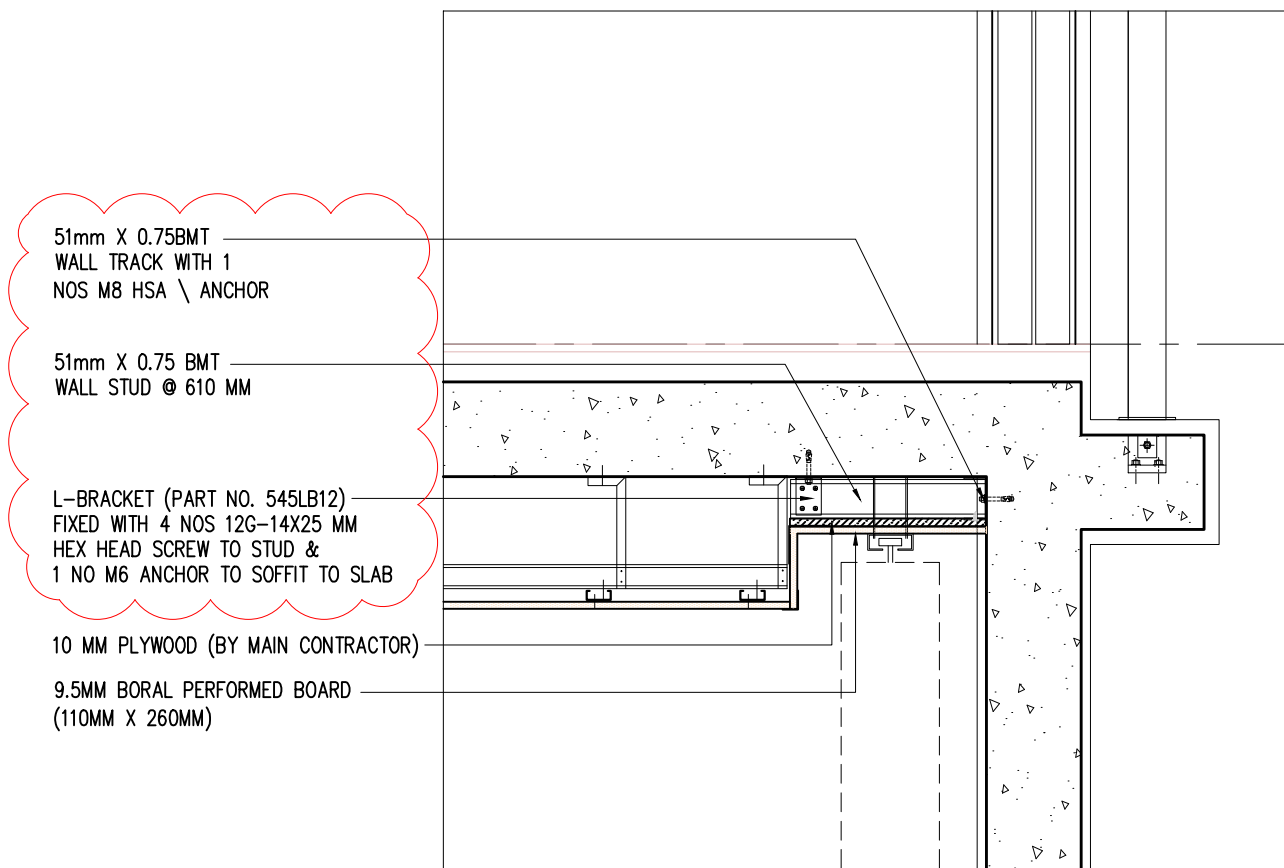


02 TYPICAL DETAIL- CURTAIN PELMET F2
710-17 SCALE = NTS

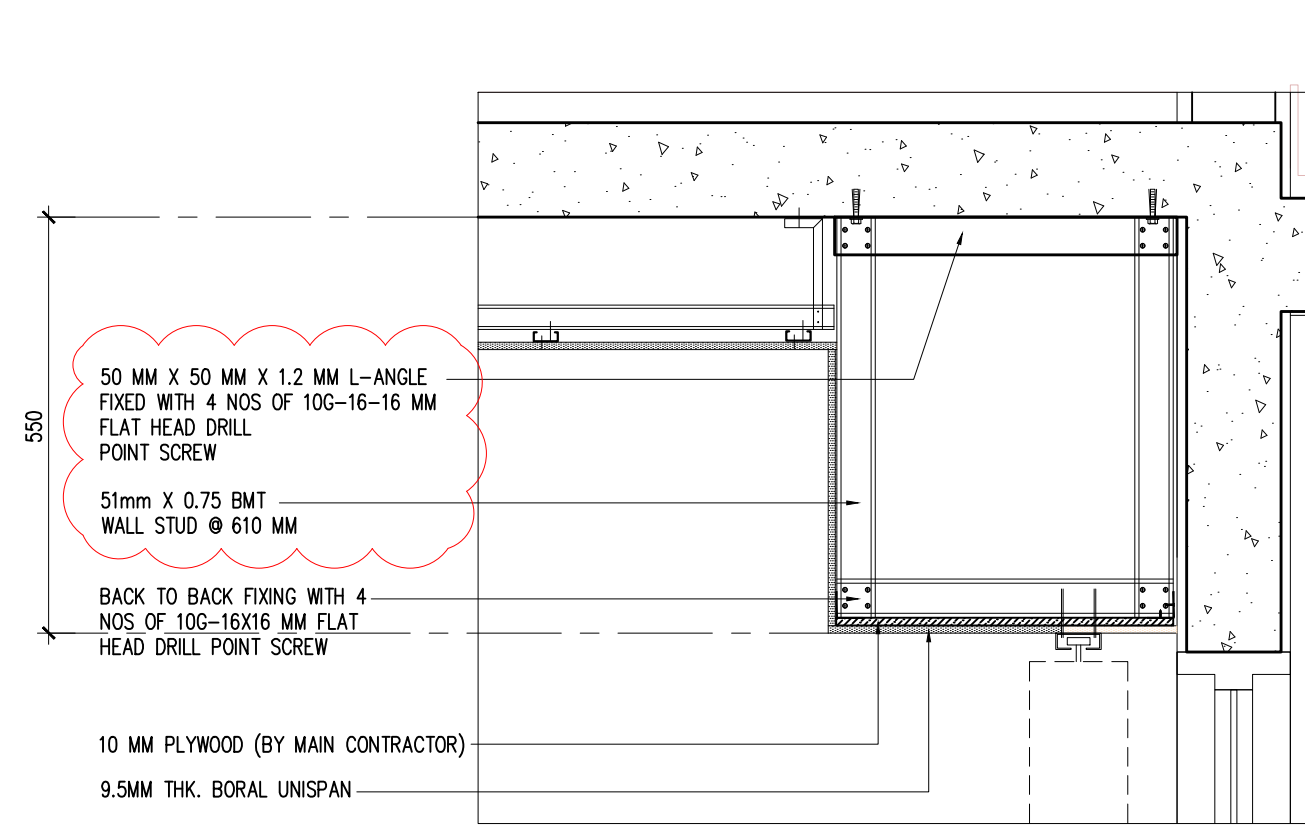

03 TYPICAL DETAIL- CURTAIN PELMET F3
710-17 SCALE = NTS

Hak Cipta Terpelihara. Tidak dibenarkan mencetak mana-mana bahagian ilustrasi dalam apa jua bentuk dan dengan apa cara pun samada secara elektronik, mencetak, mekanik, rakaman atau cara lain sebelum mendapat kebenaran bertulis dari BH YEW ARCHITECTS SDN. BHD.

REV.	DATE	DESCRIPTION	REMARK
A.01	30/01/2018	REVISED CEILING HEIGHT	
	04/09/2018	UPDATING DRAWING	abdul rahim
A.02	05/12/2018	AMENDMENT ON SPECIFICATION	Janice

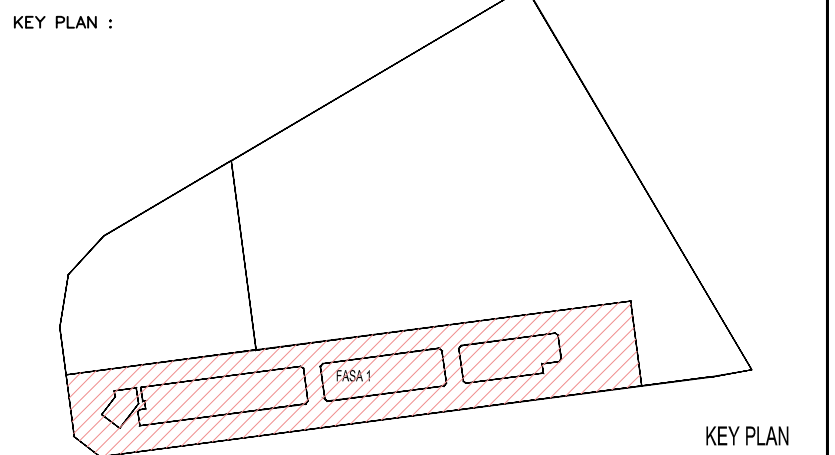

PROJECT TITLE :
CADANGAN MEMBINA PEMBANGUNAN BERCAMPUR DI ATAS LOT 21135, PERSIARAN CASSIA BARAT 3, MUKIM 13, SEBERANG PERAI SELATAN, PULAU PINANG YANG MENGANDUNGI:-
FASA 1
A. 2 BLOK PANGSAPURI PERKHIDMATAN 18 TINGKAT (612 UNIT)
B. KEDAI PEJABAT 3 TINGKAT (196 UNIT)
C. 5 TINGKAT TEMPAT LETAK KENDERAAN

UNTUK : TETUAN PARAMOUNT PROPERTY (PW) SDN. BHD

LAND OWNER & BUILDING OWNER :

NAMA : MR. OOI HUN PENG
JAWATAN : KETUA PEGAWAI EKSEKUTIF
NO IC : 650619-02-5311
ALAMAT : PARAMOUNT PROPERTY (PW) SDN. BHD
WISMA PARAMOUNT, 1A (1ST FLOOR), LORONG BLM 1/1,
BANDAR LAGUNA MERBOK, 08000 SUNGAI PETANI, KEDAH
NO. TEL : 604 - 441 9191 FAX : 604 - 441 9090

KITCHEN SPECIALIST :

QS CONSULTANT :

M&E CONSULTANT :
PERUNDING P.L.A.
Consulting Mechanical & Electrical Engineers.
8-01, WISMA PANTAI, TEL. NO. : (604) 3337990
JALAN WISMA PANTAI, NO IC : 650619-02-5311
12200 BUTTERWORTH, PENANG. E-MAIL : project@pla-group.com
FAX NO. : (604) 3317337

C&S CONSULTANT :
PERUNDING KELANA
CIVIL & STRUCTURAL ENGINEERS
Level 12, Unit 12(D), Wisma Boon Siew,
No.1, Penang Road, 10000 Penang.
Tel: 2622628, Fax: 2641618
(Company No. AS0232772-W)

DESIGN ARCHITECT :
ARCHITECTURE GROUP - STUDIO A
CPG CONSULTANTS PTE LTD
238B, THOMSON ROAD, #12-00 TOWER B
NOVENA SQUARE, SINGAPORE 307686
TEL : +65 6357 4469 FAX : +65 6357 4469

ARCHITECT :
BH YEW ARCHITECT (SP/Y61)
15TH FLOOR, BANGUNAN AMMETLIFE
NO.1, JALAN LUMUT, 50400 KUALA LUMPUR
TEL: (03) 4043-1346 FAX: (03) 4043-1349
EMAIL: ybhw@nrsb.com.my

LEMBAGA
ARKITEK
MALAYSIA
Ar. YEW BU HWA
ARKITEK
No Pendaftaran LAM: A/Y61
Saya mengesahkan bahawa pelan-pelan yang dihantar adalah mengikut Undang-Undang Kecil Bangunan Seragam 1986 dan Undang-Undang Kecil Bangunan Seragam (Indoor) 2007 [UKBS2007] dan piawai-piawai serta persendirian-persendirian dan piawai-piawai Pelancongan Selangor Perai. Saya mengesahkan bahawa kerja-kerja pembinaan akan dijalankan dibawah perijinan saya. Saya mengesahkan dan menguak bahawa pelan-pelan bangunan adalah setara dengan pelan-kabaran merancang yang diluluskan dan akan mematuhi usulan serta syarat-syarat jabatan teknik.

CONSTRUCTION DRAWING
NOVEMBER 2018

LUKISAN :

CEILING DETAIL
CEILING AND ELECTRICAL LEGEND

SCALE:	AS SHOWN	CAD NO:	557_CA-710-18
DRAWN BY:	ABDUL RAHIM	CHECKED BY:	JANICE
ORIGINATOR ACRONYM	BH YEW	PROJECT NO.	55714
DWG STATUS	CA	BLOCK	-
DWG NO.	710	DWG NO.	18
REVISION	A.02	DISCIPLINE	ARCH