


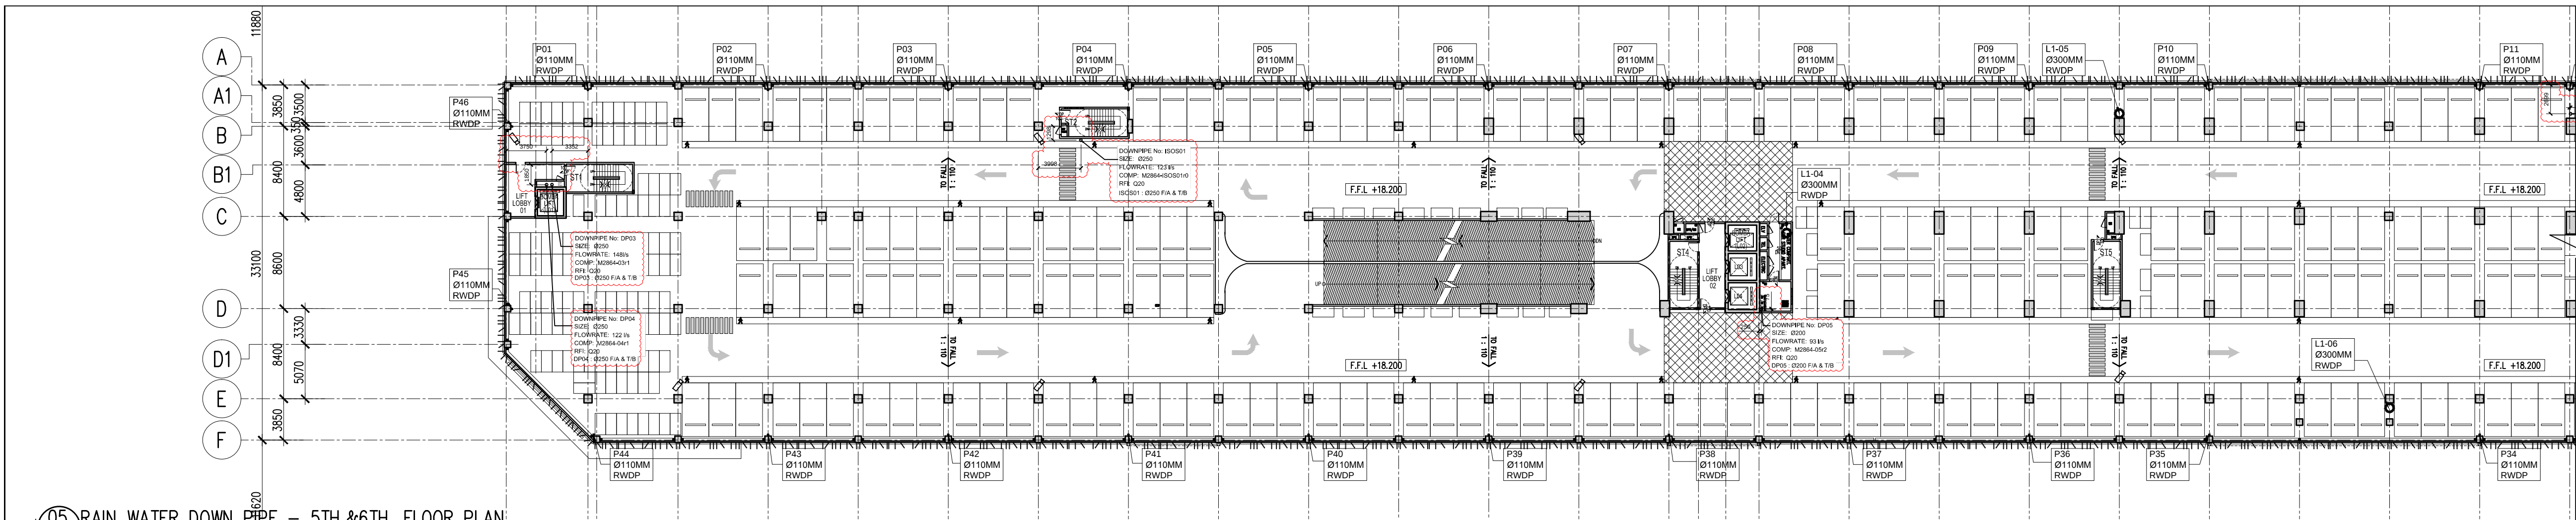


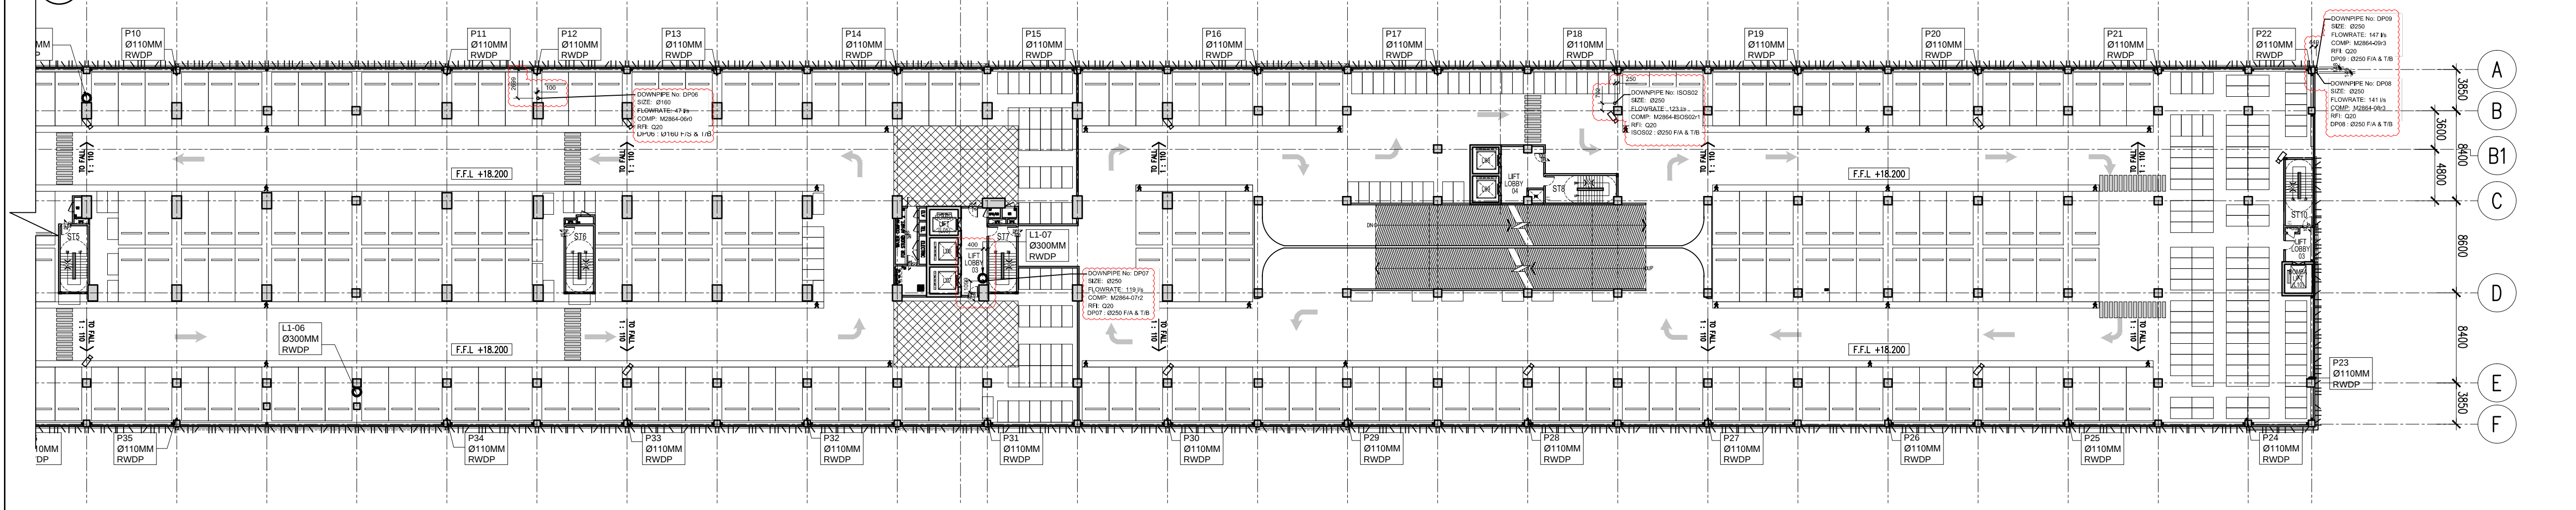

05 RAIN WATER DOWN PIPE - 5TH.&6TH. FLOOR PLAN
543 NOT TO SCALE

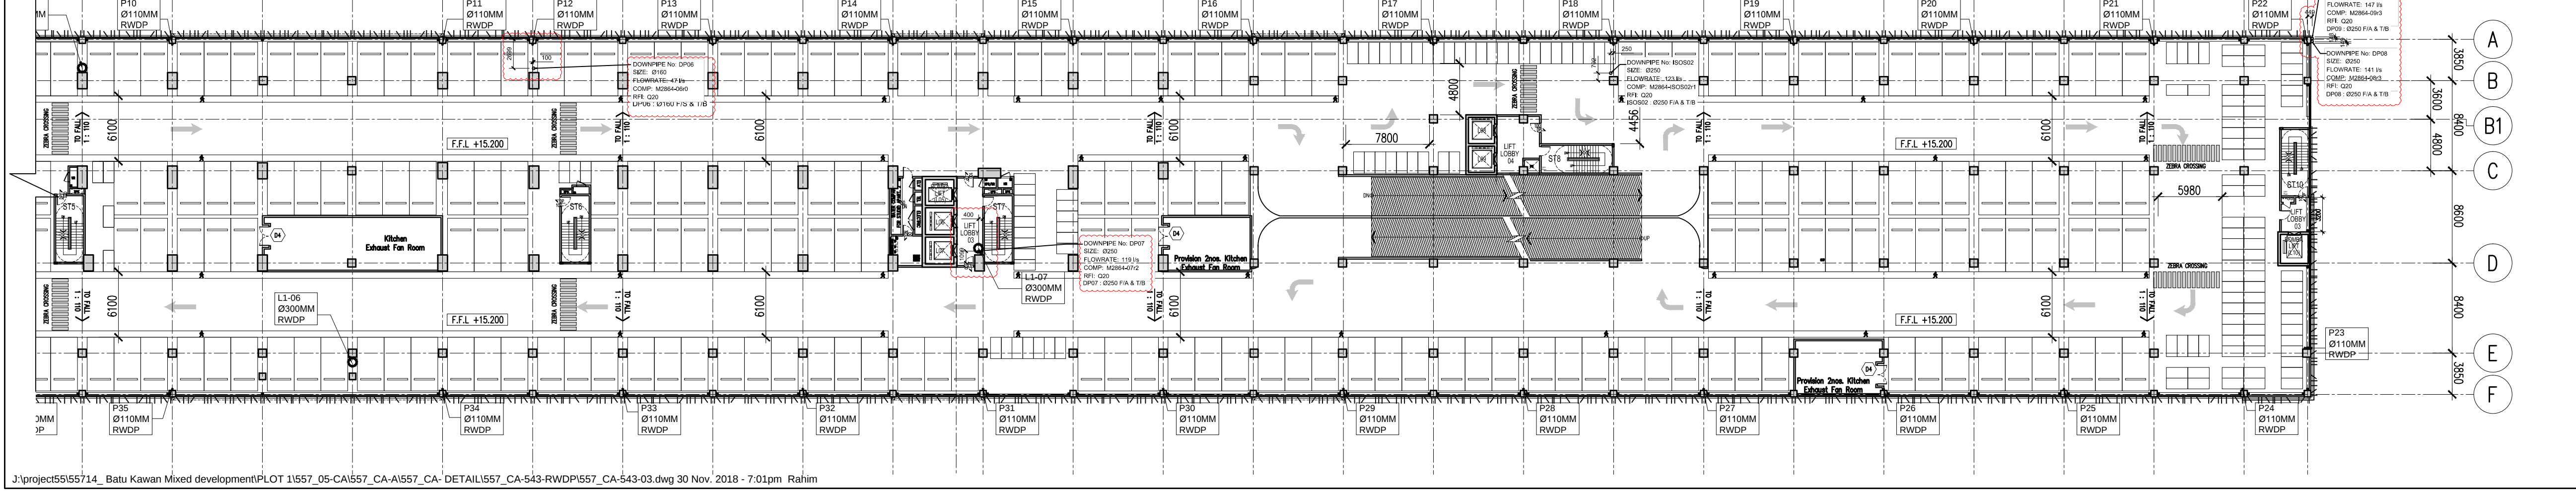


04 RAIN WATER DOWN PIPE - 4TH. FLOOR PLAN
543 NOT TO SCALE

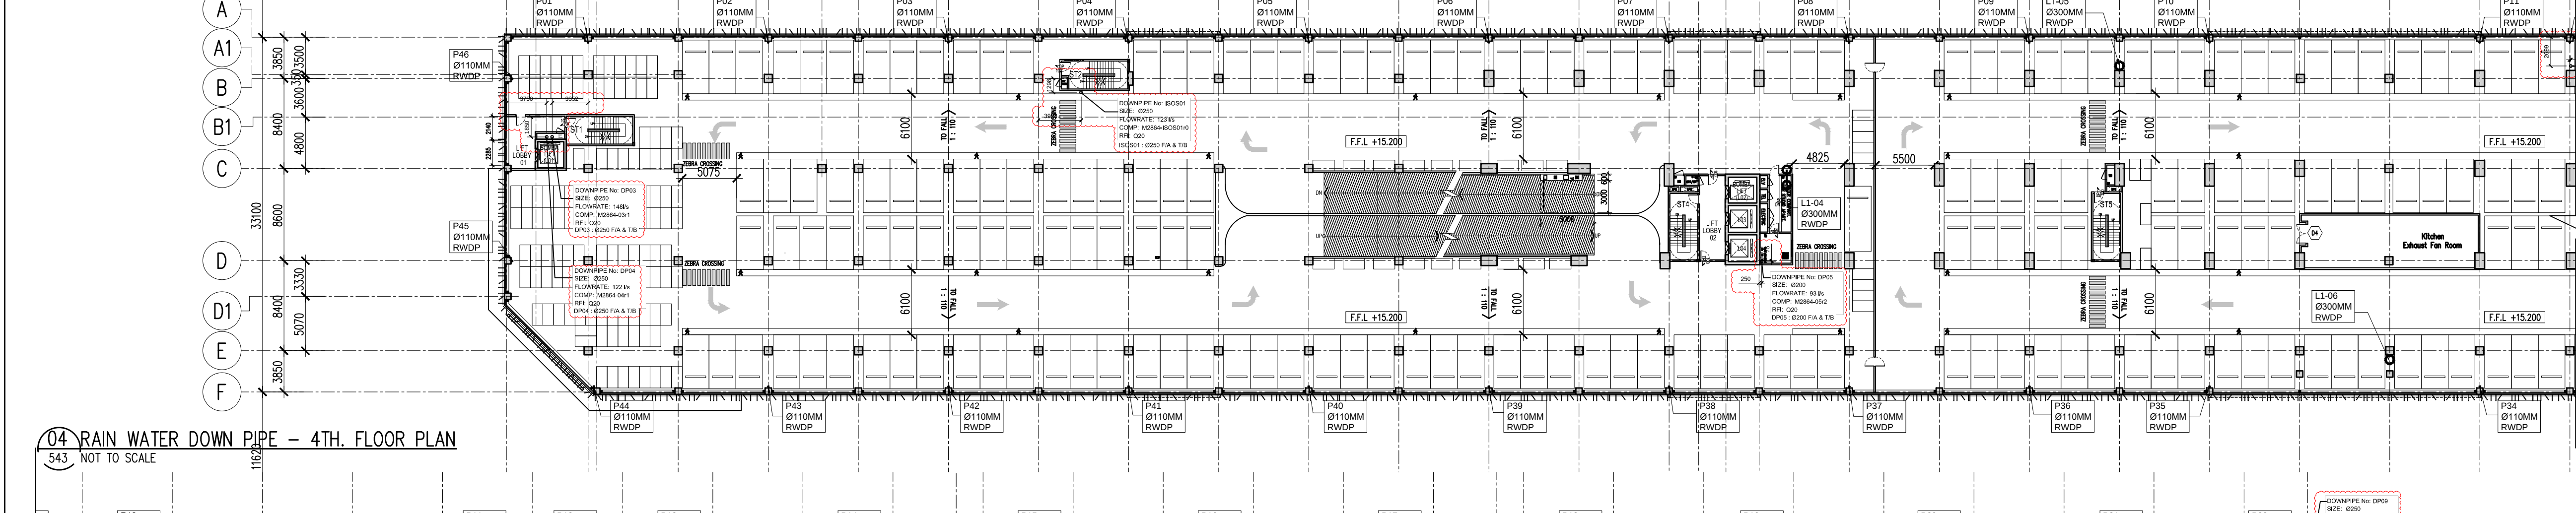

Hak Cipta Terpelihara. Tidak dibenarkan mencetak mana-mana bahagian ilustrasi dalam apa jua bentuk dan dengan apa cara pun samada secara elektronik, mencetak, mekanik, rakaman atau cara lain sebelum mendapat kebenaran bertulis dari BH YEW ARCHITECTS SDN. BHD.

REV.	DATE	DESCRIPTION	REMARK
03/09/2018	03/09/2018	UPDATING DRAWING	abdul rahim
A.01	12/11/2018	UPDATING SYFON DWG AS PER EMAIL (28.03.2018)	abdul rahim

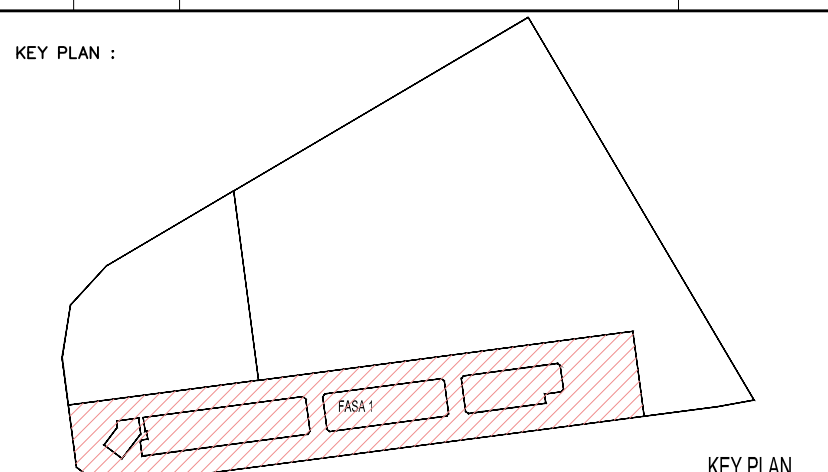

PROJECT TITLE :
CADANGAN MEMBINA PEMBANGUNAN BERCAKUP DI ATAS LOT 21135, PERSIARAN CASSIA BARAT 3, MUKIM 13, SEBERANG PERAI SELATAN, PULAU PINANG YANG MENGANDUNGI:-
FASA 1
A. 2 BLOK PANGSAPURI PERKHIDMATAN 18 TINGKAT (612 UNIT)
B. KEDAI PEJABAT 3 TINGKAT (196 UNIT)
C. 5 TINGKAT TEMPAT LETAK KENDERAAN

UNTUK : TETUAN PARAMOUNT PROPERTY (PW) SDN. BHD

LAND OWNER & BUILDING OWNER :

NAMA : MR. OI HUN PENG
JAWATAN : KETUA PECAKAWAI EKSEKUTIF
NO IC : 850819-02-5311
ALAMAT : PARAMOUNT PROPERTY (PW) SDN. BHD
WISMA PARAMOUNT, 1A (1ST FLOOR), LORONG BLM 1/1,
BANDAR LAGUNA MERBOK, 08000 SUNGAI PETANI, KEDAH
NO. TEL : 604 - 441 9191 FAX : 604 - 441 9090

KITCHEN SPECIALIST :

QS CONSULTANT :

M&E CONSULTANT :

PERUNDING P.L.A.

Consulting Mechanical & Electrical Engineers.

8-01, WISMA PANTAI, TEL. NO. : (604) 3337990
JALAN WISMA PANTAI, FAX NO. : (604) 3317337
12200 BUTTERWORTH, PENANG. E-MAIL : project@pla-group.com

C&S CONSULTANT :

PERUNDING KELANA

CIVIL & STRUCTURAL ENGINEERS

Level 12, Unit 12(D), Wisma Boon Siew,
No.1, Penang Road, 10000 Penang.
Tel: 2622628, Fax: 2641618
(Company No. AS0232772-W)

DESIGN ARCHITECT :

ARCHITECTURE GROUP - STUDIO A

CPG CONSULTANTS PTE LTD

238B, THOMSON ROAD, #12-02 TOWER B
NOVENA SQUARE, SINGAPORE 307685
TEL : +65 6357 4468 FAX : +65 6357 4469

ARCHITECT :

BH ARCHITECT (SP/Y61)

15TH FLOOR, BANGUNAN AMMETULIFE
NO.1, JALAN LUMUT, 50400 KUALA LUMPUR
TEL: (03) 4043-1346 FAX: (03) 4043-1349
EMAIL: yhw@nrasb.com.my

CONSTRUCTION DRAWING

NOVEMBER 2018

LUKSISAN :

RAIN WATER DOWN PIPE DETAIL

-4TH. FLOOR PLAN

-5TH & 6TH. FLOOR PLAN

SCALE: AS SHOWN

CAD NO: 557_CA-543-03

DRAWN BY: JANICE

CHECKED BY: 30 NOV 2018

ORIGINATOR ACRONYM PROJECT NO. DISCIPLINE

BH YEW 55714 ARCH

DWG STATUS BLOCK BLOCK DWG NO. DWG NO. REVISION

CA - - 543 03 A.01