


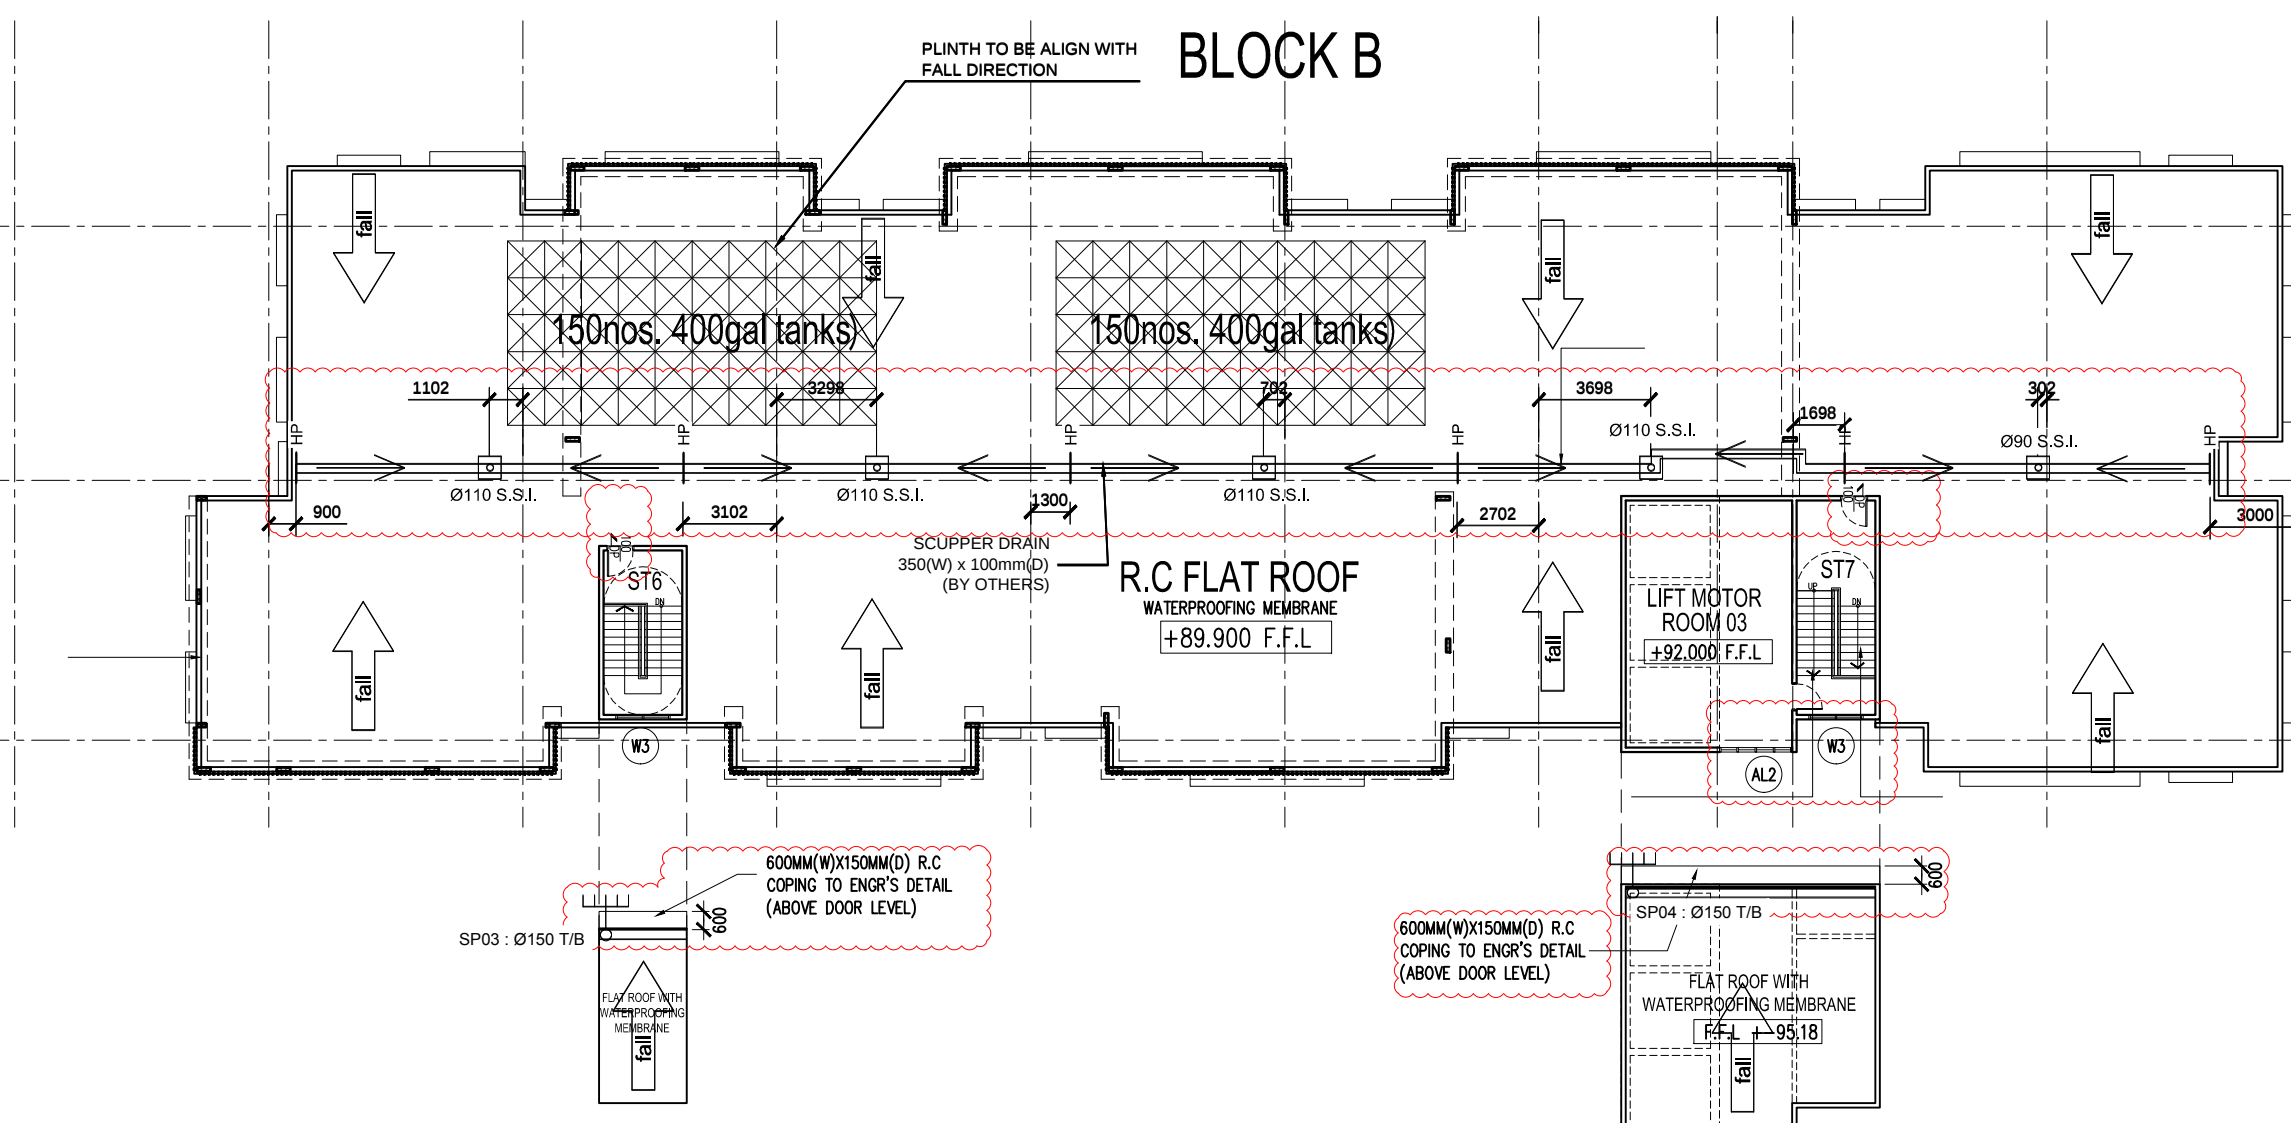
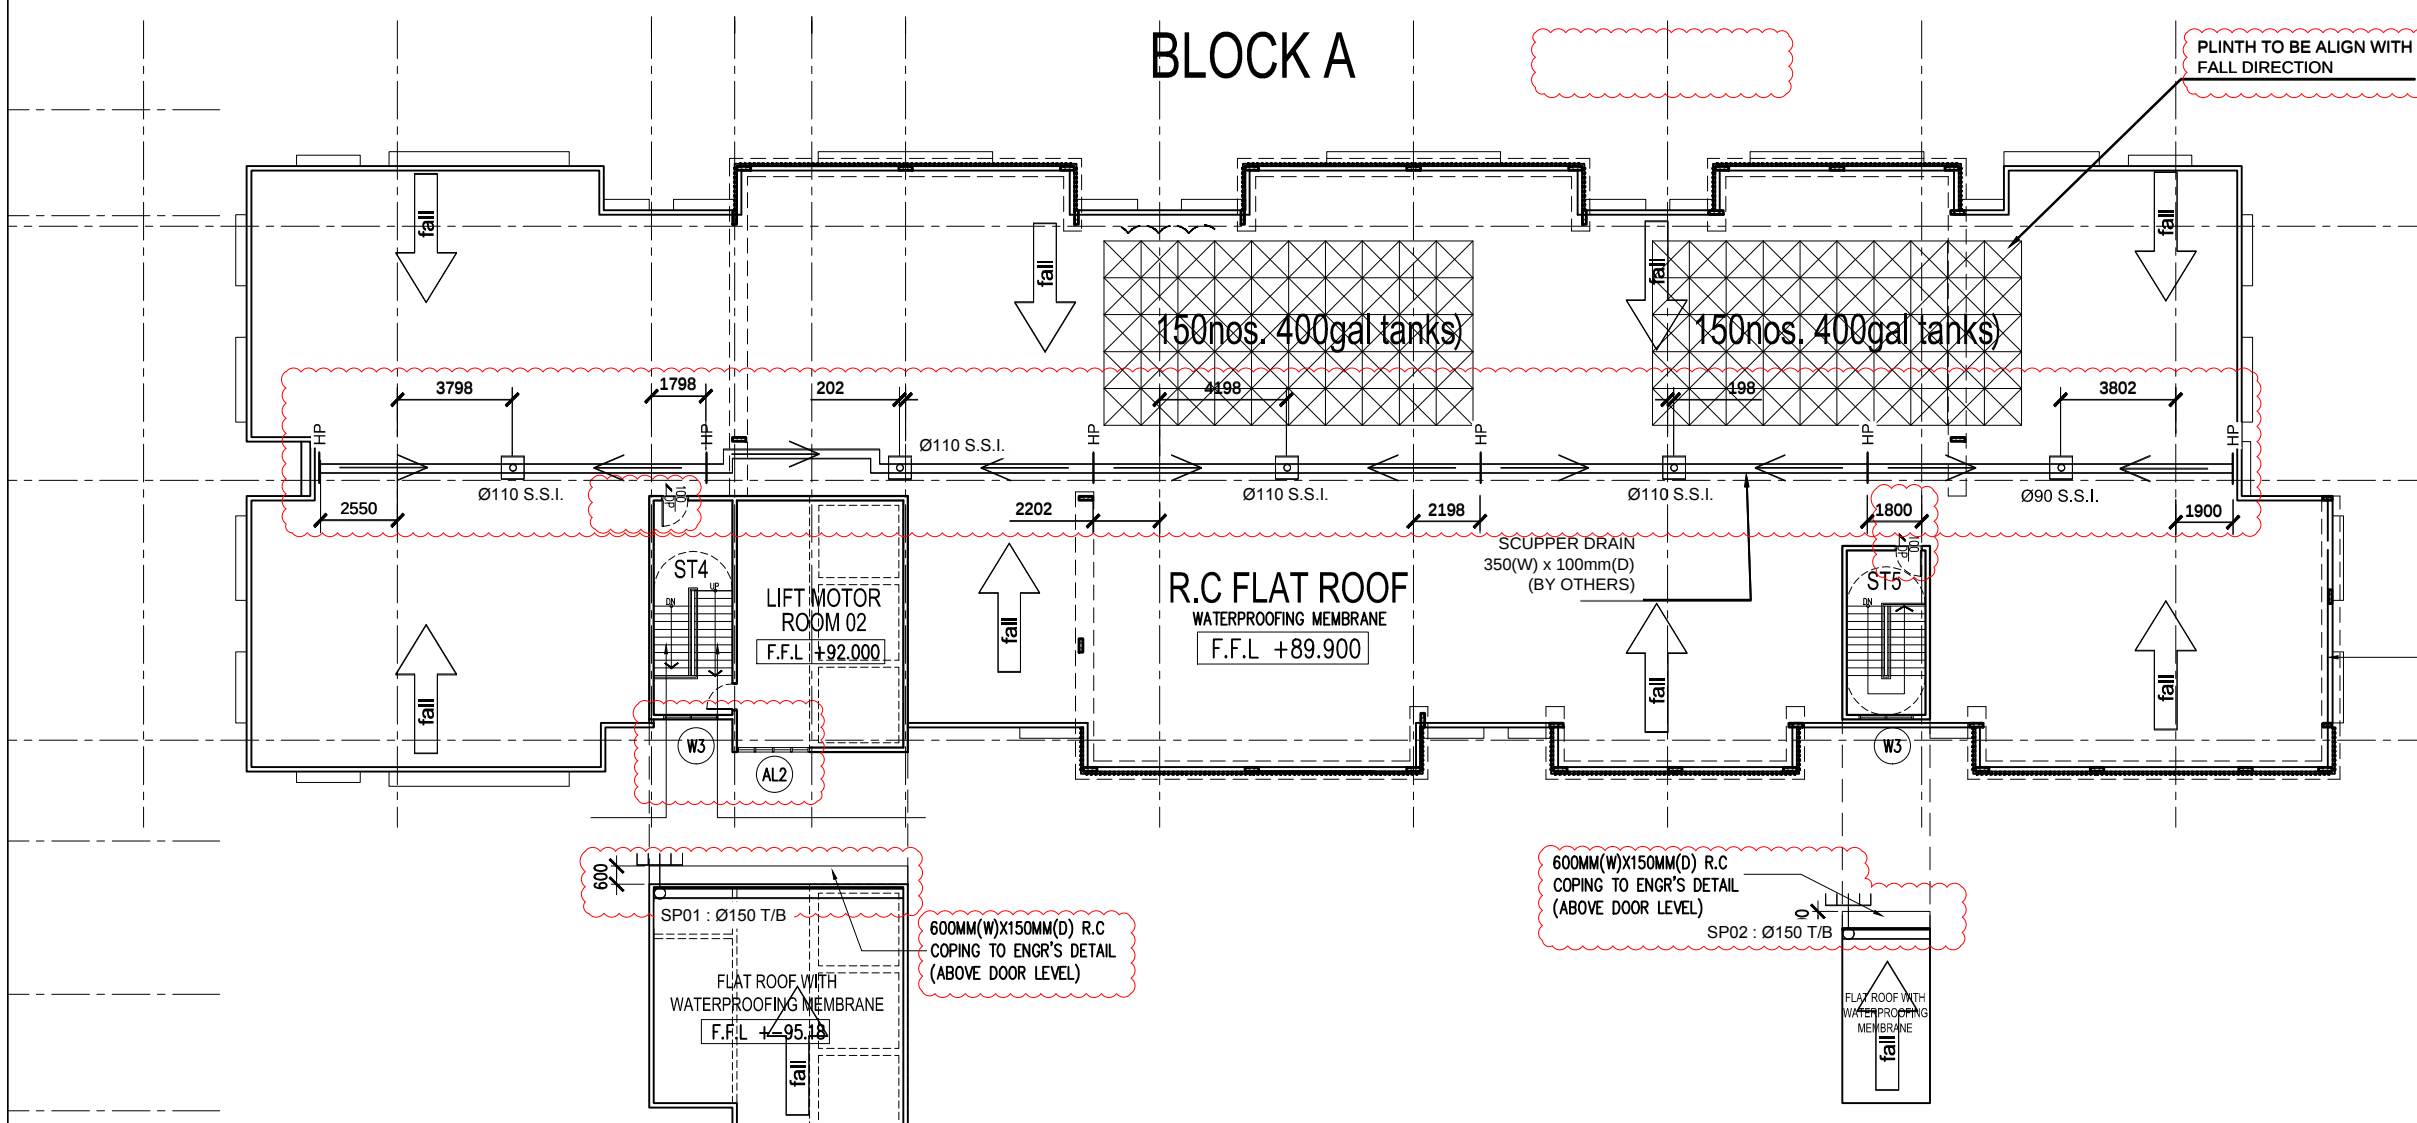
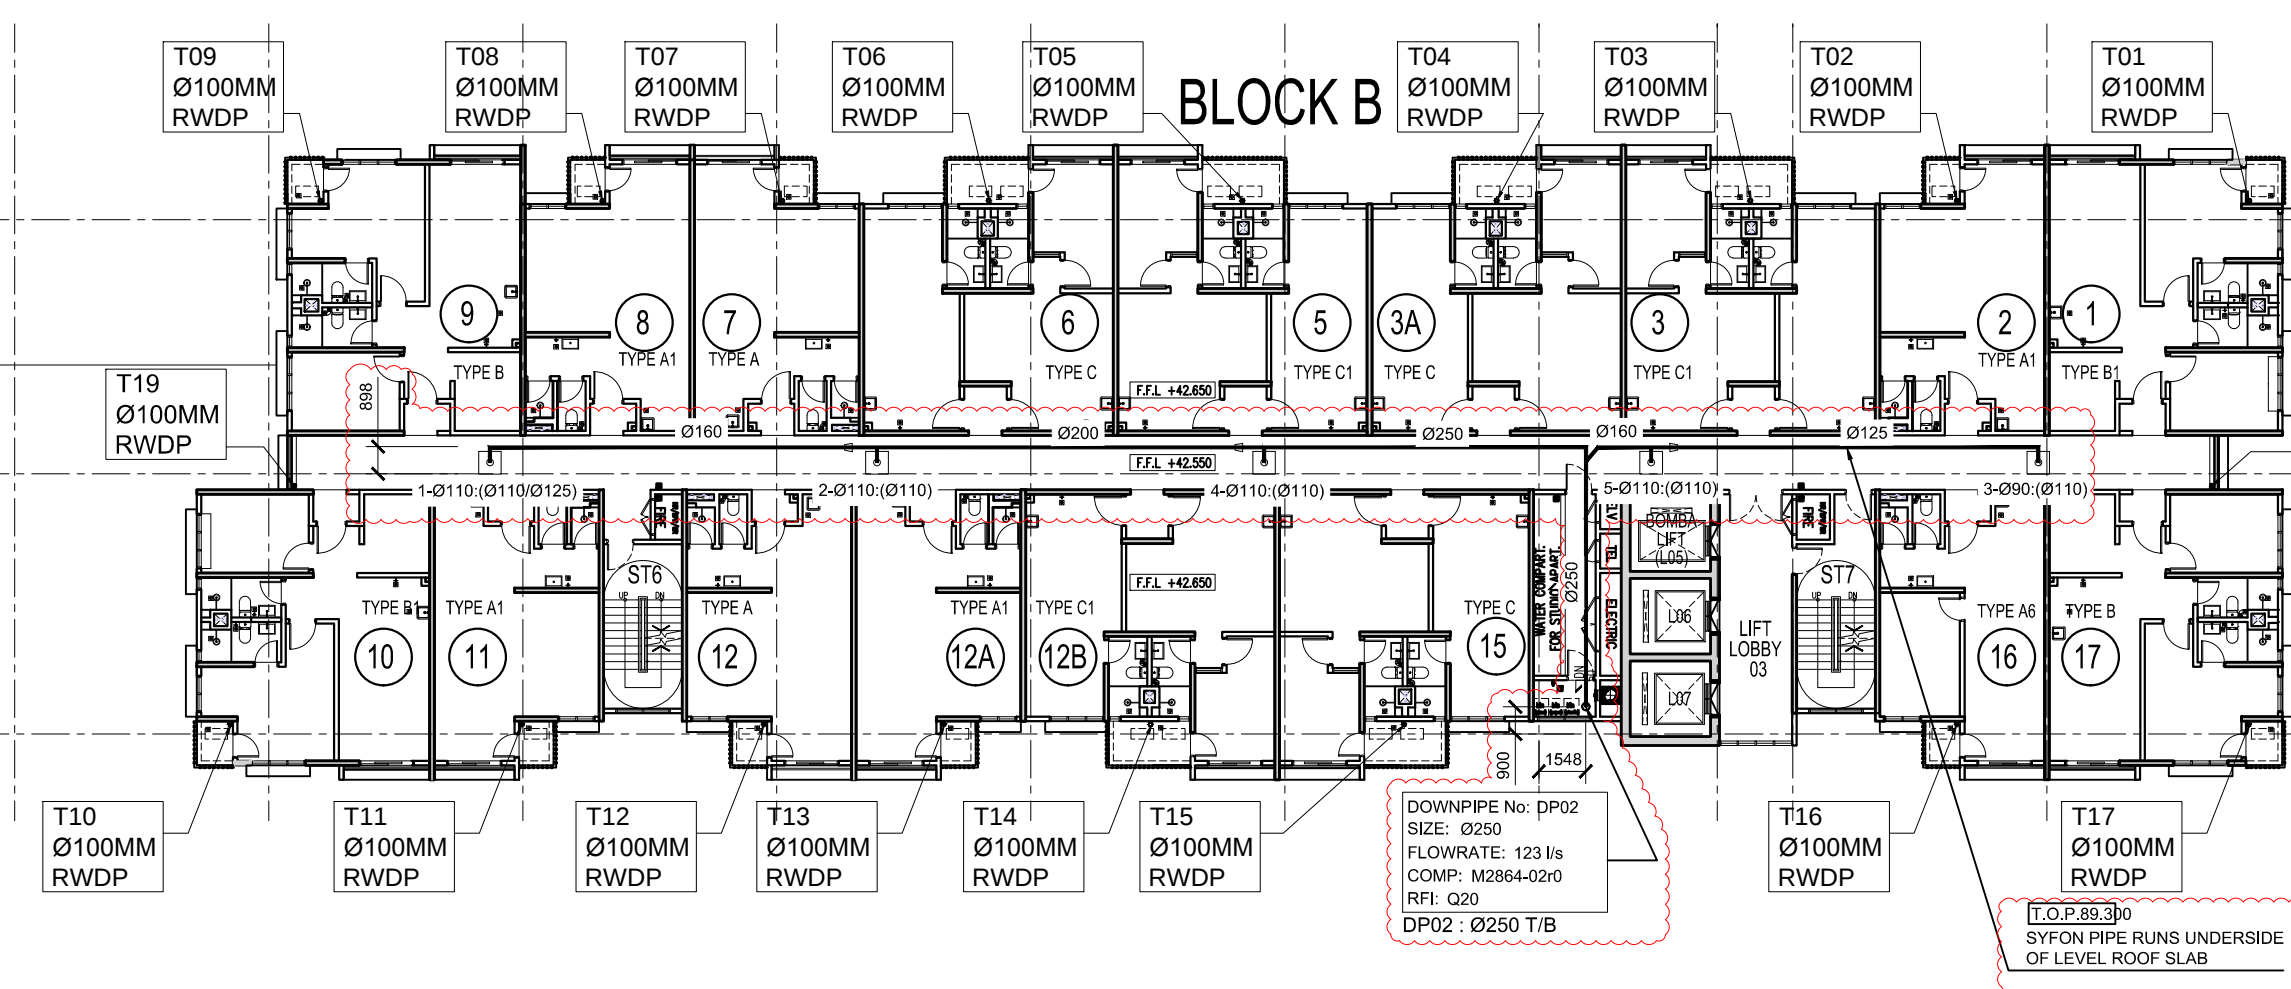


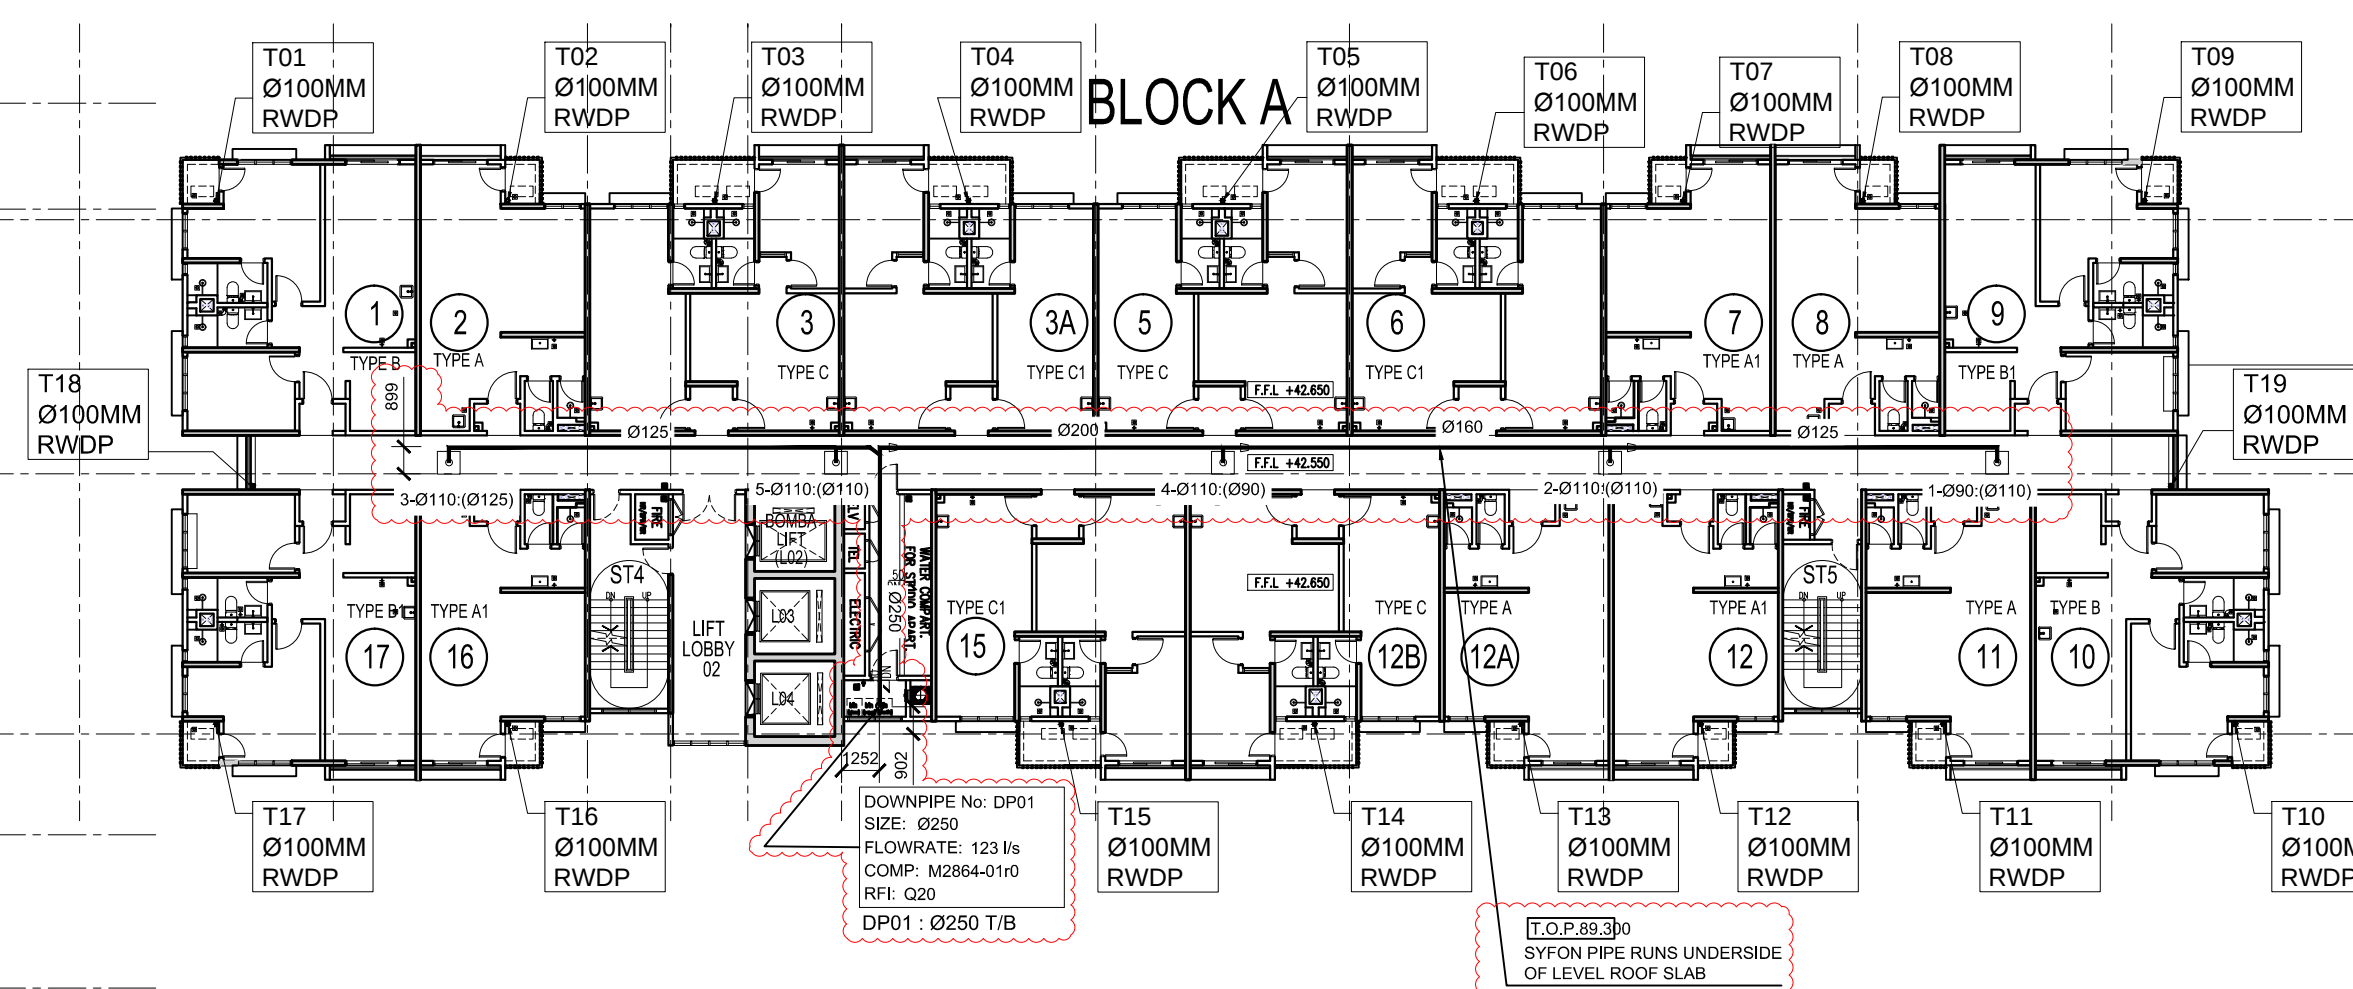

12 RAIN WATER DOWN PIPE – ROOF PLAN
543 SCALE = 1 : 250

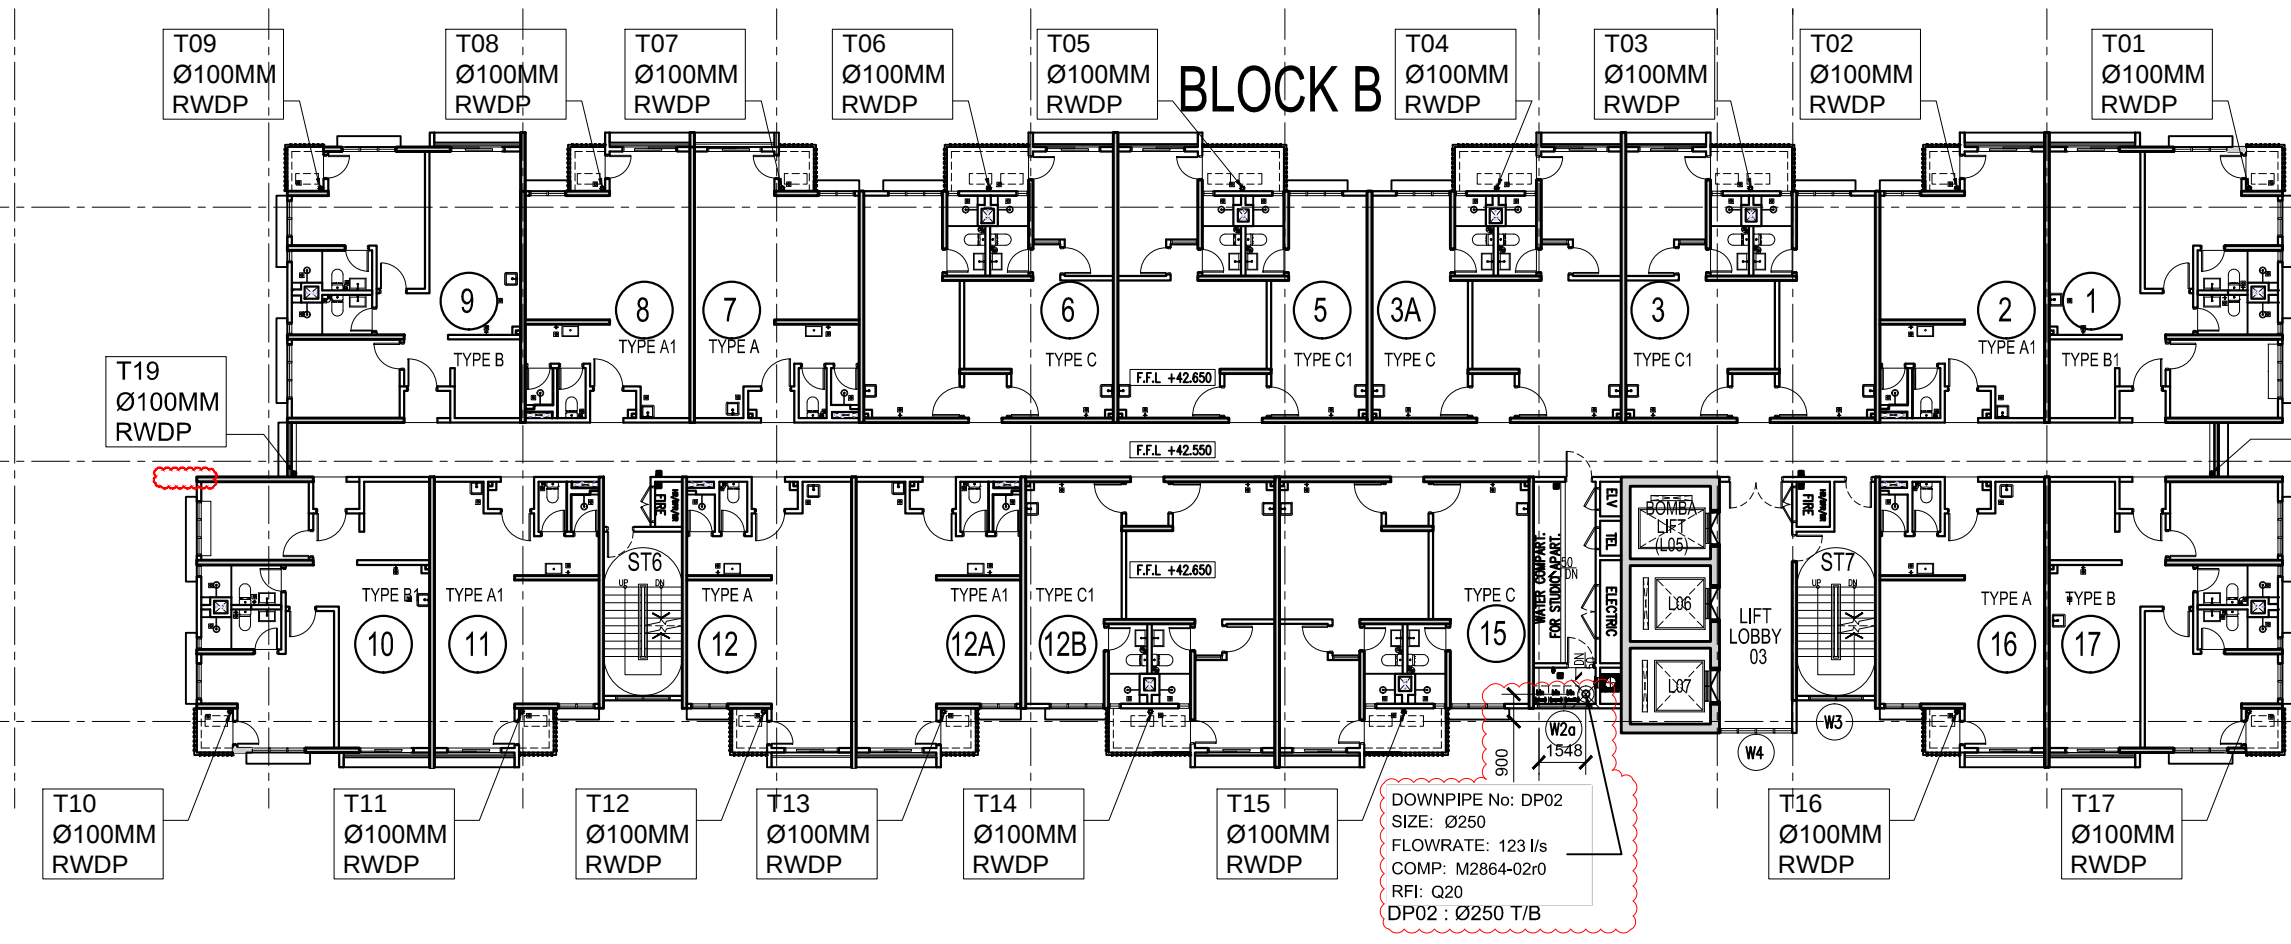

10 RAIN WATER DOWN PIPE – 26TH. FLOOR PLAN
543 SCALE = 1 : 250

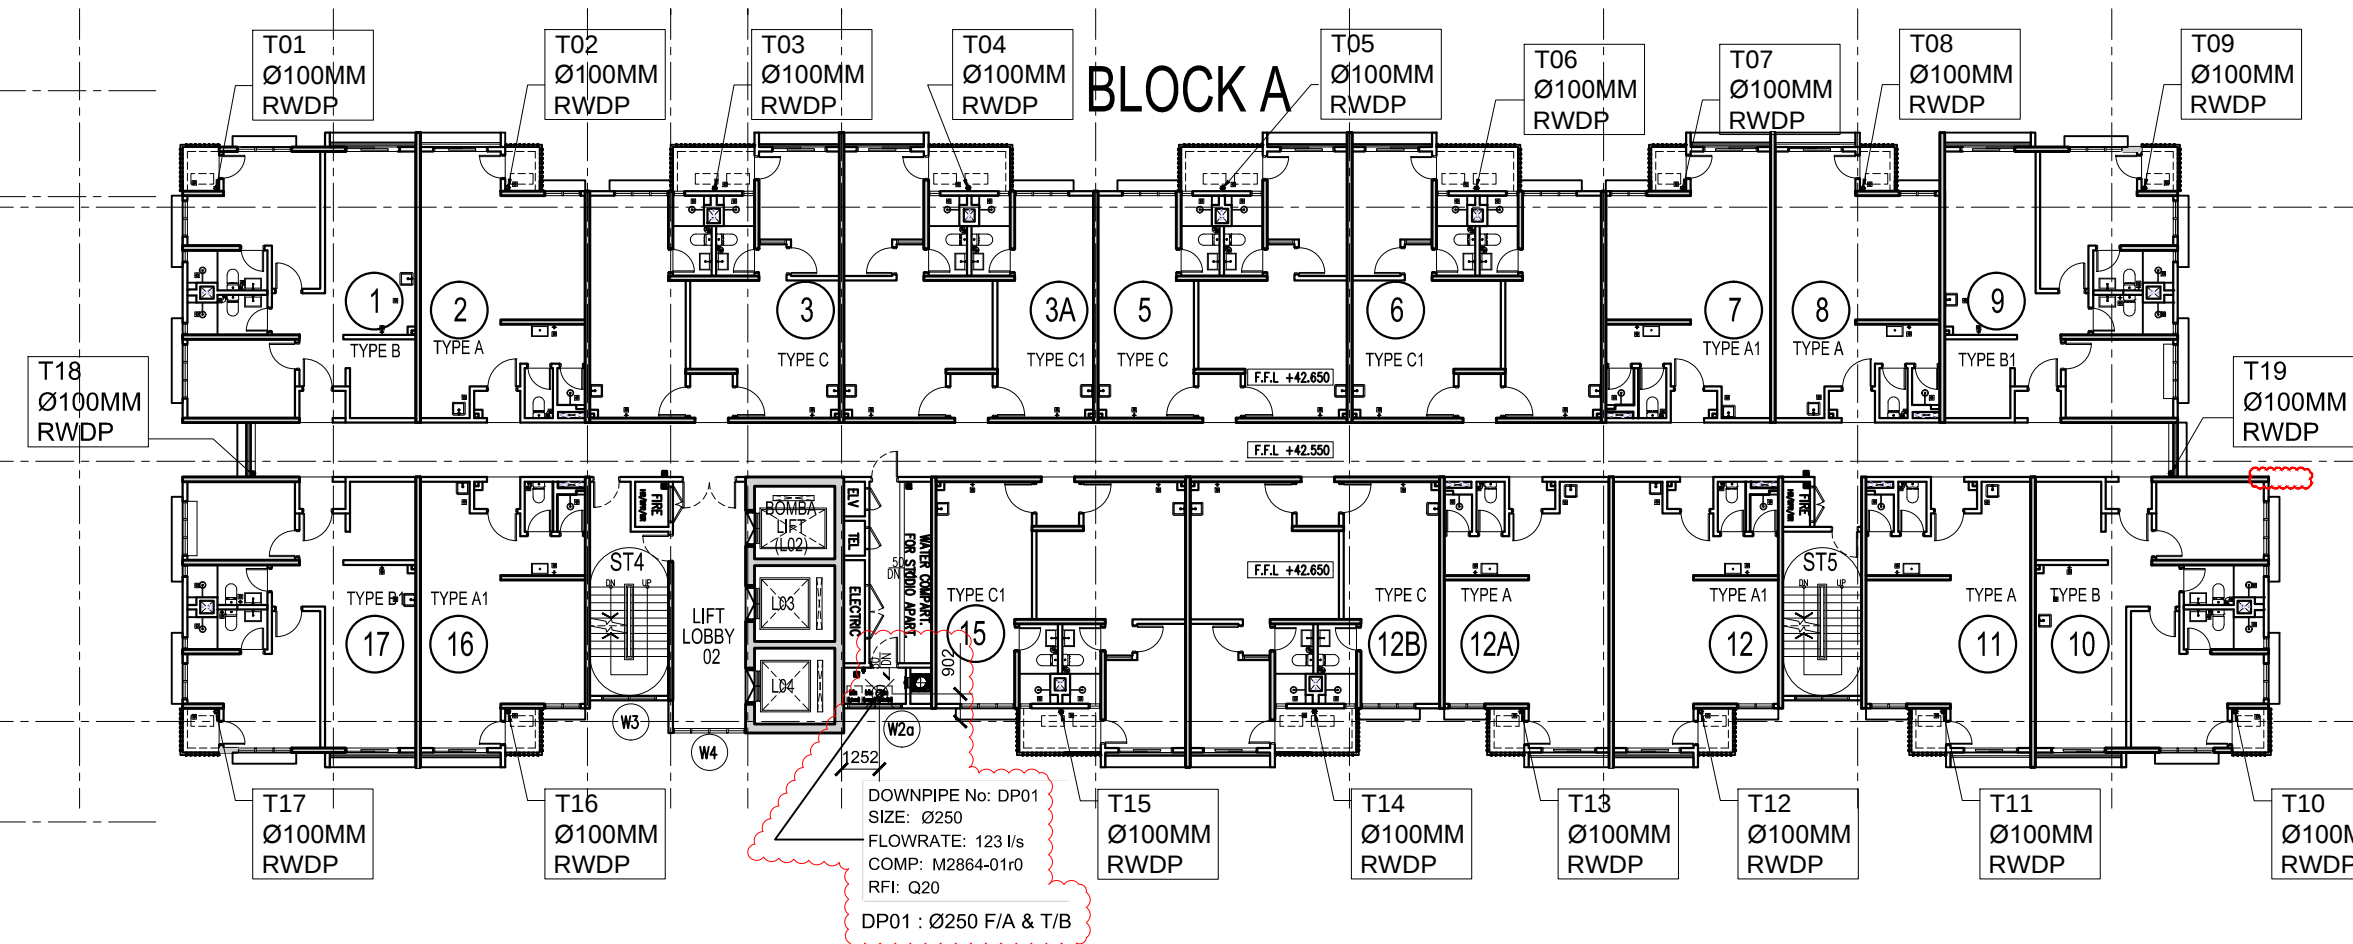

10 RAIN WATER DOWN PIPE – 11TH. – 25TH. FLOOR PLAN
543 SCALE = 1 : 250

Hak Cipta Terpelihara. Tidak dibenarkan mencetak mana-mana bahagian ilustrasi dalam apa jua bentuk dan dengan apa cara pun samada secara elektronik, mencetak, mekanik, rakaman atau cara lain sebelum mendapat kebenaran bertulis dari BH YEW ARCHITECTS SDN. BHD.

REV.	DATE	DESCRIPTION	REMARK
03/09/2018	03/09/2018	UPDATING DRAWING	abdul rahim
A.01	12/11/2018	UPDATING SYFON DWG AS PER EMAIL (28.03.2018)	abdul rahim

KEY PLAN :

PROJECT TITLE :

CADANGAN MEMBINA PEMBANGUNAN BERCAMPUR DI ATAS LOT 21135, PERSIARAN CASSIA BARAT 3, MUKIM 13, SEBERANG PERAI SELATAN, PULAU PINANG YANG MENGANDUNGI:-

FASA 1

- 2 BLOK PANGSAPURI PERKHIDMATAN 18 TINGKAT (612 UNIT)
- KEDAI PEJABAT 3 TINGKAT (196 UNIT)
- 5 TINGKAT TEMPAT LETAK KENDERAAN

UNTUK : TETUAN PARAMOUNT PROPERTY (PW) SDN. BHD

LAND OWNER & BUILDING OWNER :

NAMA : MR. OOI HUN PENG
JAWATAN : KETUA PEJABAT EKSEKUTIF
NO IC : 650619-02-5311
ALAMAT : PARAMOUNT PROPERTY (PW) SDN. BHD, WISMA PARAMOUNT, 1A (1ST FLOOR), LORONG BLM 1/1, BANDAR LAGUNA MERBOK, 08000 SUNGAI PETANI, KEDAH
NO. TEL : 604 - 441 9191 FAX : 604 - 441 9090

KITCHEN SPECIALIST :

QS CONSULTANT :

M&E CONSULTANT : PERUNDING P.L.A. Consulting Mechanical & Electrical Engineers. 8-01, WISMA PANTAI, JALAN WISMA PANTAI, 12200 BUTTERWORTH, PENANG. E-MAIL : project@pila-group.com

C&S CONSULTANT : PERUNDING KELANA CIVIL & STRUCTURAL ENGINEERS Level 12, Unit 12(D), Wisma Boon Siew, No.1, Penang Road, 10000 Penang. Tel: 2622628, Fax: 2641618 (Company No. AS0232772-W)

DESIGN ARCHITECT : ARCHITECTURE GROUP - STUDIO A CPG CONSULTANTS PTE LTD 2388, THOMSON ROAD, #12-00 TOWER B NOVENA SQUARE, SINGAPORE 307685 TEL : +65 6357 4468 FAX : +65 6357 4469

ARCHITECT : BH YEW ARCHITECT (SP/Y61) 15TH FLOOR, BANGUNAN AMMETULFE NO.1, JALAN LUMUT, 50400 KUALA LUMPUR TEL: (03) 4043-1346 FAX: (03) 4043-1349 EMAIL: ybwa@nrsb.com.my

CONSTRUCTION DRAWING
NOVEMBER 2018

LUKSAN :

RAIN WATER DOWN PIPE DETAIL
-11TH. – 25TH. FLOOR PLAN
-26TH. FLOOR PLAN
-ROOF FLOOR PLAN

SCALE:	CAD NO:
AS SHOWN	557_CA-543-06

DRAWN BY:	CHECKED BY:	DATE:
abdul rahim	JANICE	30 NOV 2018

ORIGINATOR ACRONYM	PROJECT NO.	DISCIPLINE
BH YEW	55714	ARCH

DWG STATUS	BLOCK	BLOCK	DWG NO.	DWG NO.	REVISION
CA	-	-	543	06	A.01