

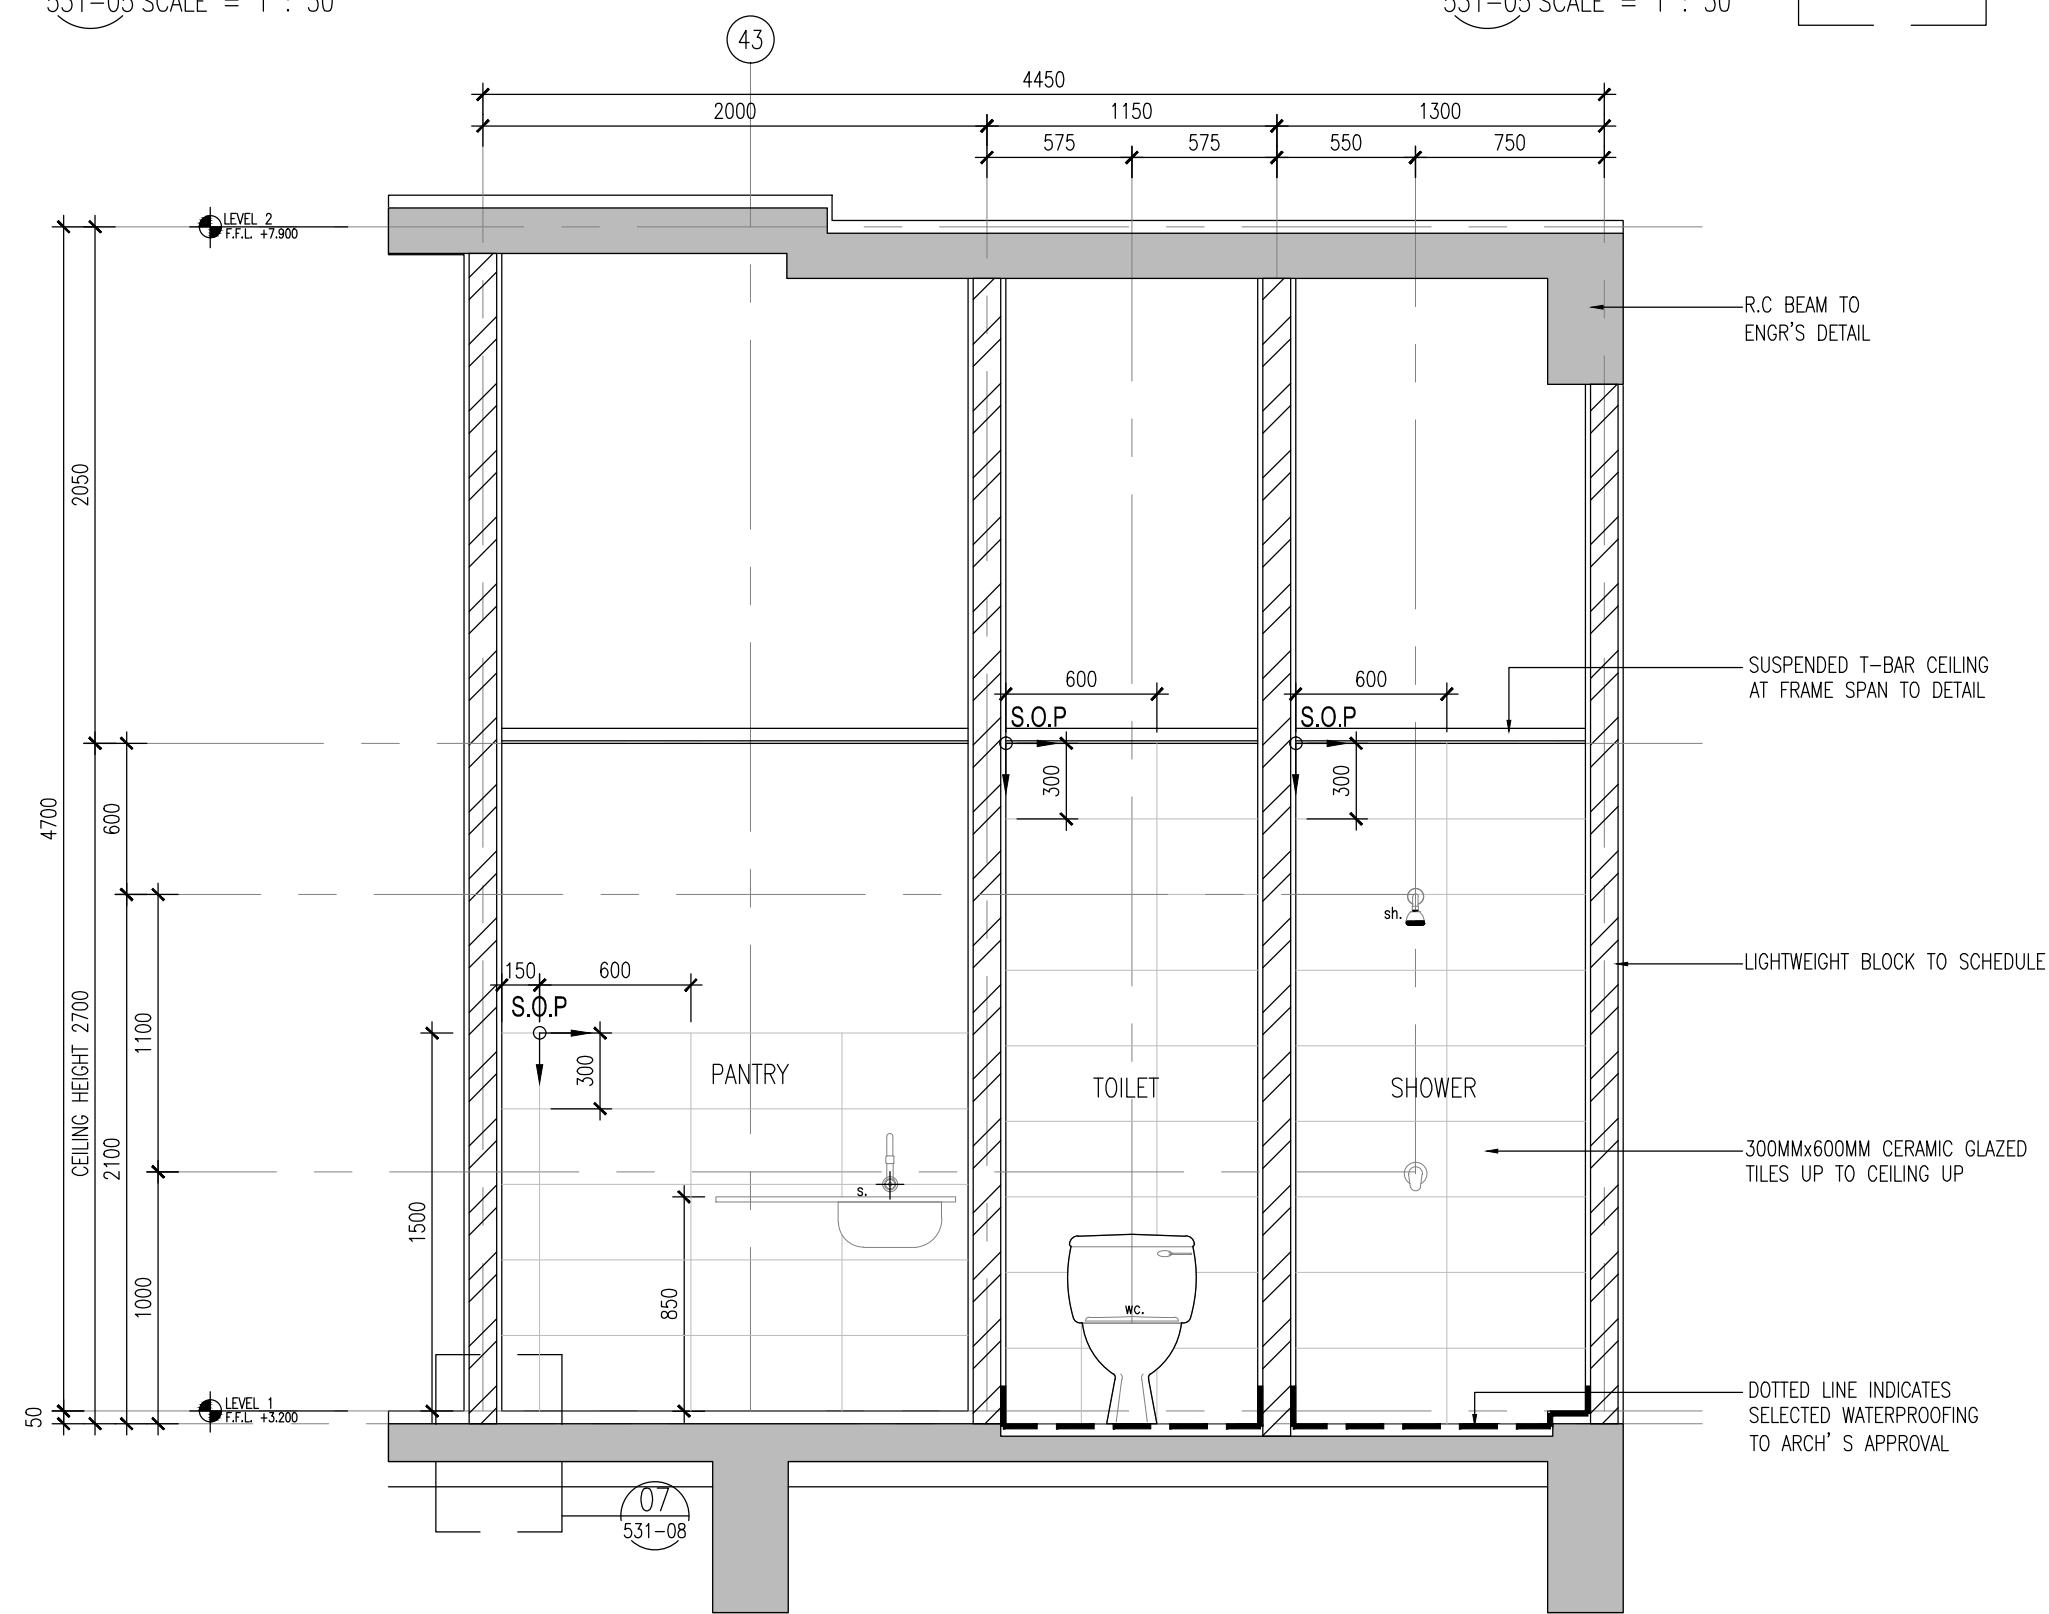
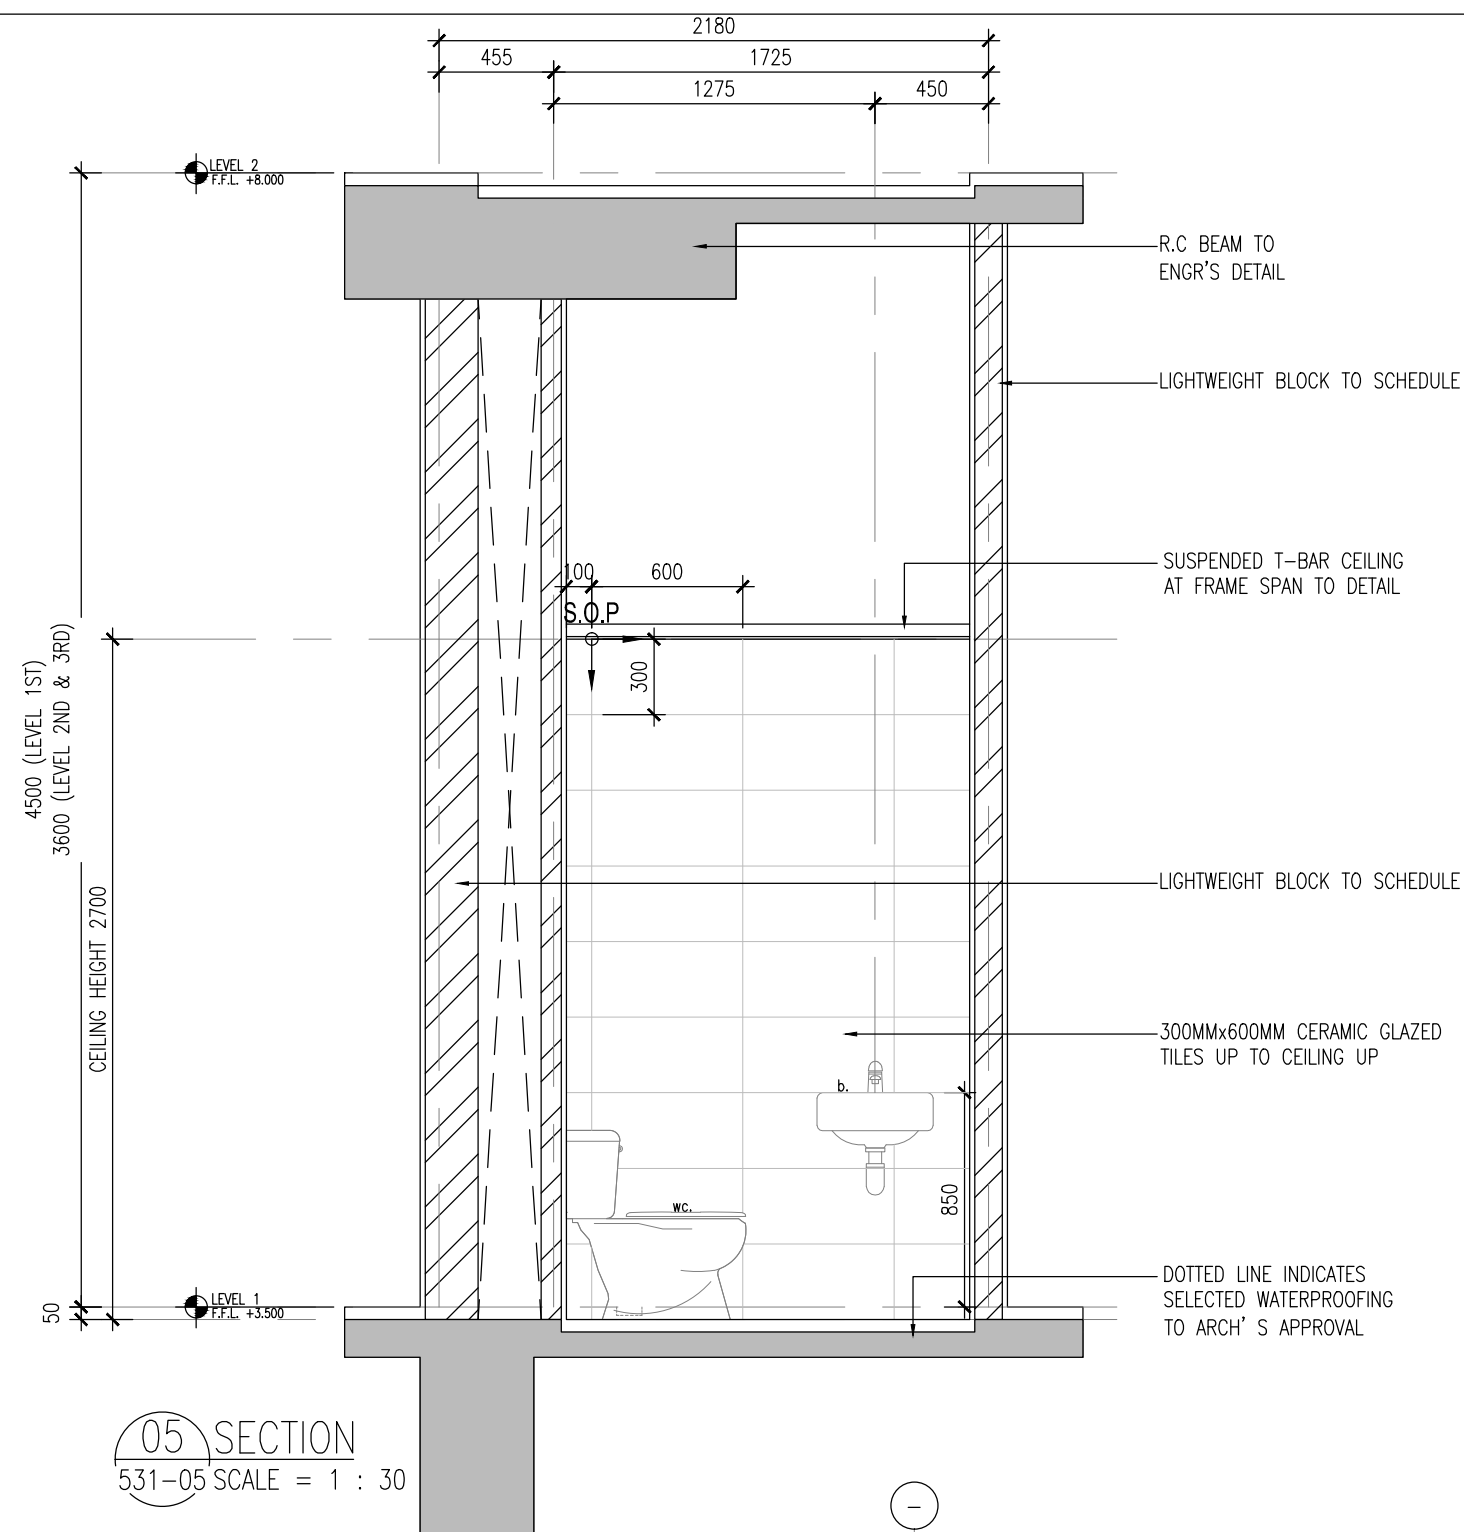
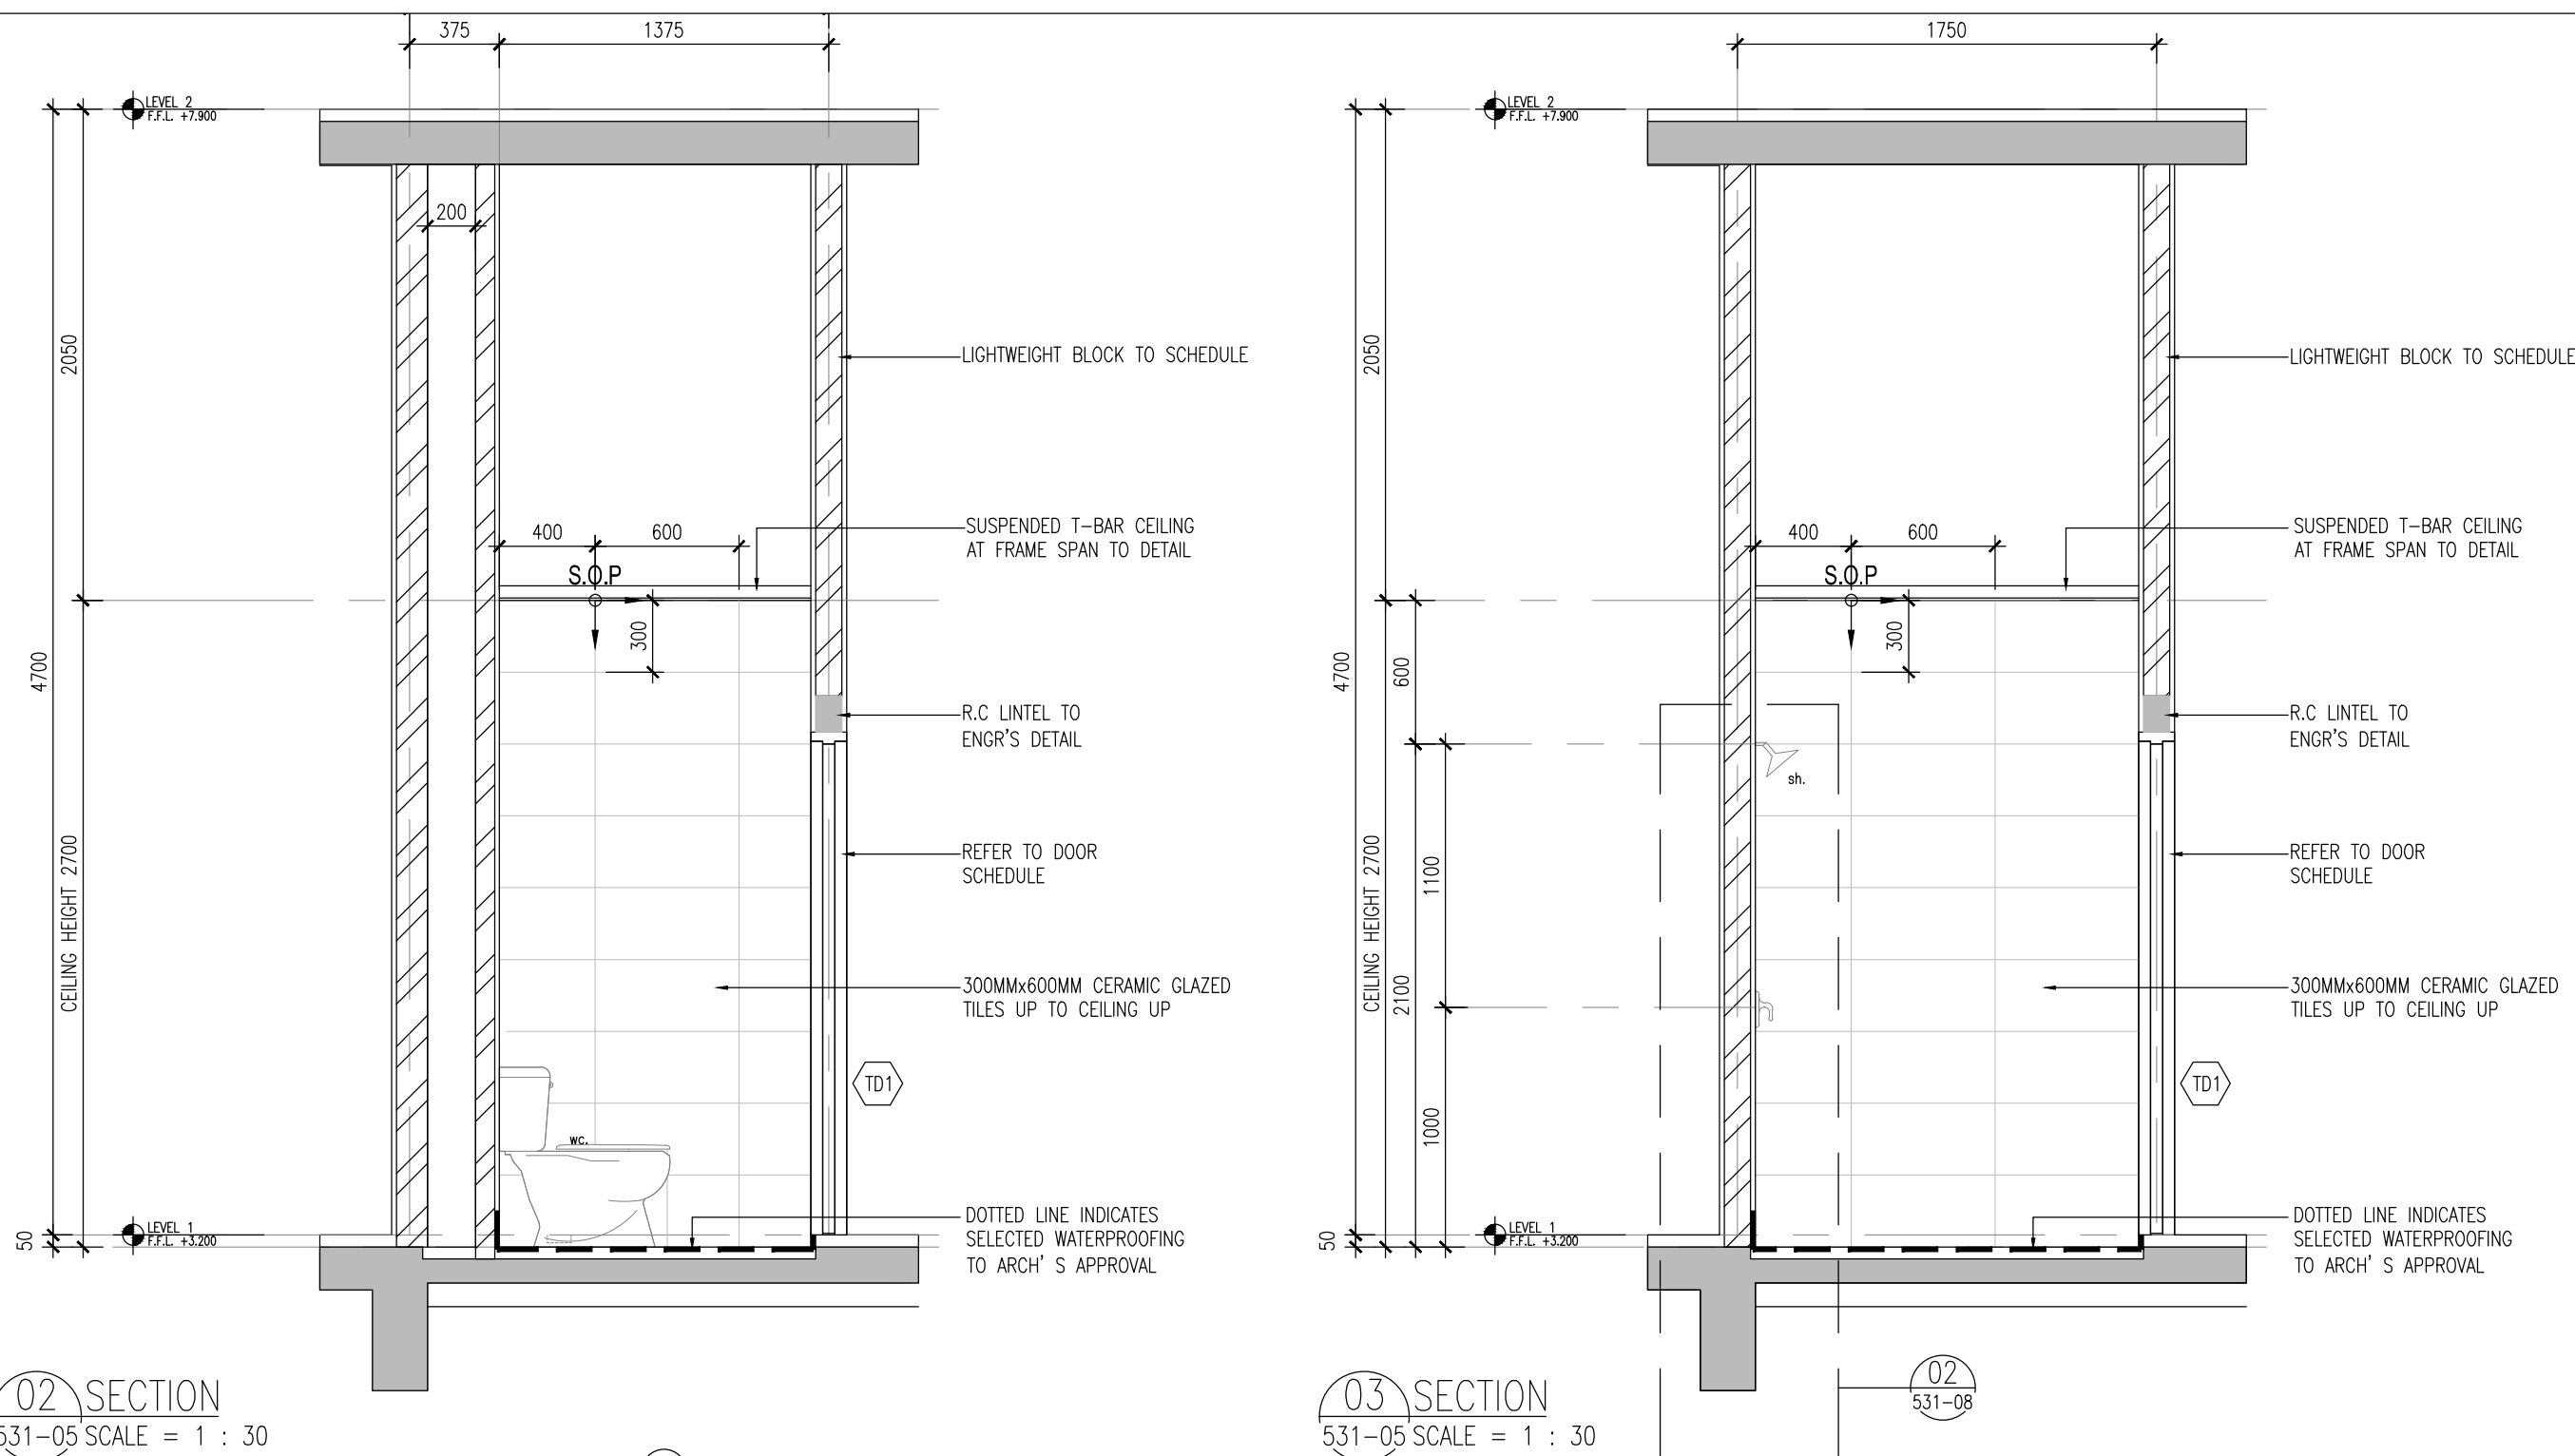
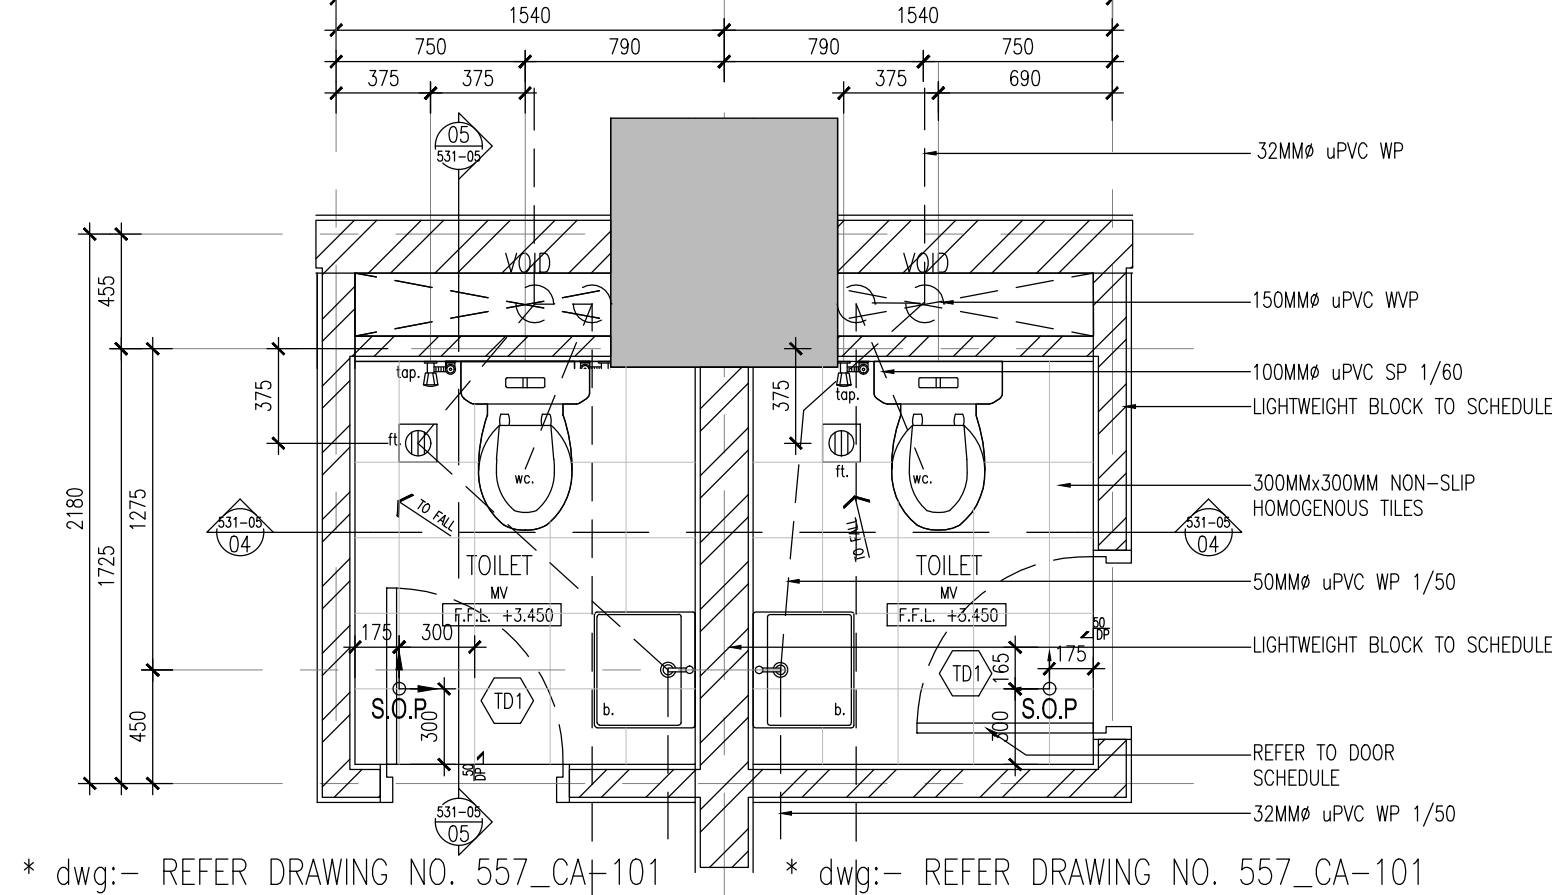


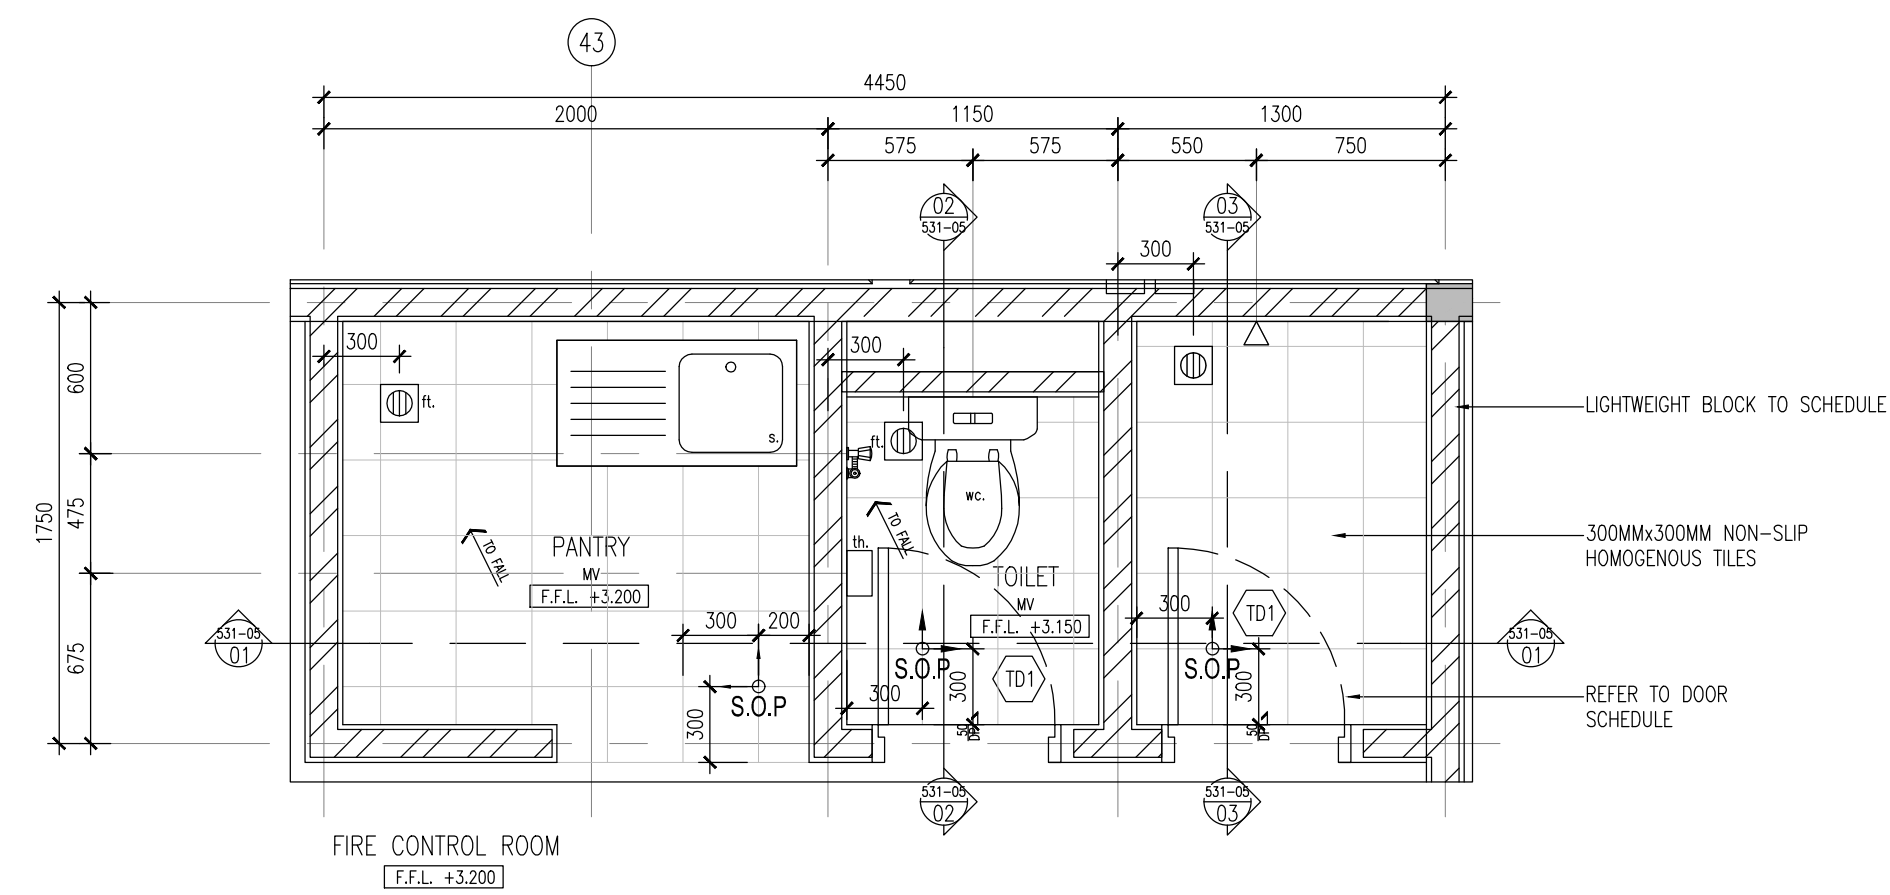

LEGEND- SANITARY FITTINGS	
FITTINGS	DESCRIPTION
b.	Vanity counter top lavatory
ft.	Floor trap
hb.	Hand bidet
hd.	Hand dryer
m.	6mm thk. Mirror
tap.	-
th.	Toilet paper holder
sq.	Squatting
sh.	Shower
s.	Sink
u.	Urinal
wc.	Water closet

LEGEND	
-	DESCRIPTION
mv	Mechanical ventilation

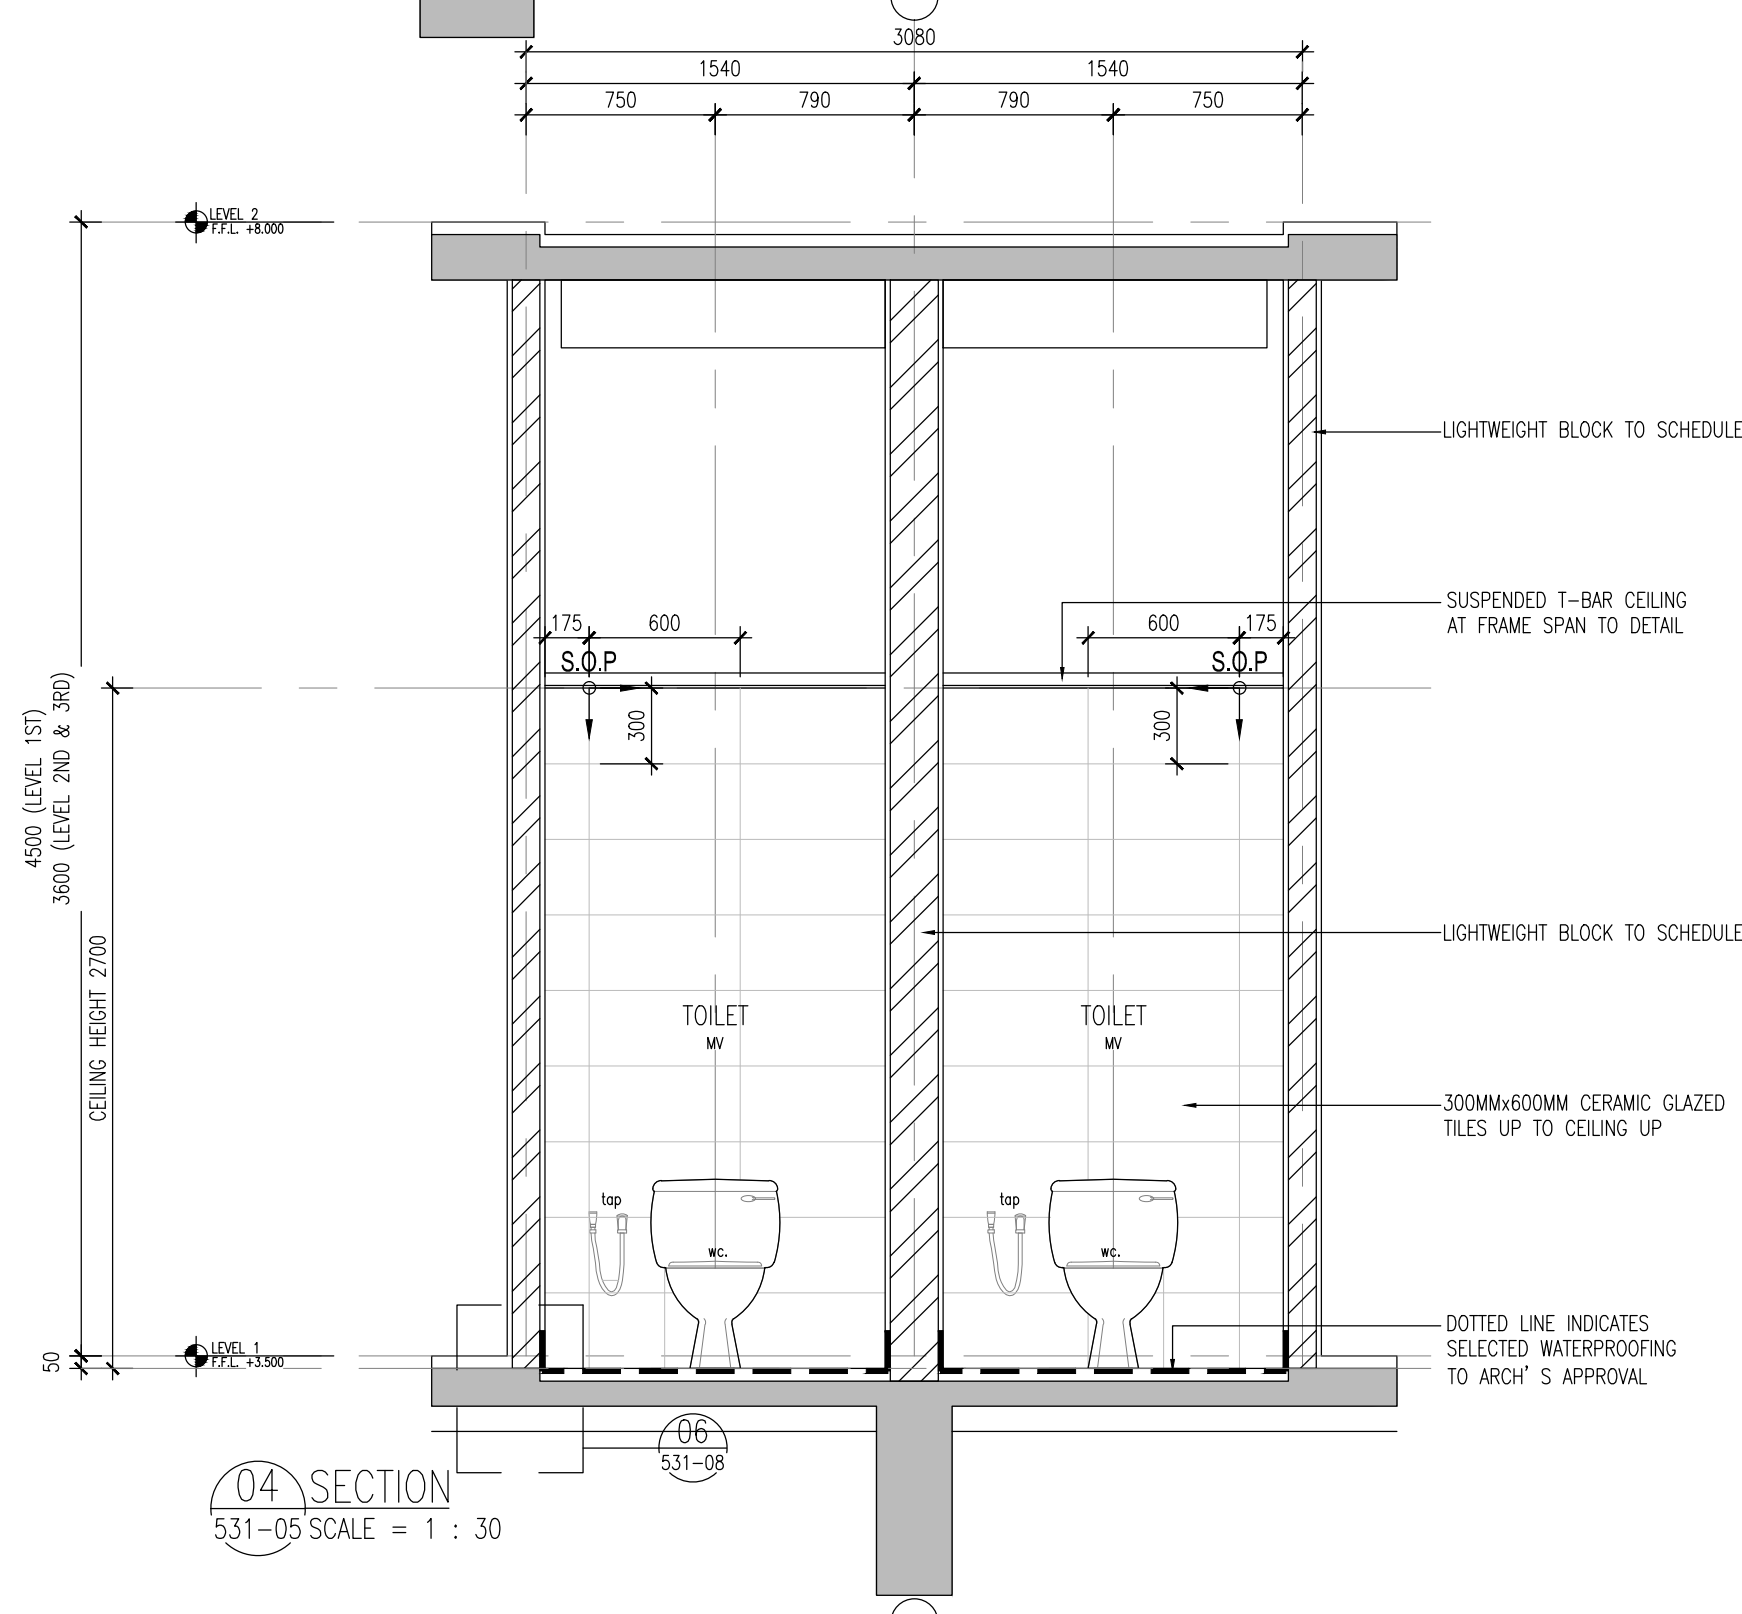


* dwg:- REFER DRAWING NO. 557_CA-101
PELAN LANTAI ARAS 1 & 2
01 TYPICAL RETAIL TOILET FLOOR PLAN (1ST-3RD)
100 SCALE = 1 : 30

* dwg:- REFER DRAWING NO. 557_CA-101
PELAN LANTAI ARAS 3
01 TYPICAL RETAIL TOILET FLOOR PLAN (1ST-3RD)
100 SCALE = 1 : 30

Hak Cipta Terpelihara. Tidak dibenarkan mencetak mana-mana bahagian ilustrasi dalam apa jua bentuk dan dengan apa cara pun samada secara elektronik, mencetak, mekanik, rakaman atau cara lain sebelum mendapat kebenaran bertulis dari NRY ARCHITECTS SDN. BHD.

REV.	DATE	DESCRIPTION	REMARK

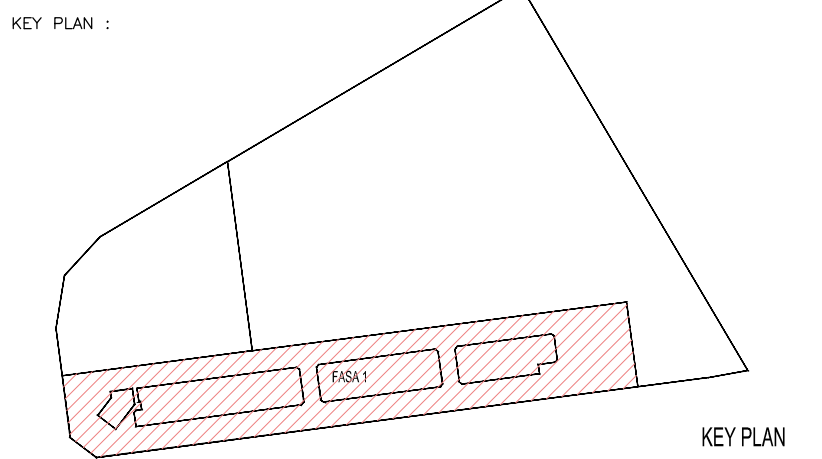

PROJECT TITLE :
CADANGAN PEMBANGUNAN BERCAMPUR (FASA 1) DI ATAS LOT 21608 (SEBAHAGIAN LOT 21135),PERSIARAN CASSIA BARAT 3, MUKIM 13, SEBERANG PERAI SELATAN,PULAU PINANG YANG MENDUNGUNGI-

- A. 2 BLOK PANGSAPURI PERKHIDMATAN 18 TINGKAT (612 UNIT)
B. KEDAI PEJABAT 3 TINGKAT (196 UNIT)
C. 5 TINGKAT TEMPAT LETAK KENDERAAN

PELAN PINDAAN DAN TAMBAHAN KEPADA PELAN LULUS NO. RUJ MPSP/40/20-73/42, BERTARIKH 17.08.2016

UNTUK : TETUAN PARAMOUNT PROPERTY (PW) SDN. BHD

LAND OWNER & BUILDING OWNER :

NAMA : MR. OOI HUN PENG
JAWATAN : KETUA PEGAWAI EKSEKUTIF
NO IC : 650619-02-5311
ALAMAT : PARAMOUNT PROPERTY (PW) SDN. BHD
WISMA PARAMOUNT, 1A (1ST FLOOR), LORONG BLM 1/1,
BANDAR LAGUNA MERBOK, 08000 SUNGAI PETANI, KEDAH
NO. TEL : 604 - 441 9191 FAX : 604 - 441 9090

KITCHEN SPECIALIST :

QS CONSULTANT :

M&E CONSULTANT :
PERUNDING P.L.A.
Consulting Mechanical & Electrical Engineers.
8-01, WISMA PANTAI, TEL. NO. : (604) 3337990
JALAN WISMA PANTAI, FAX NO. : (604) 3317337
12200 BUTTERWORTH, PENANG. E-MAIL : project@pla-a-group.com

C&S CONSULTANT :
PERUNDING KELANA
CIVIL & STRUCTURAL ENGINEERS
Level 12, Unit 12(D), Wisma Boon Siew,
No.1, Penang Road, 10000 Penang.
Tel: 2622628, Fax: 2641618
(Company No. AS0232772-W)

DESIGN ARCHITECT :
ARCHITECTURE GROUP - STUDIO A
CPG CONSULTANTS PTE LTD
238B, THOMSON ROAD, #12-00 TOWER B
NOVENA SQUARE, SINGAPORE 307985
TEL: +65 6357 4468 FAX: +65 6357 4469

ARCHITECT :
BH YEW
ARCHITECT (SP/Y61)
15TH FLOOR, BANGUNAN AMMELIFE
NO.1, JALAN LUMUT, 50400 KUALA LUMPUR
TEL: (03) 4043-1346 FAX: (03) 4043-1349
EMAIL: ybhwat@nrasb.com.my

LEMBAGA
ARKITEK
ARKITEK
No.Pendaftaran: LAMA/Y61

Saya mengesahkan bahawa pelan-pelan yang dihandar adalah mengikut Undang-Undang Kecil Bangunan Seragam 1988 dan Undang-Undang Kecil Bangunan Seragam (pindaan) 2007 [UKBS2007] dan (pindaan-pindaan serta garapan-garapan dan patah-patah) Majlis Perbandaran Seberang Perak. Saya mengesahkan bahawa kerja-kerja pembinaan akan dijalankan dengan peraturan yang ditetapkan. Saya mengesahkan dan menguik bahawa pelan-pelan bangunan adalah setaraf dengan pelan kebenaran merancang yang diilukan dan akan memulau ulukan serta sistem-sistem berkaitan.

CONSTRUCTION DRAWING

MAY 2017

LURKAN :

TOILET-FIRE CONTROL ROOM
& TYPICAL RETAIL TOILET- LEVEL 1-3
TOILET FLOOR PLAN
SECTION

SCALE: AS SHOWN	CAD NO: 557_CA-531-05	DATE: MAY 2017
DRAWN BY: -	CHECKED BY: JANICE	DISCIPLINE: ARCH
ORIGINATOR ACRONYM BH YEW	PROJECT NO. 55714	REVISION A.01
DWG STATUS CA	LOT -	DWG NO. 531
ATTRIBUTE -	LEVEL -	REVISION A.01