


LEGEND			
SYMBOL	LIGHT FITTING DESCRIPTION	APPLICATION	QUANTITY
	POLE LIGHT (4M)	WALKWAY & LANDSCAPE AREA	24 nos
	ACCENT GARDEN LIGHT	COMPOUND AREA TO LIGHT UP TREESWALL	10 nos
	UNDERWATER UPLIGHT	WATER FEATURE	6 nos
	FLOOD LIGHT	DETENTION POND / HIGHLIGHT CREEPERS	6 nos
TOTAL OF LIGHTS			46 nos

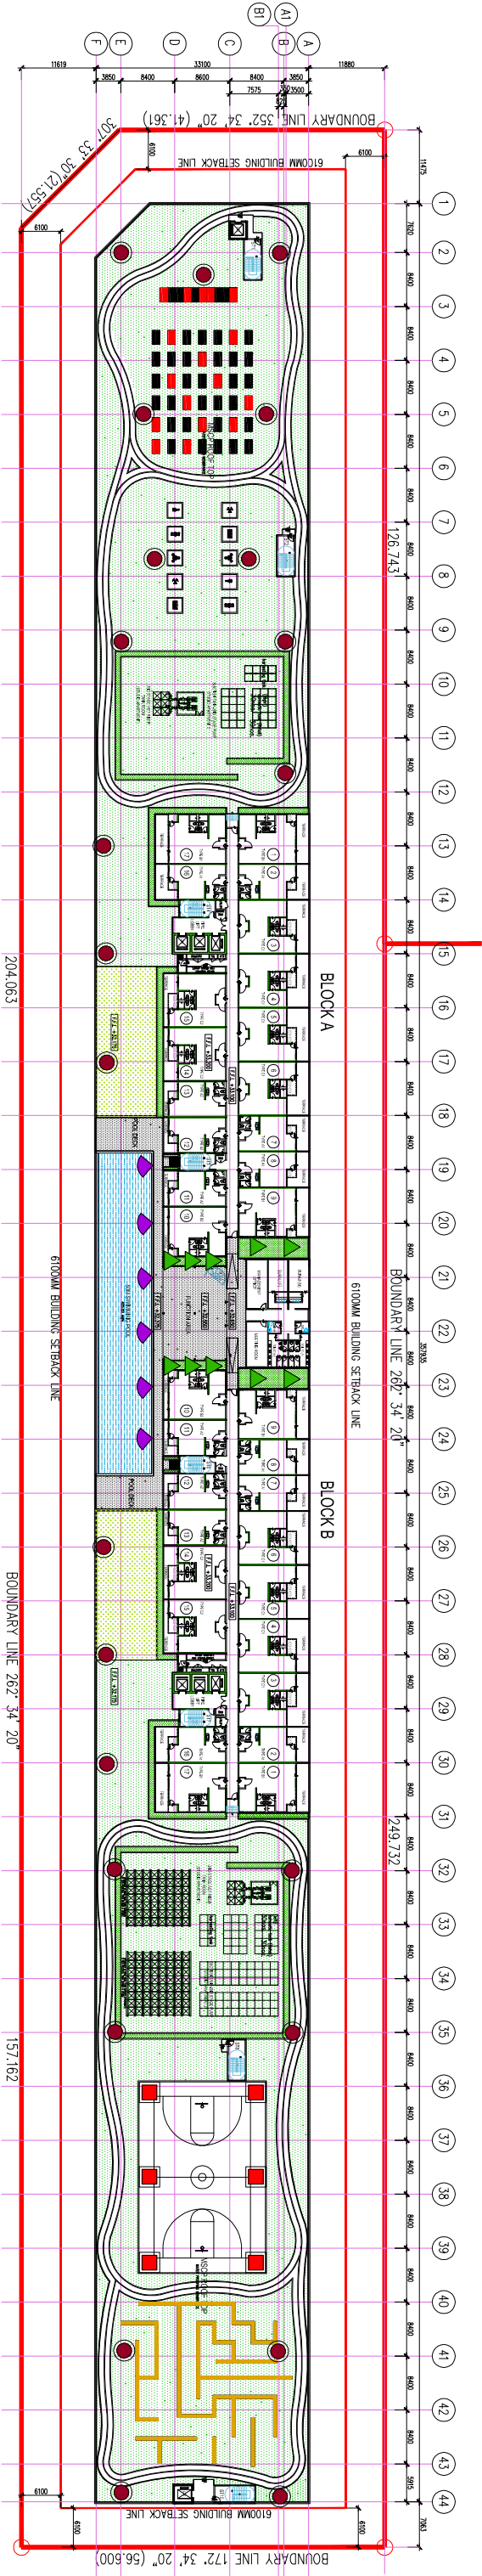

LIGHTING PLAN

PODIUM LANDSCAPE

SCALE 1 : 1000

LANDART design.sdn.bhd. 42, Chow Thye Road, 10950, Penang, Malaysia Tel: +604-229 5763 (S2) Fax: +604-229 1928 www.landart.com.my	PROJECT			CLIENT			DRAWING STATUS AND DATE :			DATE			REVISED			REF.			SCALE : AS SHOWN			A3			DRAWING NO : LA-15052-HD-PD-01			REV.		
	PLOT 1			PARAMOUNT PROPERTY (PV)																					SHEET NO.			PROJECT NO.		
	PROPOSED LANDSCAPE WORKS FOR CARANGAI MEHMA BERKAJIAN BERCAMPUR DI ATAS LOT 21135, PERSARAN CASSIA BARAT 3, MUKIM 13, SEBERANG PERAI SELATAN, PULAU PINANG, MALAYSIA			SDN. BHD.																					DATE : SEPT 2016			DRAWN BY : IZVAN		
	A, 2 BLOK PANGSAPURI PERKHIDAYATAN 18 TINGKAT (612 UNIT) B, KEDAI PELABAT 3 TINGKAT (196 UNIT) C, 5 TINGKAT TEMPAT LETAK KENDERAAN																								CHECKED BY : ATIF			FILE : 15052-PD-00-LIGHTING PLAN.DWG		