


MASTER PLAN
LEVEL 9 : DETAIL M - LIGHTING PLAN
SCALE 1 : 900

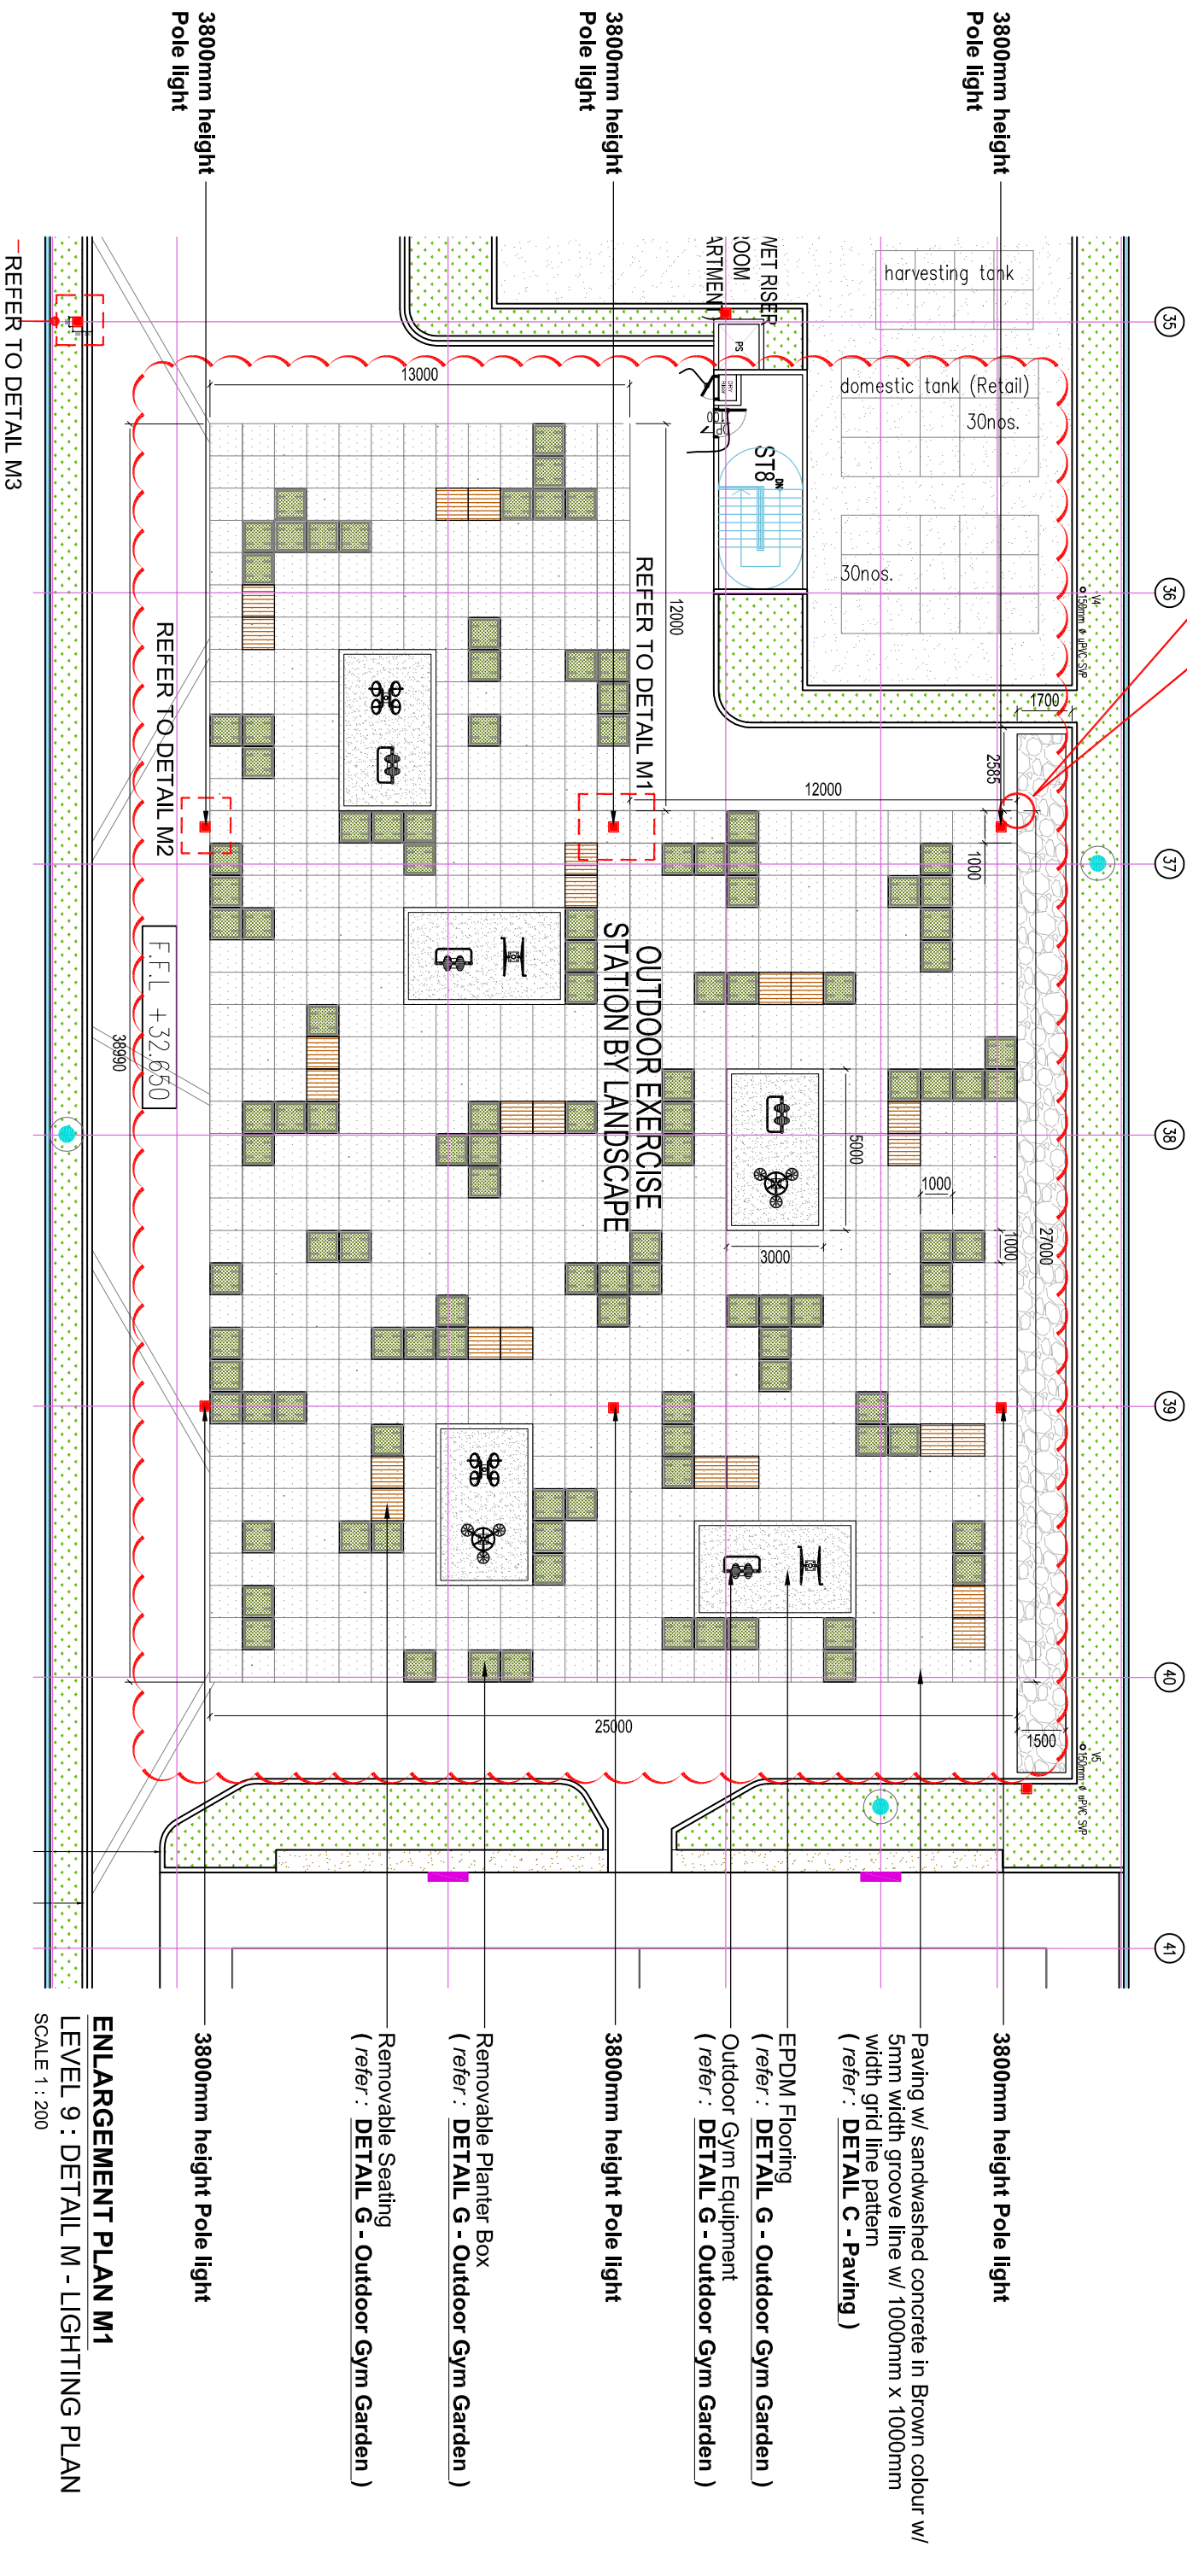

PROJECT PLOT 1 PROPOSED LANDSCAPE WORKS FOR CADANGAN MEMBINA PENBANGUNAN BERCAKUP DI ATAS LOT 11135, PERSIARAN CASSIA BARAT 3, MUKIM 13, SEBERANG PERAI SELATAN, PULAU PINANG YANG MENGENGADUNG: A. 2 BLOK PASAR DUA UNIT PERKHIDMATAN 18 TINGKAT (612 UNIT) B. 2 BLOK PASAR DUA UNIT PERKHIDMATAN 18 TINGKAT (612 UNIT) C. 5 TINGKAT TEMPAT LETAK KENDERAAN	CLIENT PARAMOUNT PROPERTY (PW) SDN. BHD.	DRAWING STATUS AND DATE : <u>CONSTRUCTION</u> <u>DRAWING</u> DECEMBER 2018	DATE	REVISED	REF.	SCALE :	AS SHOWN	A3	DRAWING NO :	REV.
			21/12/18	1200mm width gridline pattern change to 1000mm		UNIT :	MM	LA-15052-HD-PD-32a	05	
						DATE :	DEC 2018	SHEET NO.	PROJECT NO.	
						DRAWN BY :	RF	71	15052	
						CHECKED BY :	ATIF	--		
						FILE :	15052-PD-09-OUTDOOR GYM SETTING OUT			